



PLAN VIEW FOR 31M SPAN FOR STRAIGHT SPAN
(SCALE 1:60)

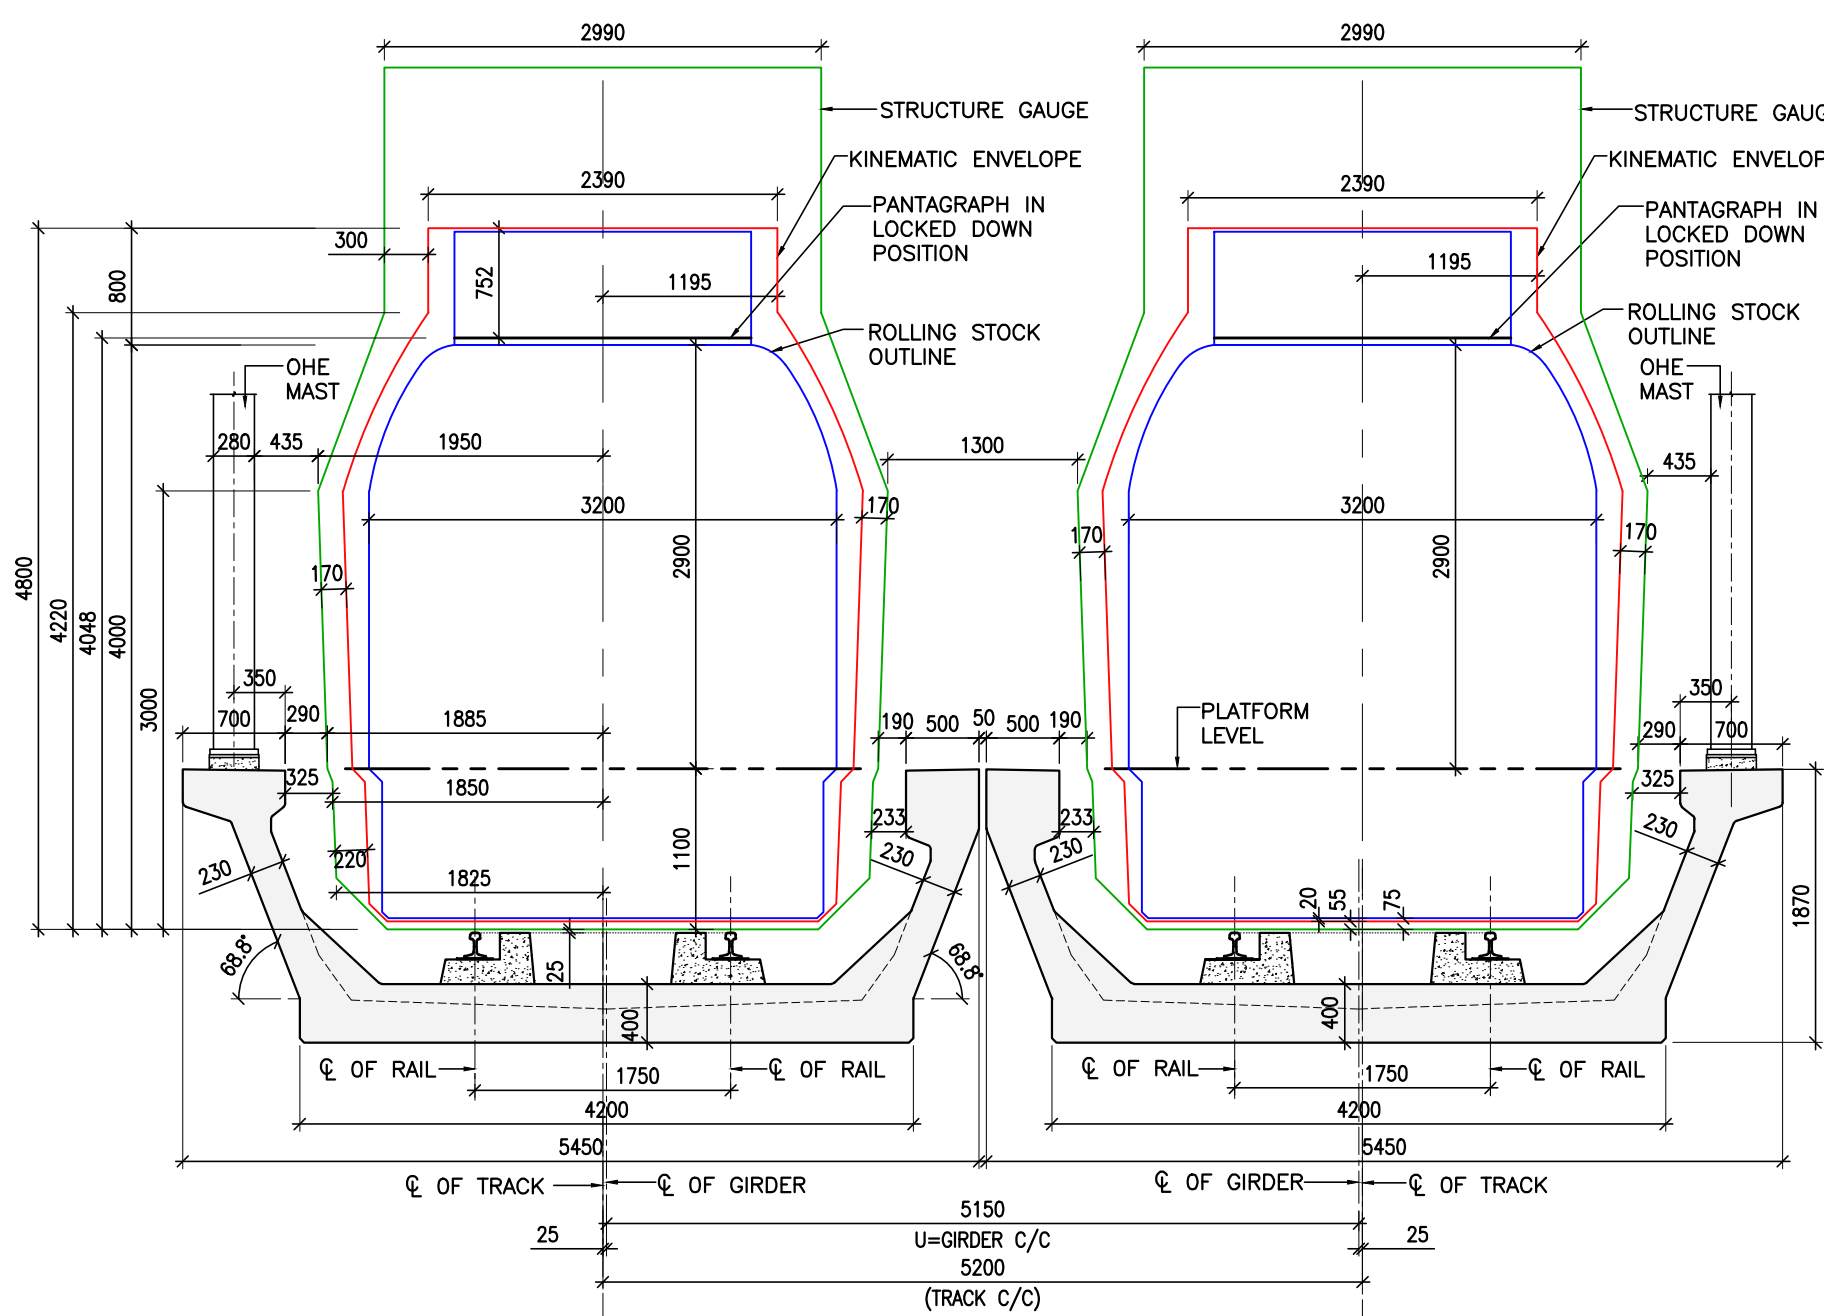



SECTION 1-1
(AT PIER LOCATION)
(SCALE 1:50)

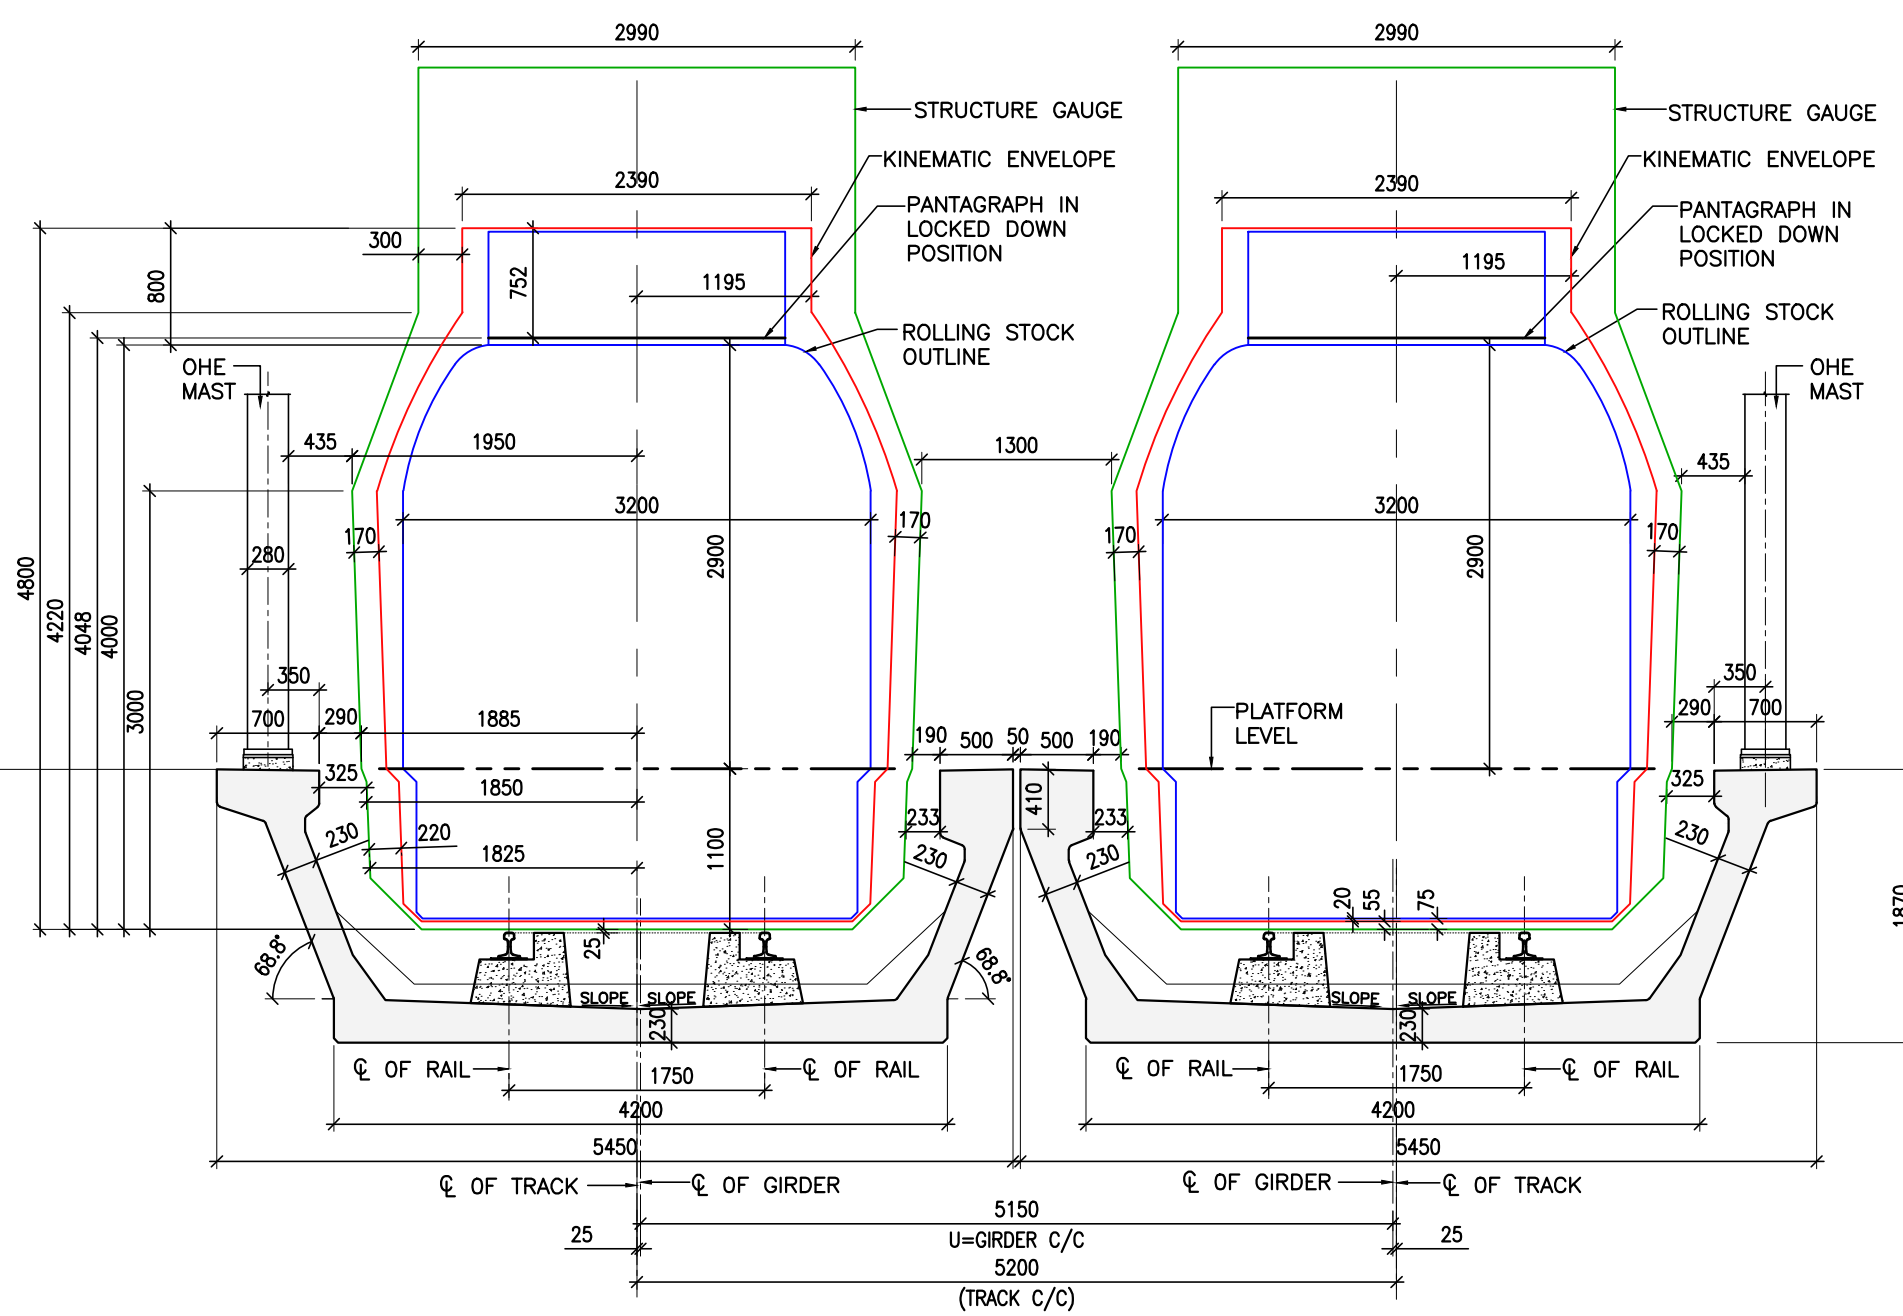

SECTION 1A-1A
(AT MID SPAN)
(SCALE 1:50)

REFERENCE DRAWINGS: (LATEST REVISION)

- | | | |
|----|---------------------------------------|--|
| 1. | 022077--BSRP--CR2-C-VD--GEN--30--1001 | GENERAL ARRANGEMENT AND DIMENSIONAL DETAIL OF STANDARD 31M SPAN SUPERSTRUCTURE |
| 2. | 022077--BSRP--CR2-C-VD--GEN--30--1002 | GENERAL ARRANGEMENT AND DIMENSIONAL DETAIL OF STANDARD 31M SPAN SUPERSTRUCTURE |
| 3. | 022077--BSRP--CR2-C-VD--GEN--30--1004 | REINFORCEMENT DETAILS OF STANDARD 31M SPAN SUPERSTRUCTURE |
| 4. | 022077--BSRP--CR2-C-VD--GEN--30--1005 | REINFORCEMENT DETAILS OF STANDARD 31M SPAN SUPERSTRUCTURE |
| 5. | 022077--BSRP--CR2-C-VD--GEN--30--5001 | PRE TENSIONED STRAND DETAILS FOR U-GIRDER |
| 6. | 022077--BSRP--CR2-C-VD--GEN--30--5006 | TYPICAL DETAIL OF ANCHOR & REINFORCEMENT OF PRECAST WEB OF U-GIRDER AT THE MAST LOCATION |
| 7. | 022077--BSRP--CR2-C-VD--GEN--30--5008 | TYPICAL REINFORCEMENT DETAILS AT LIFTING HOLE LOCATION FOR U-GIRDER |

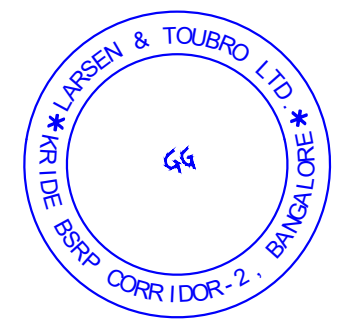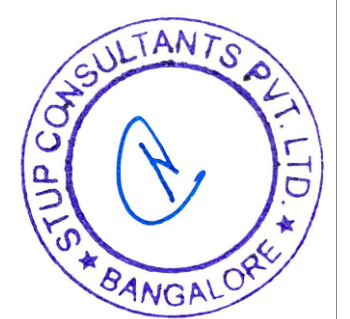

ABBREVIATION:

Ⓢ - CENTER LINE

NOTES:

- NOTES:**
1. ALL DIMENSIONS ARE IN MILLIMETERS LEVELS ARE IN METERS, UNLESS SPECIFIED OTHERWISE.
 2. FOLLOW FIGURED DIMENSIONS ONLY.
 3. ANY DISCREPANCIES MUST BE BROUGHT TO THE NOTICE OF THE CONSULTANT BEFORE EXECUTION OF WORK AT SITE.

GOOD FOR CONSTRUCTION

NOTES :

1. ALL DIMENSIONS ARE IN MILLIMETRES. UNLESS OTHERWISE MENTIONED.
2. DIMENSIONS ARE NOT TO BE SCALED, FOLLOW ONLY WRITTEN DIMENSIONS.


LEGEND :

REFERENCE DRAWINGS : (LATEST REVISION)

LICENSE :	
-----------	--

*THIS DESIGN FOR THE PROJECT HAVE BEEN
PREPARED UNDER LICENSE FROM M/S SYSTRA

KEY PLAN

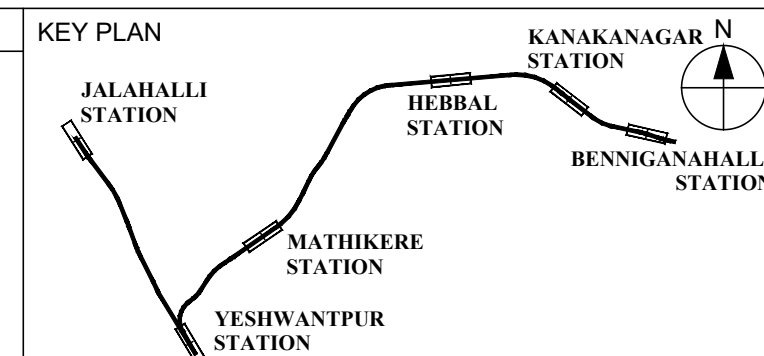

	STATION BOX KEY PLAN
--	----------------------



EMPLOYER :

[illegible]

REVISIONS		
0	15.07.2024	FOR CONSTRUCTION
E	16.04.2024	REVISED BY ADDING PATENT NOTE AND DUE TO CONGESTION OF REINFORCEMENT IN SITE
D	05.01.2024	REVISED AS MARKED AND AS PER PC'S COMMENTS
C	06.10.2023	FOR APPROVAL
B	12.12.2022	FOR APPROVAL
0	18.10.2022	FOR APPROVAL
REV	DATE	BRIEF DESCRIPTION

CONTRACTOR :



 <p>STUP Consultants Pvt. Ltd. JP & Devi Jambukeshwar Arcade # 59, 4th Floor, Millers Road, Bangalore-560052. Tel : 080-40397979 Email : bangalore@assystem.com</p>	<p>PROOF CONSULTANT (PC) :</p> <div style="display: flex; align-items: center;">  <p>Indian Institute of Technology Madras IIT P.O., Chennai 600 036 INDIA</p> </div>
--	--

[illegible]

<p>The responsibility of control, check and verification of accuracy, correctness, completeness, integration and full compliance of Contract provisions in respect of design analysis and drawing rests with Design & Build Contractor.</p>

	DDC			PC	Contractor
SIGN					
DATE	09.05.2024	09.05.2024	09.05.2024	-	09.05.2024
NAME	ABDULLA S	VIJAYENDRA J	SHASHIDHAR C	-	KVM
	PREPARED BY	CHECKED BY	APPROVED BY	APPROVED BY	ISSUED BY


GENERAL CONSULTANTS				
	CHECKED & APPROVED		COUNTER SIGN	
	NAME	SIGN	PROJECT DIRECTOR	
CIVIL/GAD			SIGN	
CIVIL-ALIGNMENT			NAME	
CIVIL-STRUCTURAL			DATE	
CIVIL-GEOTECH				

--	--

OR	K BIDE

	DESIGNATION	SIGN	DATE
CIVIL-GAD			
CIVIL-ALIGNMENT			
CIVIL-STRUCTURAL	GM/CIVIL/DESIGN		

EMPLOYER :

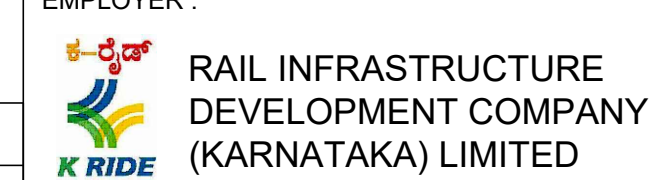

GENERAL CONSULTANTS :



PROJECT :	BENGALURU SUBURBAN RAILWAY PROJECT (BSRP) K-RIDE CORRIDOR - 2
-----------	--

DRAWING TITLE : GAUGES AND CLEARANCES - 31 M SPAN -
STRAIGHT SPAN - PLAN VIEW & SECTION VIEW

P	DRAWING NO. : 022077-BSRP-CR2-C-VD-GEN-30-1006	
	SCALE : AS SHOWN	DATE : 09.05.2024

REVISION	DWG STATUS
0	C

SCALE : AS SHOWN		DATE : 09.03.2024			
PRELIMINARY DWG (P), DEFINITIVE DWG (D), CONSTRUCTION DWG (C), AS BUILT DWG (B), SHOP DWG (S), MANUFACTURED DWG (M)					SHEET SIZE - A1
FIL ENAME		Δ			