
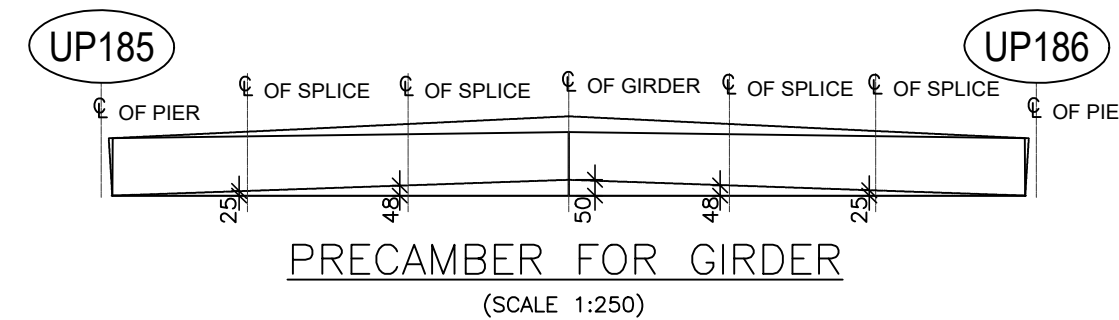
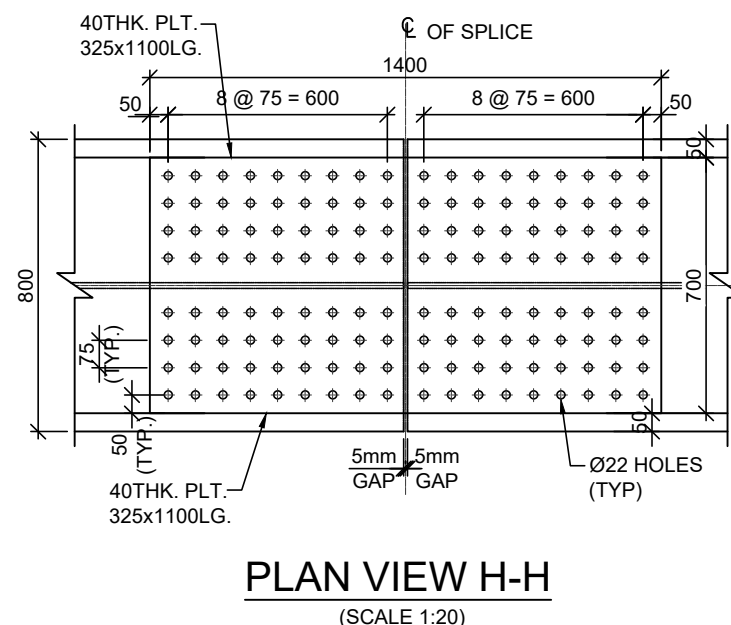
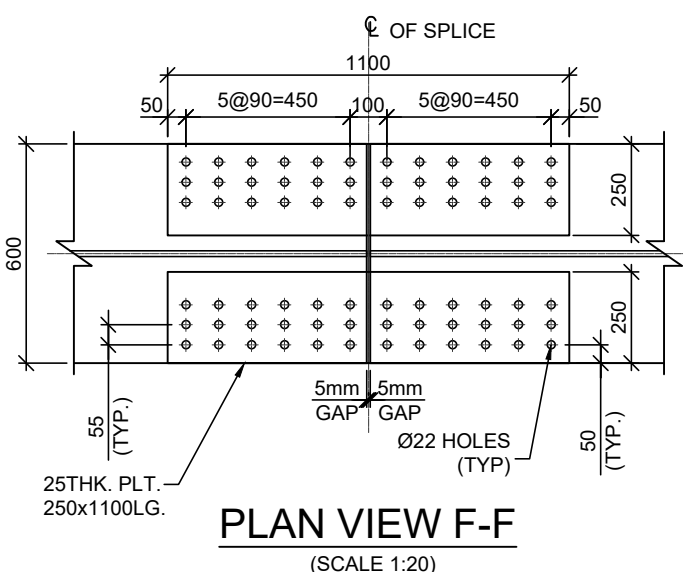
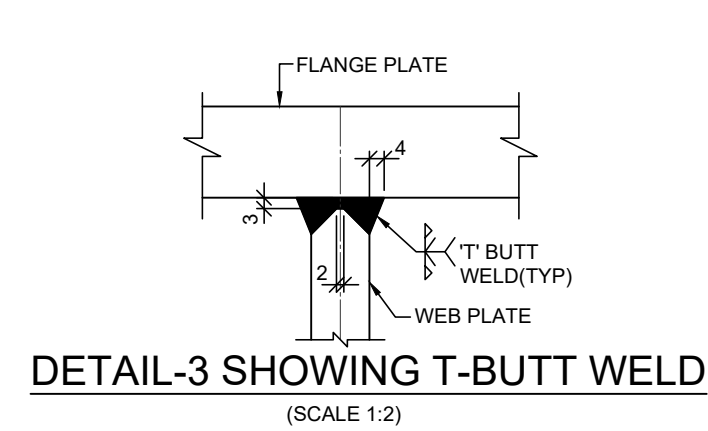
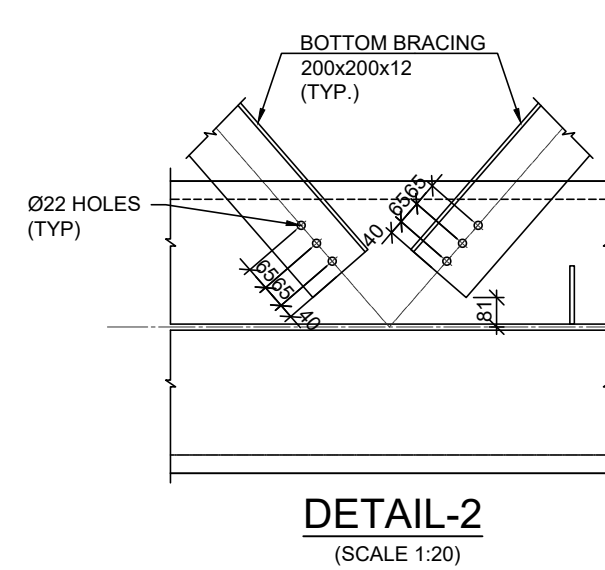
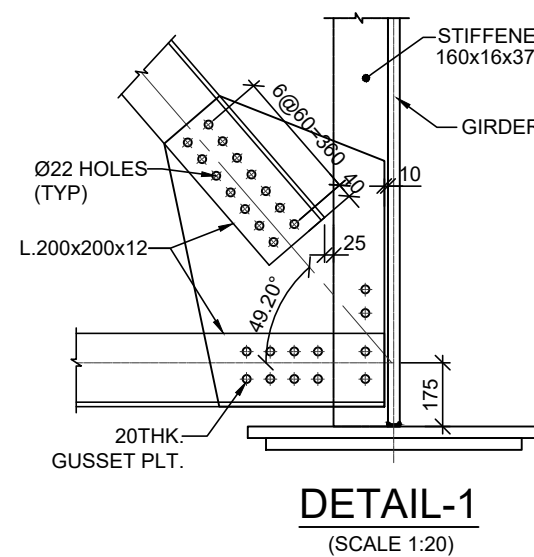
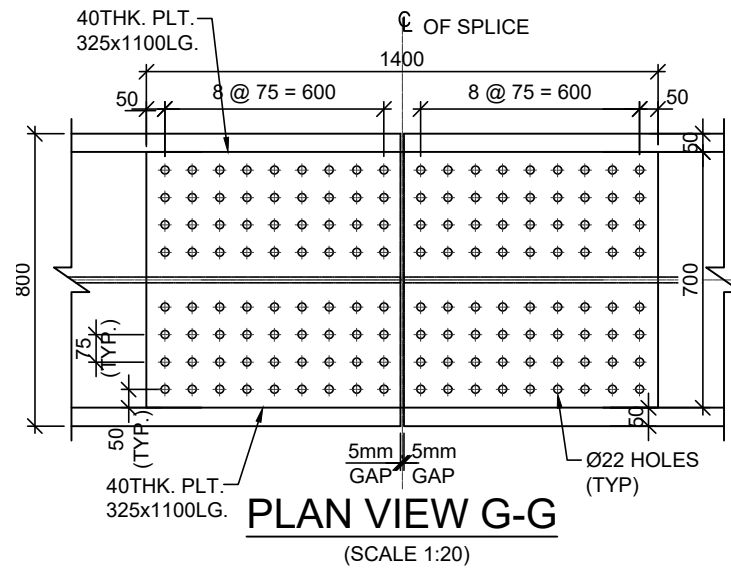
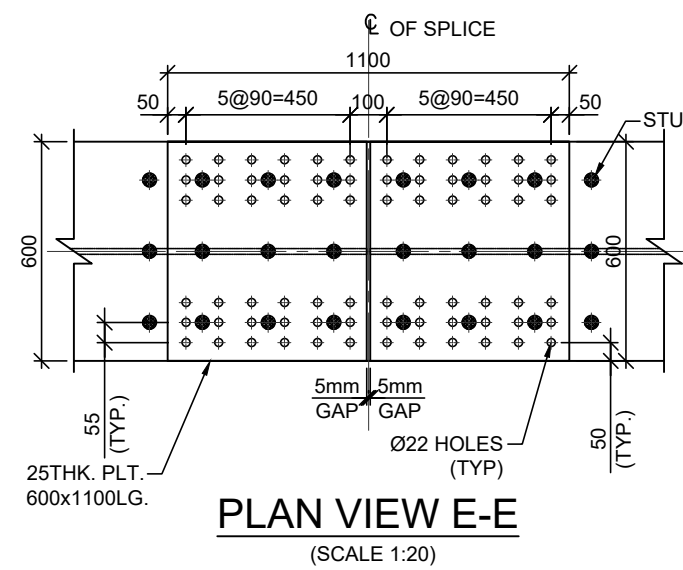
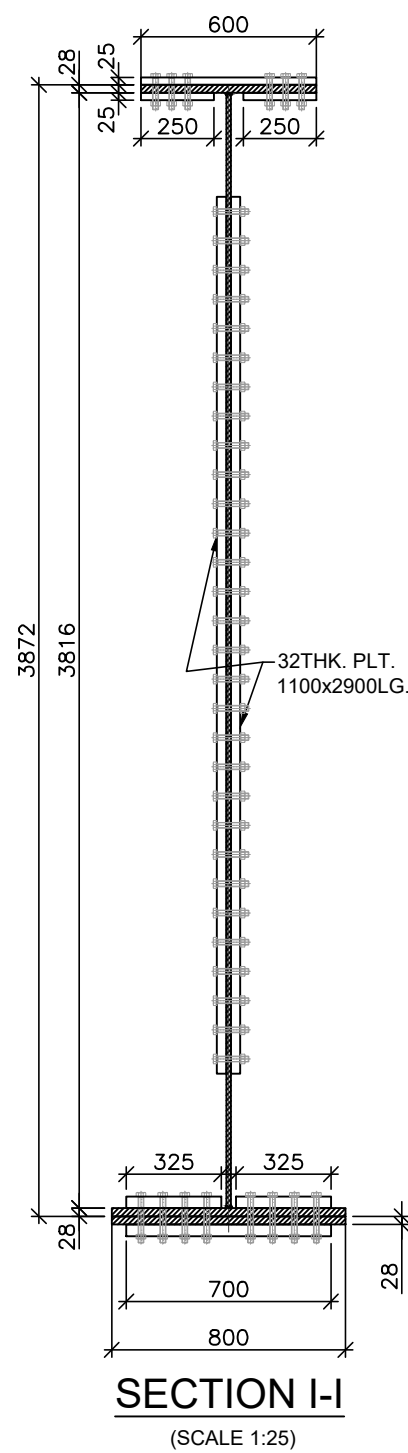
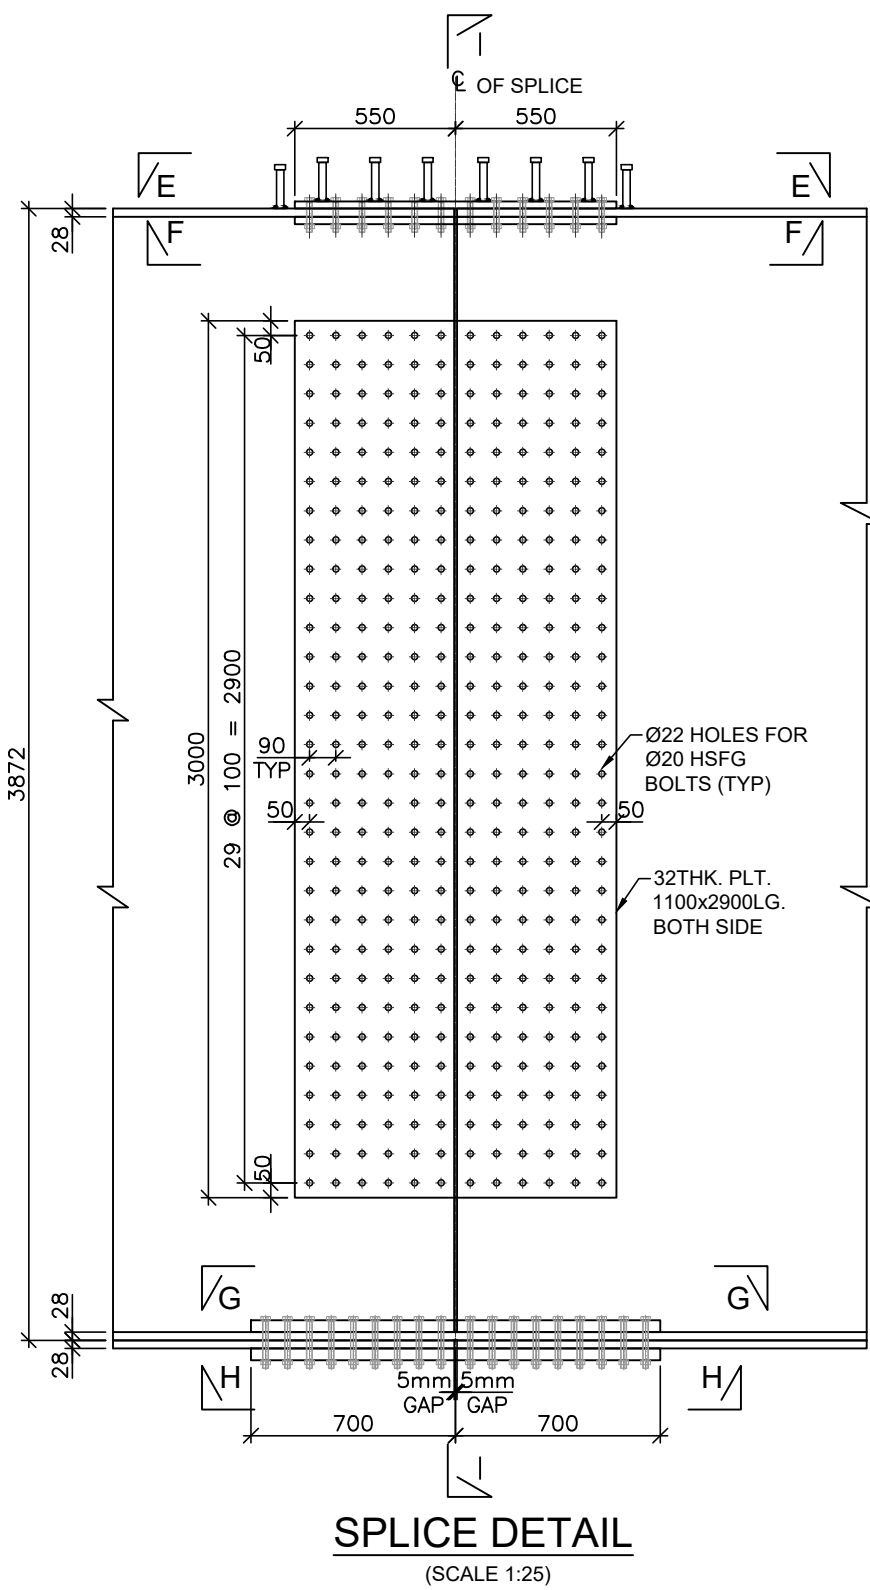
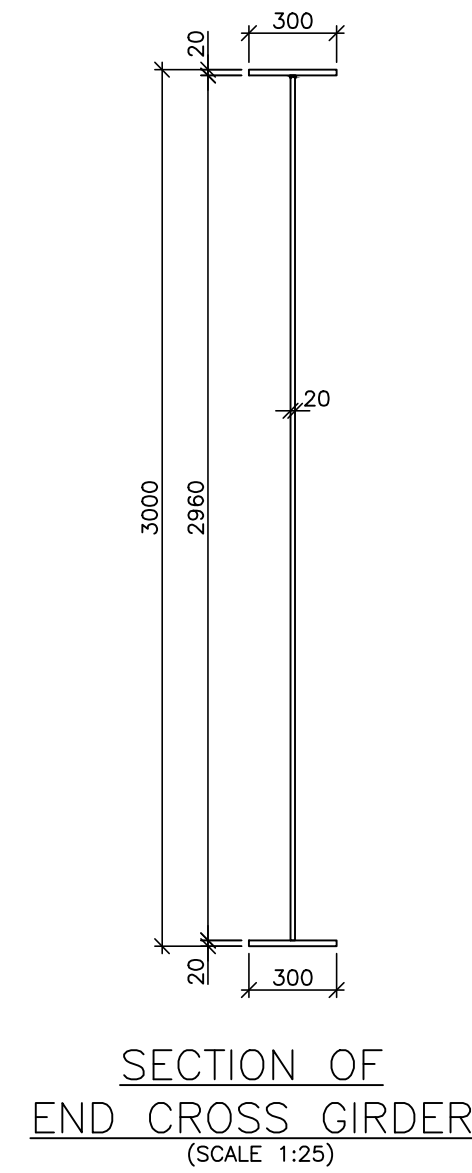
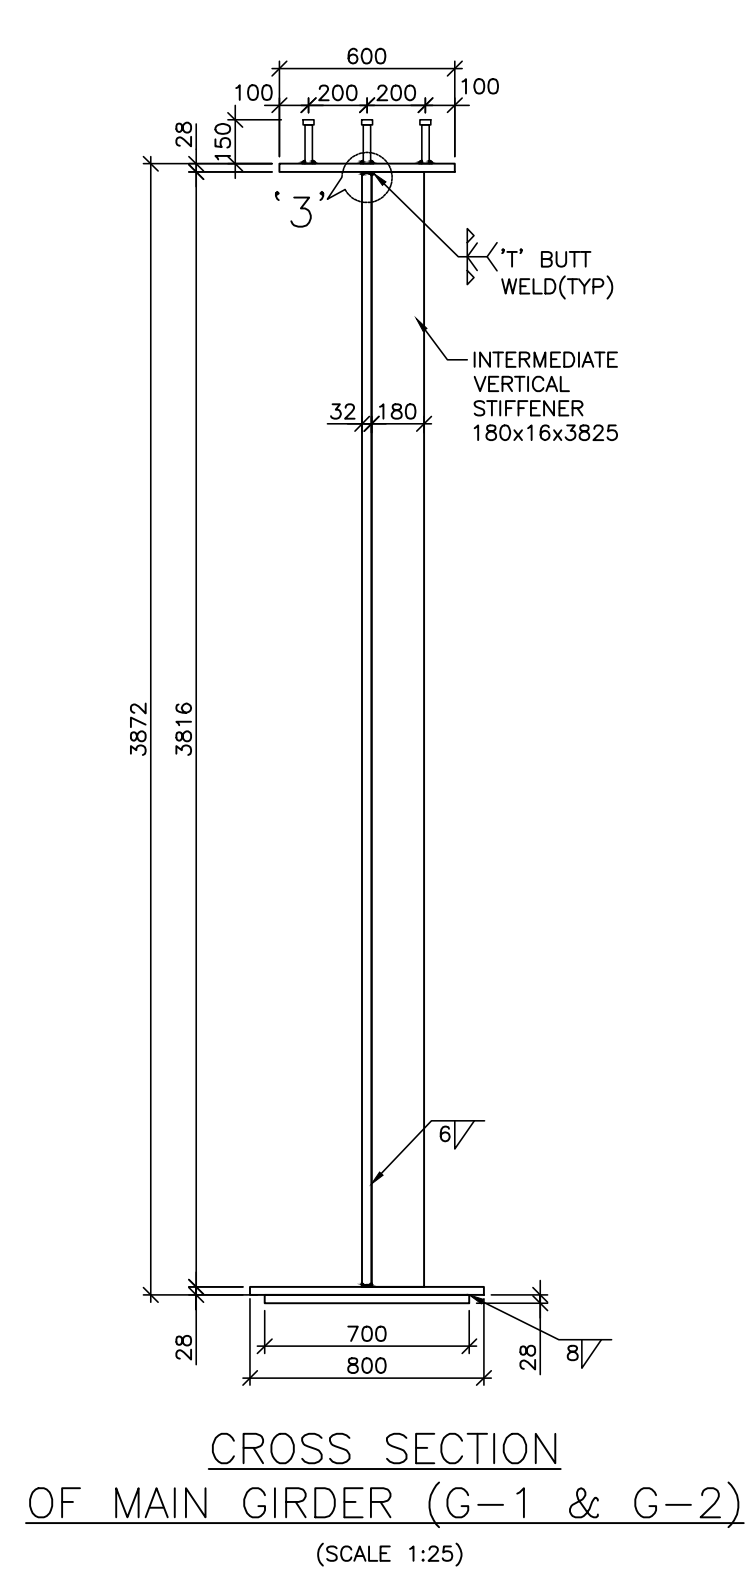
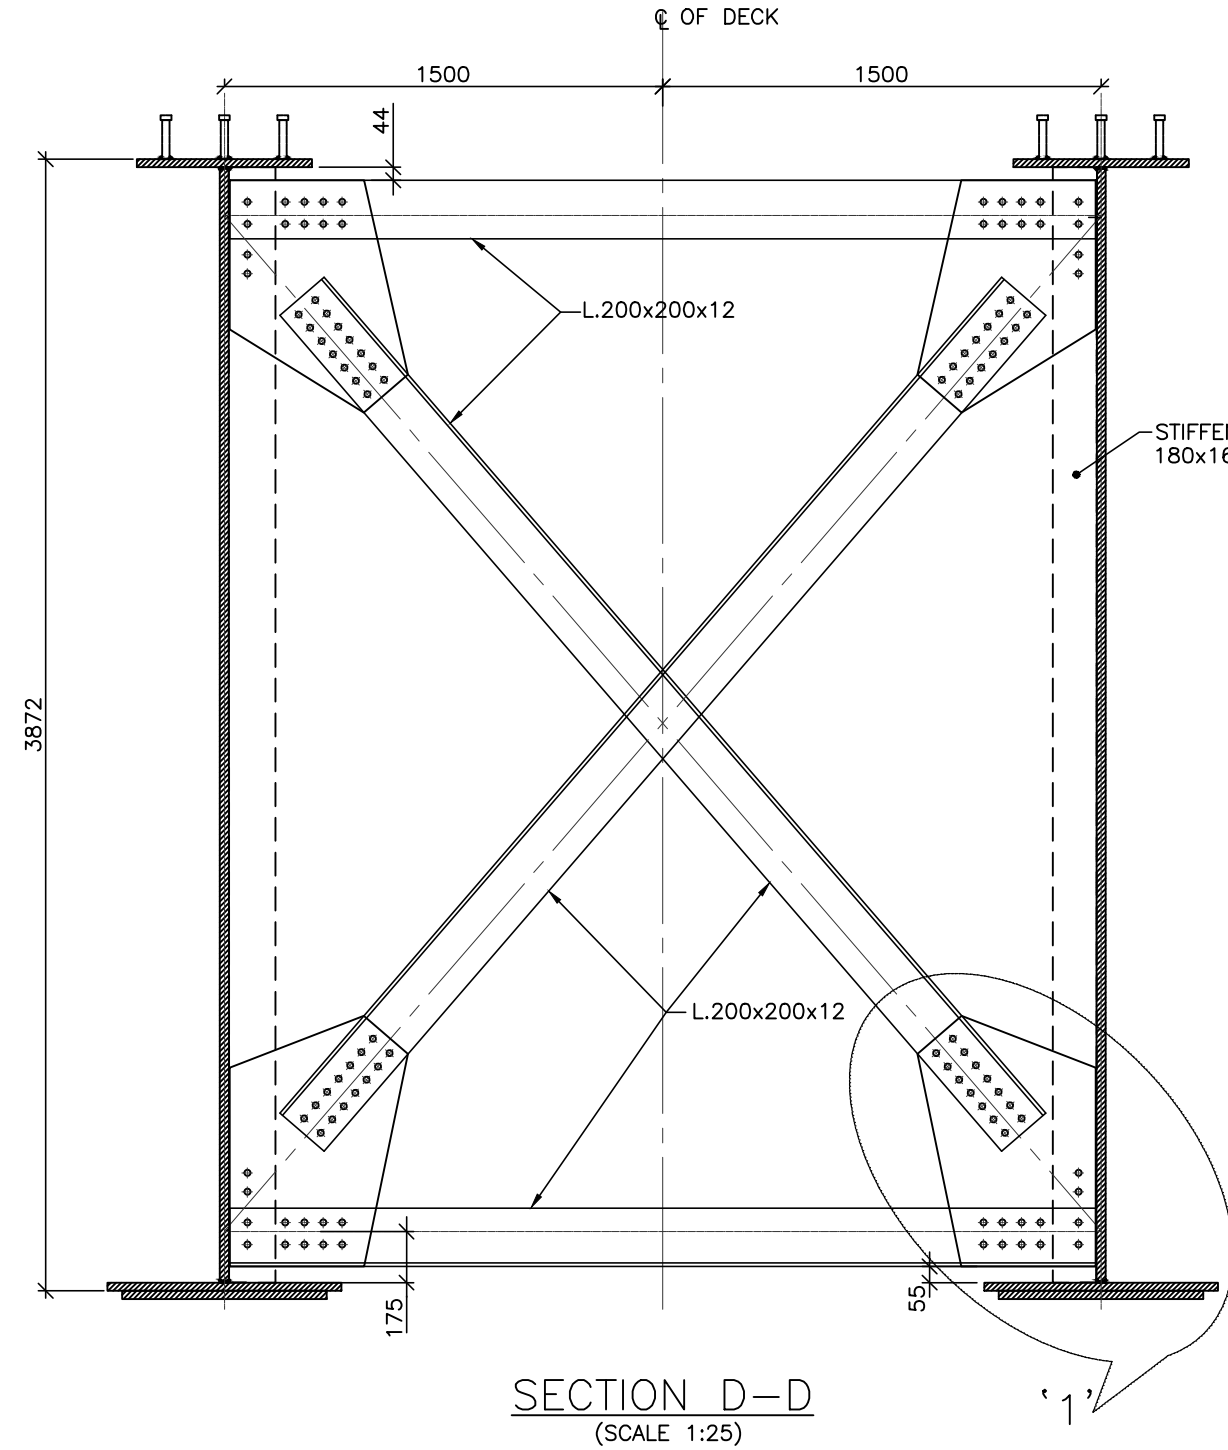


CONSTRUCTION SEQUENCE:-

1. GIRDER TO BE ASSEMBLED AT SITE WITH CROSS BRACINGS.
2. BOTH GIRDERS TO BE LIFTED AND PLACED ON BEARINGS.
3. SLAB TO BE CAST IN SITU - GIRDER CARRIES WEIGHT OF GREEN CONCRETE.
4. CASTING OF SIDL.

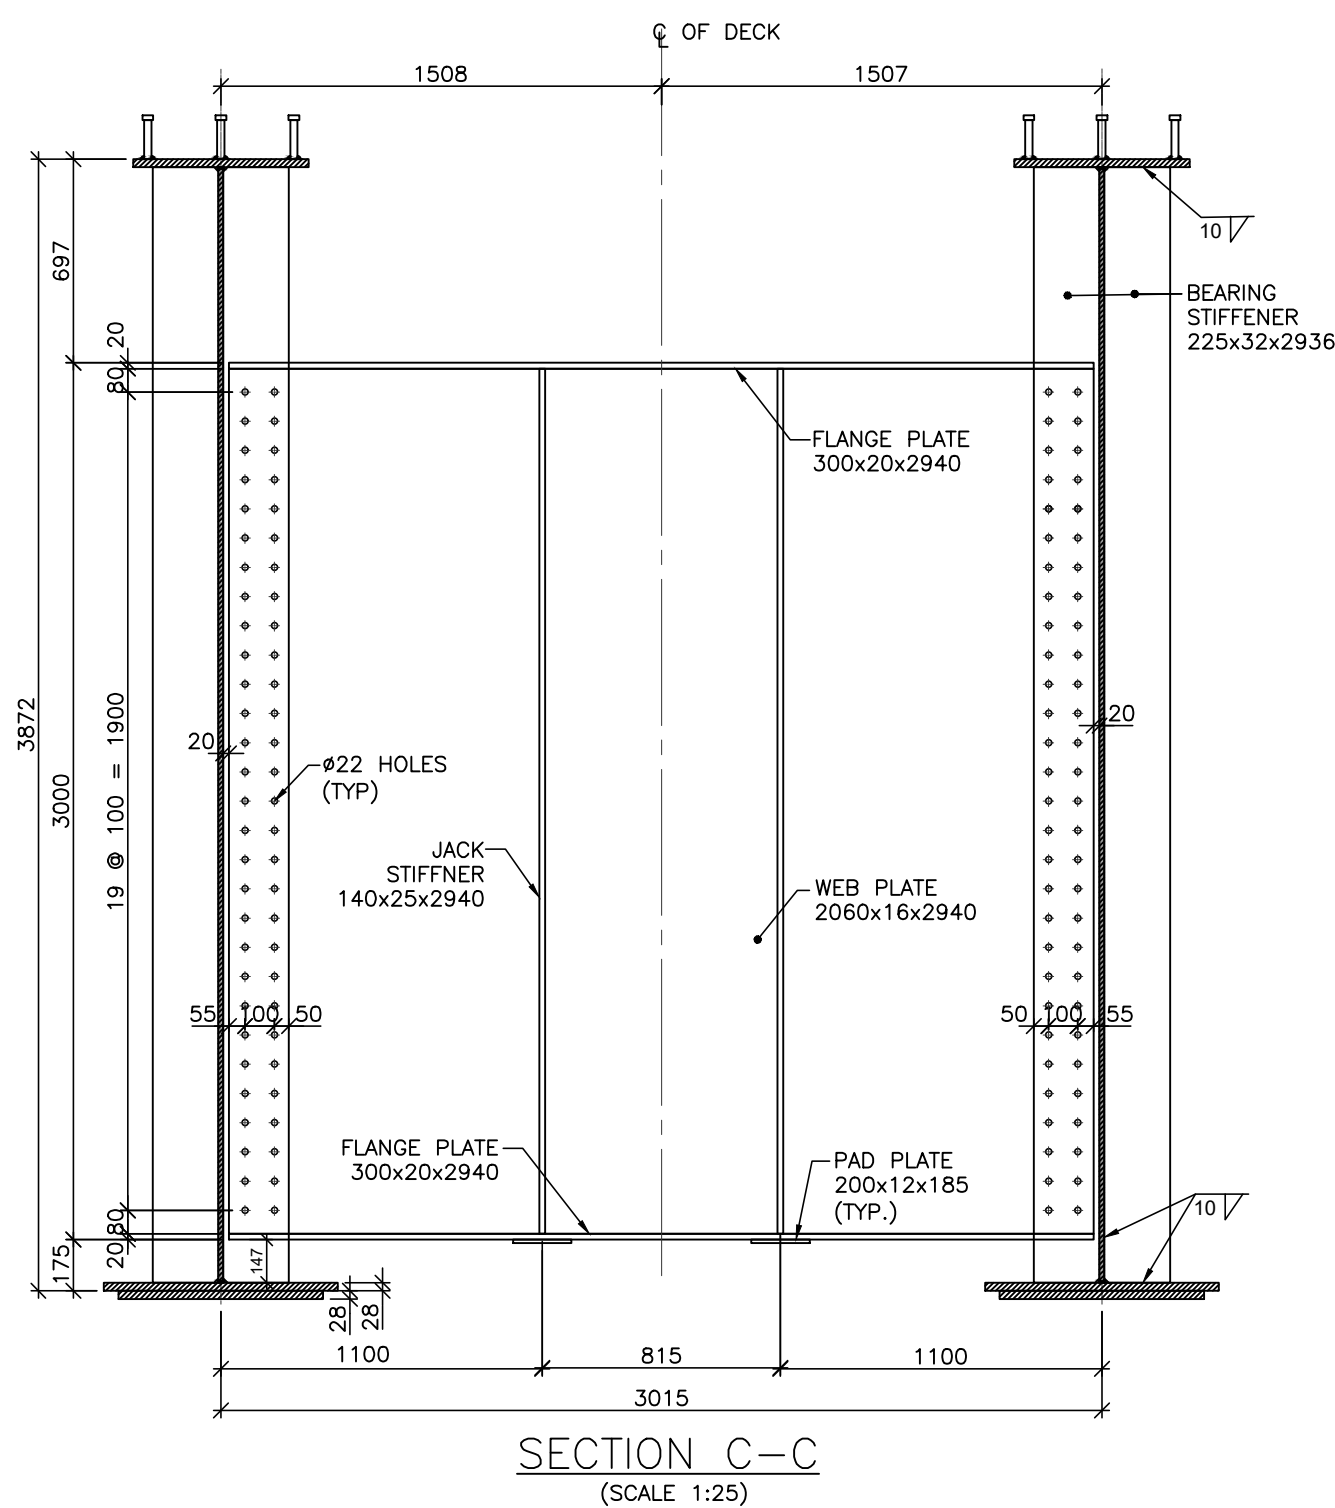

NOTES : 1. ALL DIMENSIONS ARE IN MILLIMETERS. 2. FOR SPECIAL NOTES REFER SHEET - 1.		NOTES :		LEGEND :		REFERENCE DRAWINGS : 1. O22077-BSRP-CR2-C-VD-GEN-20-2081 TO 2072 - GENERAL ARRANGEMENT DRAWING FOR VIADUCT PORTION UP LINE & DOWN LINE FROM CH 16.500KM TO 18.000KM FOR CR2 2. O22077-BSRP-CR2-C-VD-GEN-10-4262 - DIMENSION AND REINFORCEMENT DETAIL OF DECK SLAB AND PARAPET AT FOR STEEL COMPOSITE I-GIRDER (UP TRACK) FOR SPAN 46m (BETWEEN UP185 & UP186)		REFERENCE DOCUMENTS : DOC-BSRP-CR2-AG-3GN-BR-20-4593 - DESIGN CALCULATION FOR STEEL COMPOSITE I-GIRDER (UP TRACK) FOR SPAN 46m (BETWEEN UP185 & UP186)		KEY PLAN 		STATION BOX KEY PLAN 		EMPLOYER : RAIL INFRASTRUCTURE DEVELOPMENT COMPANY (KARNATAKA) LIMITED	
REVISIONS		CONTRACTOR : TRANSPORTATION INFRASTRUCTURE IC EDRC-SPECIAL BRIDGES		QUALITY ASSURANCE The responsibility of control, check and verification of accuracy, correctness, completeness, integration and full compliance of Contract provisions in respect of design analysis and drawing rests with Design & Build Contractor		GENERAL CONSULTANTS CHECKED: [Signature] NAME: [Name] SIGN: [Signature] REVIEWED: [Signature] NAME: [Name] SIGN: [Signature] PROJECT DIRECTOR: [Signature] NAME: [Name] SIGN: [Signature]		EMPLOYER : RAIL INFRASTRUCTURE DEVELOPMENT COMPANY (KARNATAKA) LIMITED		PROJECT : BENGALURU SUBURBAN RAILWAY PROJECT (BSRP) K-RIDE CORRIDOR - 2		DRAWING TITLE : DIMENSIONAL DETAILS OF STEEL COMPOSITE I-GIRDER (UP TRACK) FOR 46.0m SPAN (BETWEEN UP185 & UP186)		REVISION A D	
Detailed Design Consultant (DDC): STUP Consultants Pvt. Ltd. #10, 2nd Floor, Commercial Complex Mysore Road, Bengaluru - 560025 Tel: 080 2728 9900 Email: stupconsultants@gmail.com www.stupconsultants.com		PROOF CONSULTANT (PC): Indian Institute of Technology Madras IIT P.O., Chennai 600 036 INDIA		Contractor SIGN: [Signature] NAME: [Name] SIGN: [Signature] DATE: 26.03.2024 26.03.2024 26.03.2024 26.03.2024 NAME: ERT KAN PC SRS PREPARED BY: CHECKED BY: APPROVED BY: ISSUED BY:		GENERAL CONSULTANTS CHECKED: [Signature] NAME: [Name] SIGN: [Signature] REVIEWED: [Signature] NAME: [Name] SIGN: [Signature] PROJECT DIRECTOR: [Signature] NAME: [Name] SIGN: [Signature]		EMPLOYER : RAIL INFRASTRUCTURE DEVELOPMENT COMPANY (KARNATAKA) LIMITED		PROJECT : BENGALURU SUBURBAN RAILWAY PROJECT (BSRP) K-RIDE CORRIDOR - 2		DRAWING NO. : O22077-BSRP-CR2-C-VD-GEN-10-4261		REVISION A D	
DATE 26.03.24		FOR APPROVAL BRIEF DESCRIPTION		DATE 26.03.24		DATE 26.03.24		DATE 26.03.24		DATE 26.03.24		DATE 26.03.24		DATE 26.03.24	