



PLAN

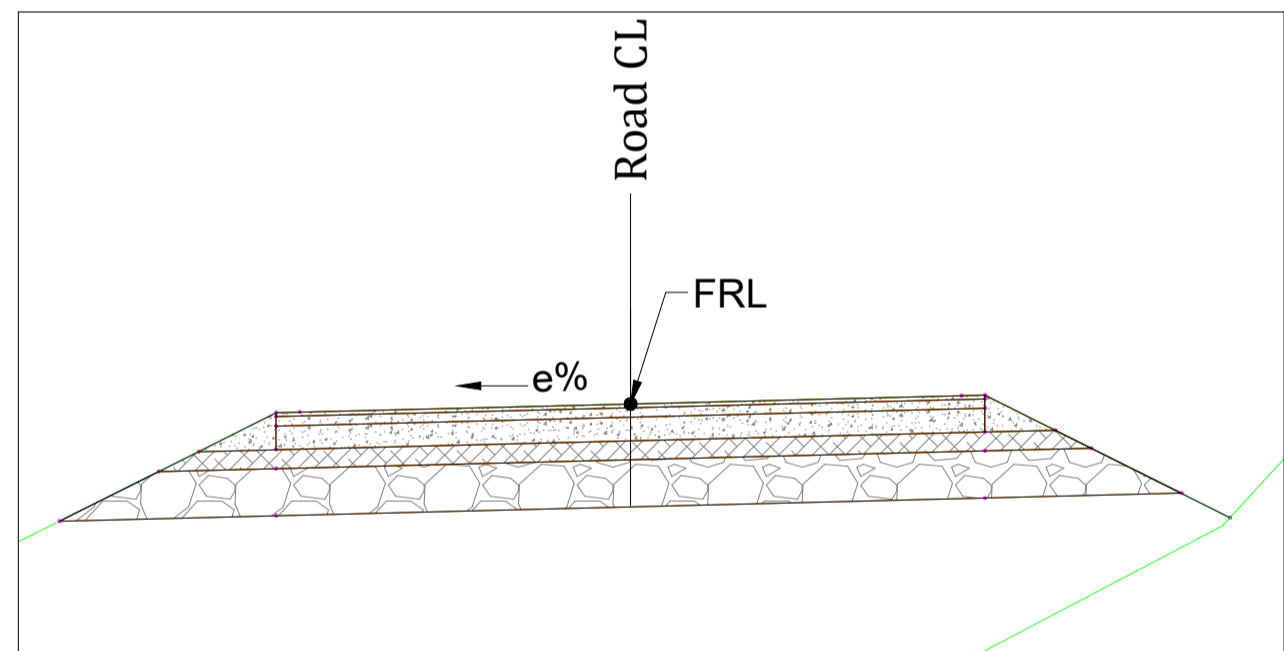


PROFILE LEGEND

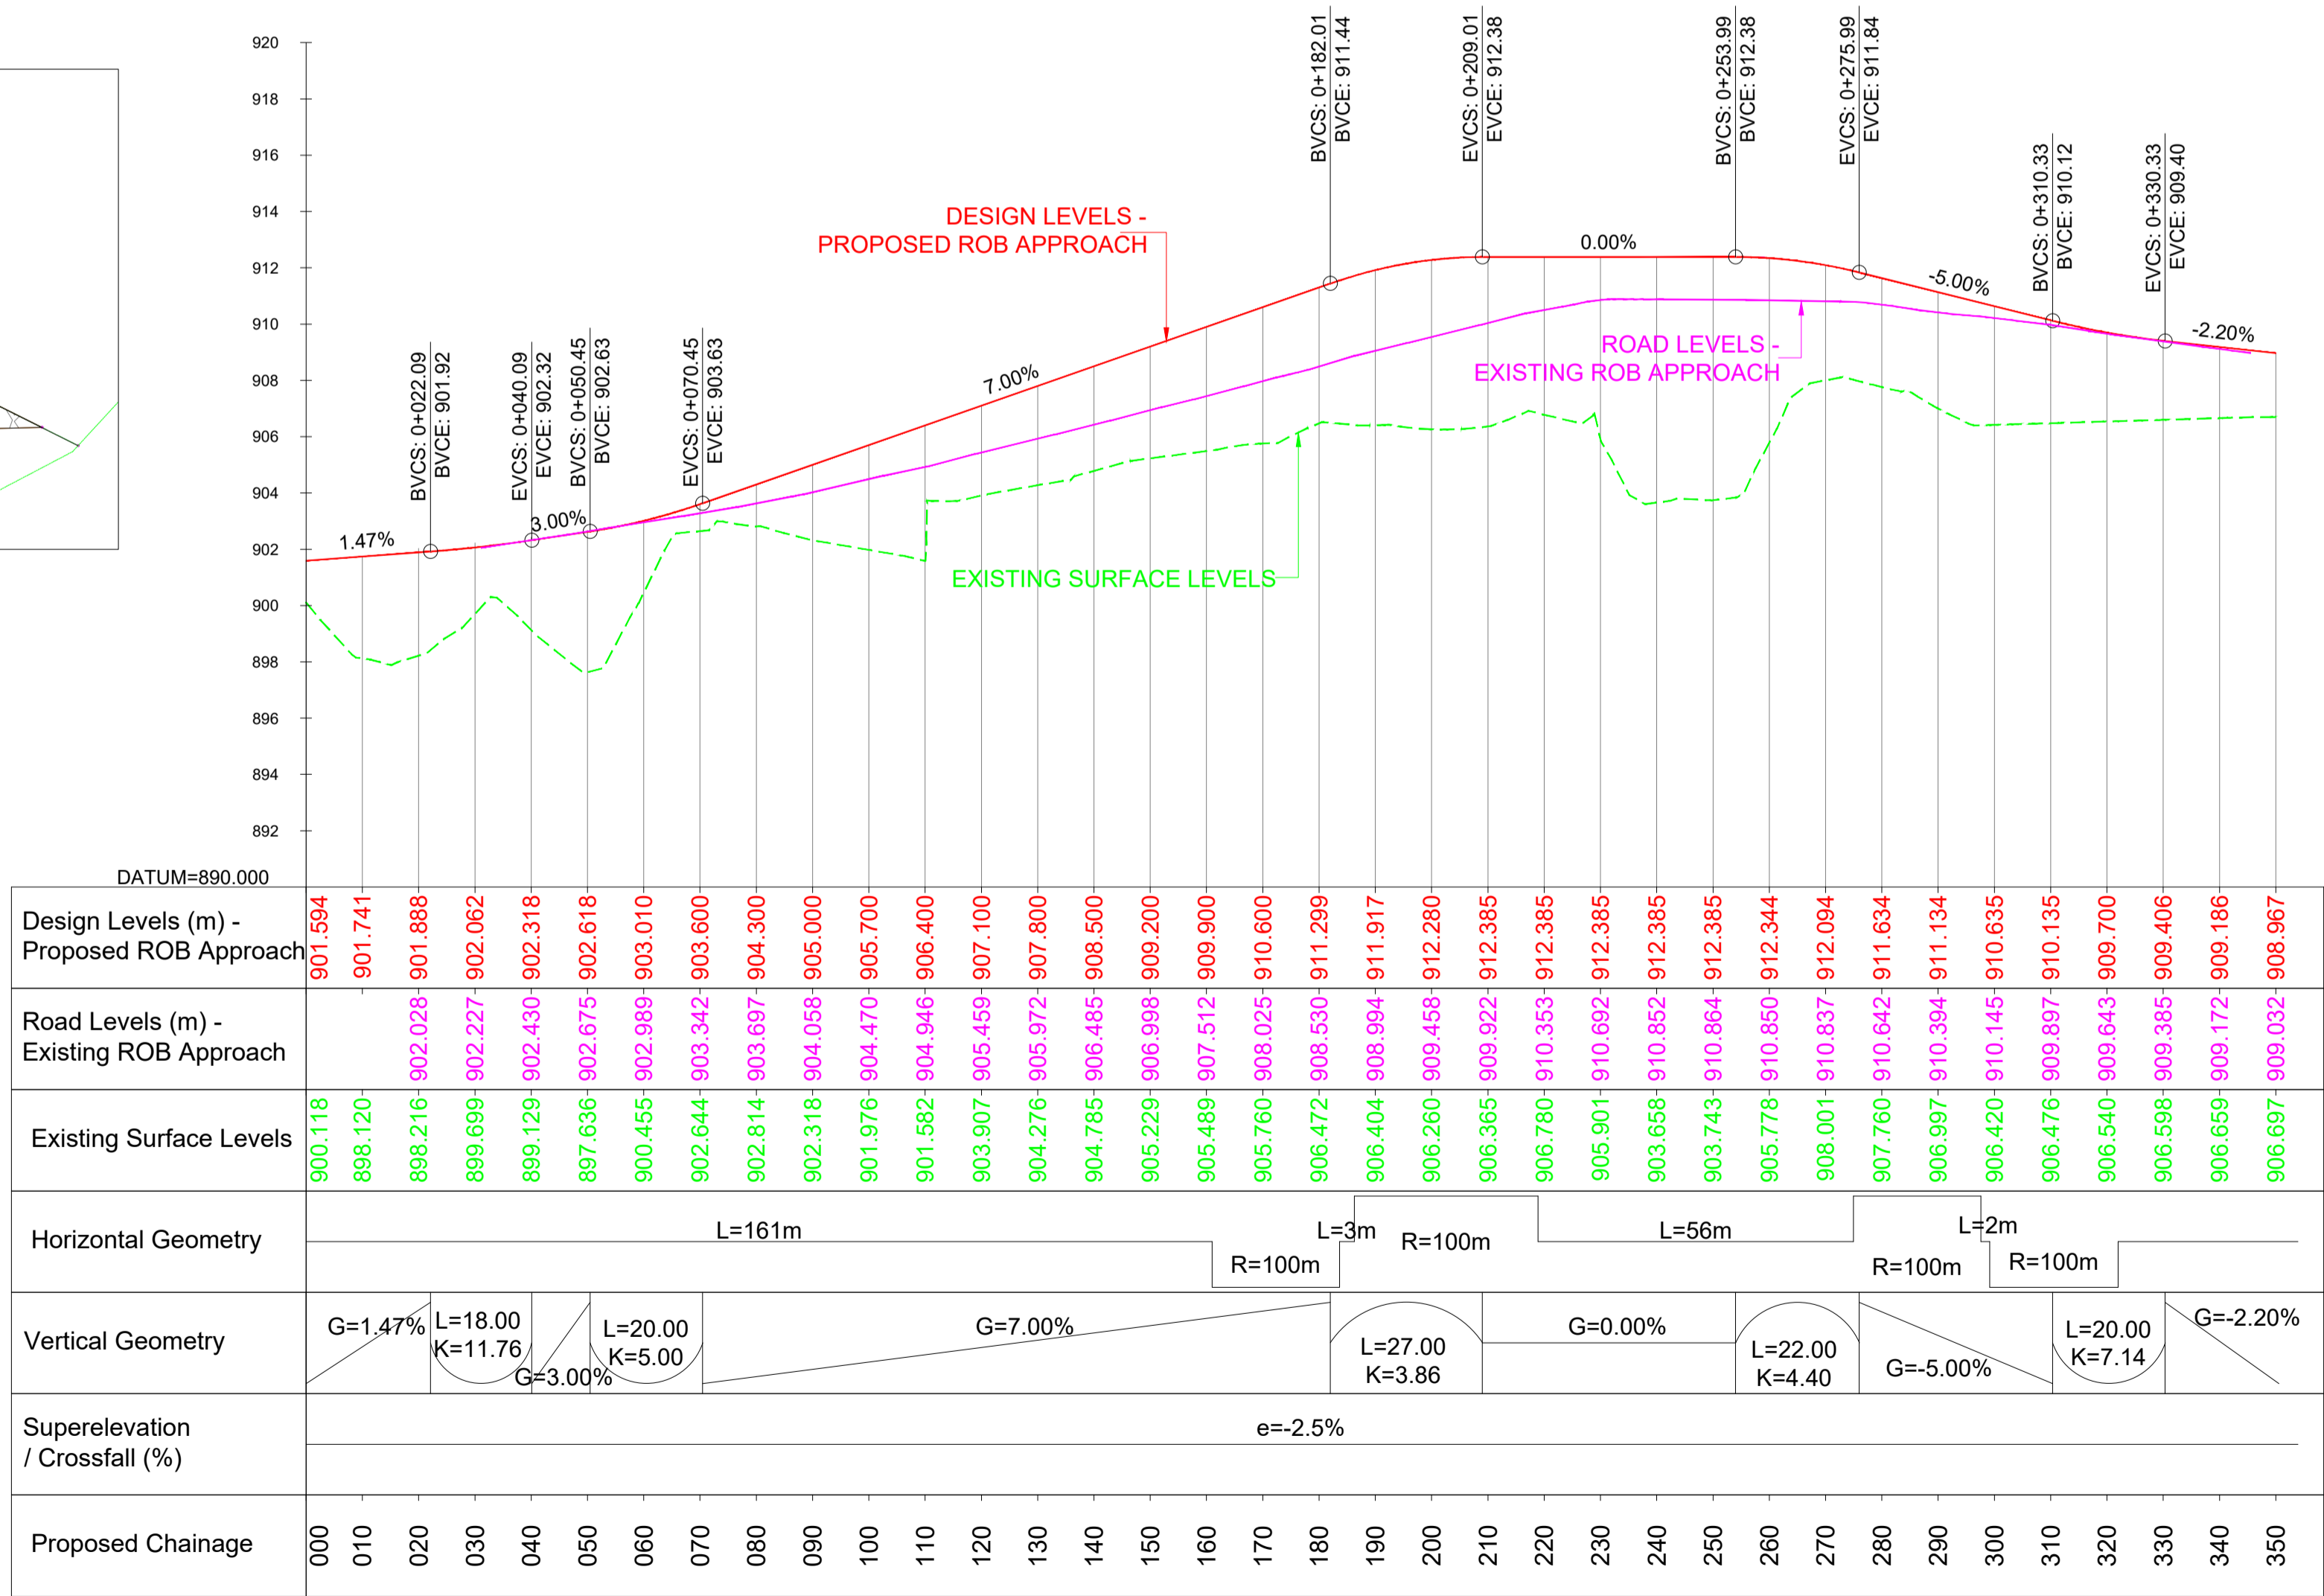

PROFILE

CHANGE OF SCOPE

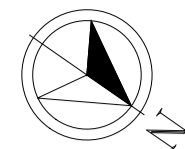

This drawing is the property of L&T Construction, Transportation Infrastructure, EDRC and must not be passed on to any person or body not authorised by us to receive it nor be copied or otherwise made use either in full or in part by such person or body without our prior permission in writing.

- NOTES-
- ALL DIMENSIONS ARE IN METER UNLESS OTHERWISE STATED.
  - ROB DECK SHALL BE AT CAMBER OF 1.5%

PROJECT : BENGALURU SUBURBAN RAILWAY PROJECT (BSRP) - CORRIDOR - 2

EMPLOYER : RAIL INFRASTRUCTURE DEVELOPMENT COMPANY (KARNATAKA) LIMITED

GENERAL CONSULTANTS : egis AECOM wsp EGIS-AECOM-WSP

CONTRACTOR : LARSEN & TOUBRO LTD. L&T CONSTRUCTION TRANSPORTATION INFRASTRUCTURE IC

DETAILED DESIGN CONSULTANT (DDC) : STUP Consultants Pvt. Ltd. - & - L&T EDRC - TRANSPORTATION INFRASTRUCTURE IC

TITLE: ALIGNMENT PLAN & PROFILE PROPOSED ROB APPROACH ROAD AT CH. 14+533 OPTION - 2

PREPARED BY	CHECKED BY	APPROVED BY
SIGNATURE		
NAME	ABHISHEK HETE	PALLAB GHOSH
DESIGNATION	ASST. MANAGER	MANAGER
DATE	17-07-2024	17-07-2024

PROJECT MANAGER (L&T)	DETAILED DESIGN CONSULTANT
SIGN	SIGN
NAME	NAME
DATE	DATE

GENERAL CONSULTANTS				
NAME	DESIGNATION	DATE	SIGN	PROJECT DIRECTOR

EMPLOYER				
SIGNATURE				
NAME				
DESIGNATION				
DATE				

REVISIONS				

B	17-07-2024	FOR APPROVAL
A	08-07-2024	FOR APPROVAL
REV	DATE	DESCRIPTION

REVISION	B	PROJECTION	RELEASED FOR
DWG STATUS	B		<input checked="" type="checkbox"/> PRELIMINARY
DATE	17-07-2024		<input type="checkbox"/> DEFINITIVE
SCALE	H-1:1000, V-1:100		<input type="checkbox"/> GOOD FOR CONSTRUCTION
SIZE	A1		<input type="checkbox"/> AS BUILT
SHEET	01 OF 01		
DRG. No.	0220777		