

H

G

F



E

D

C

B

A

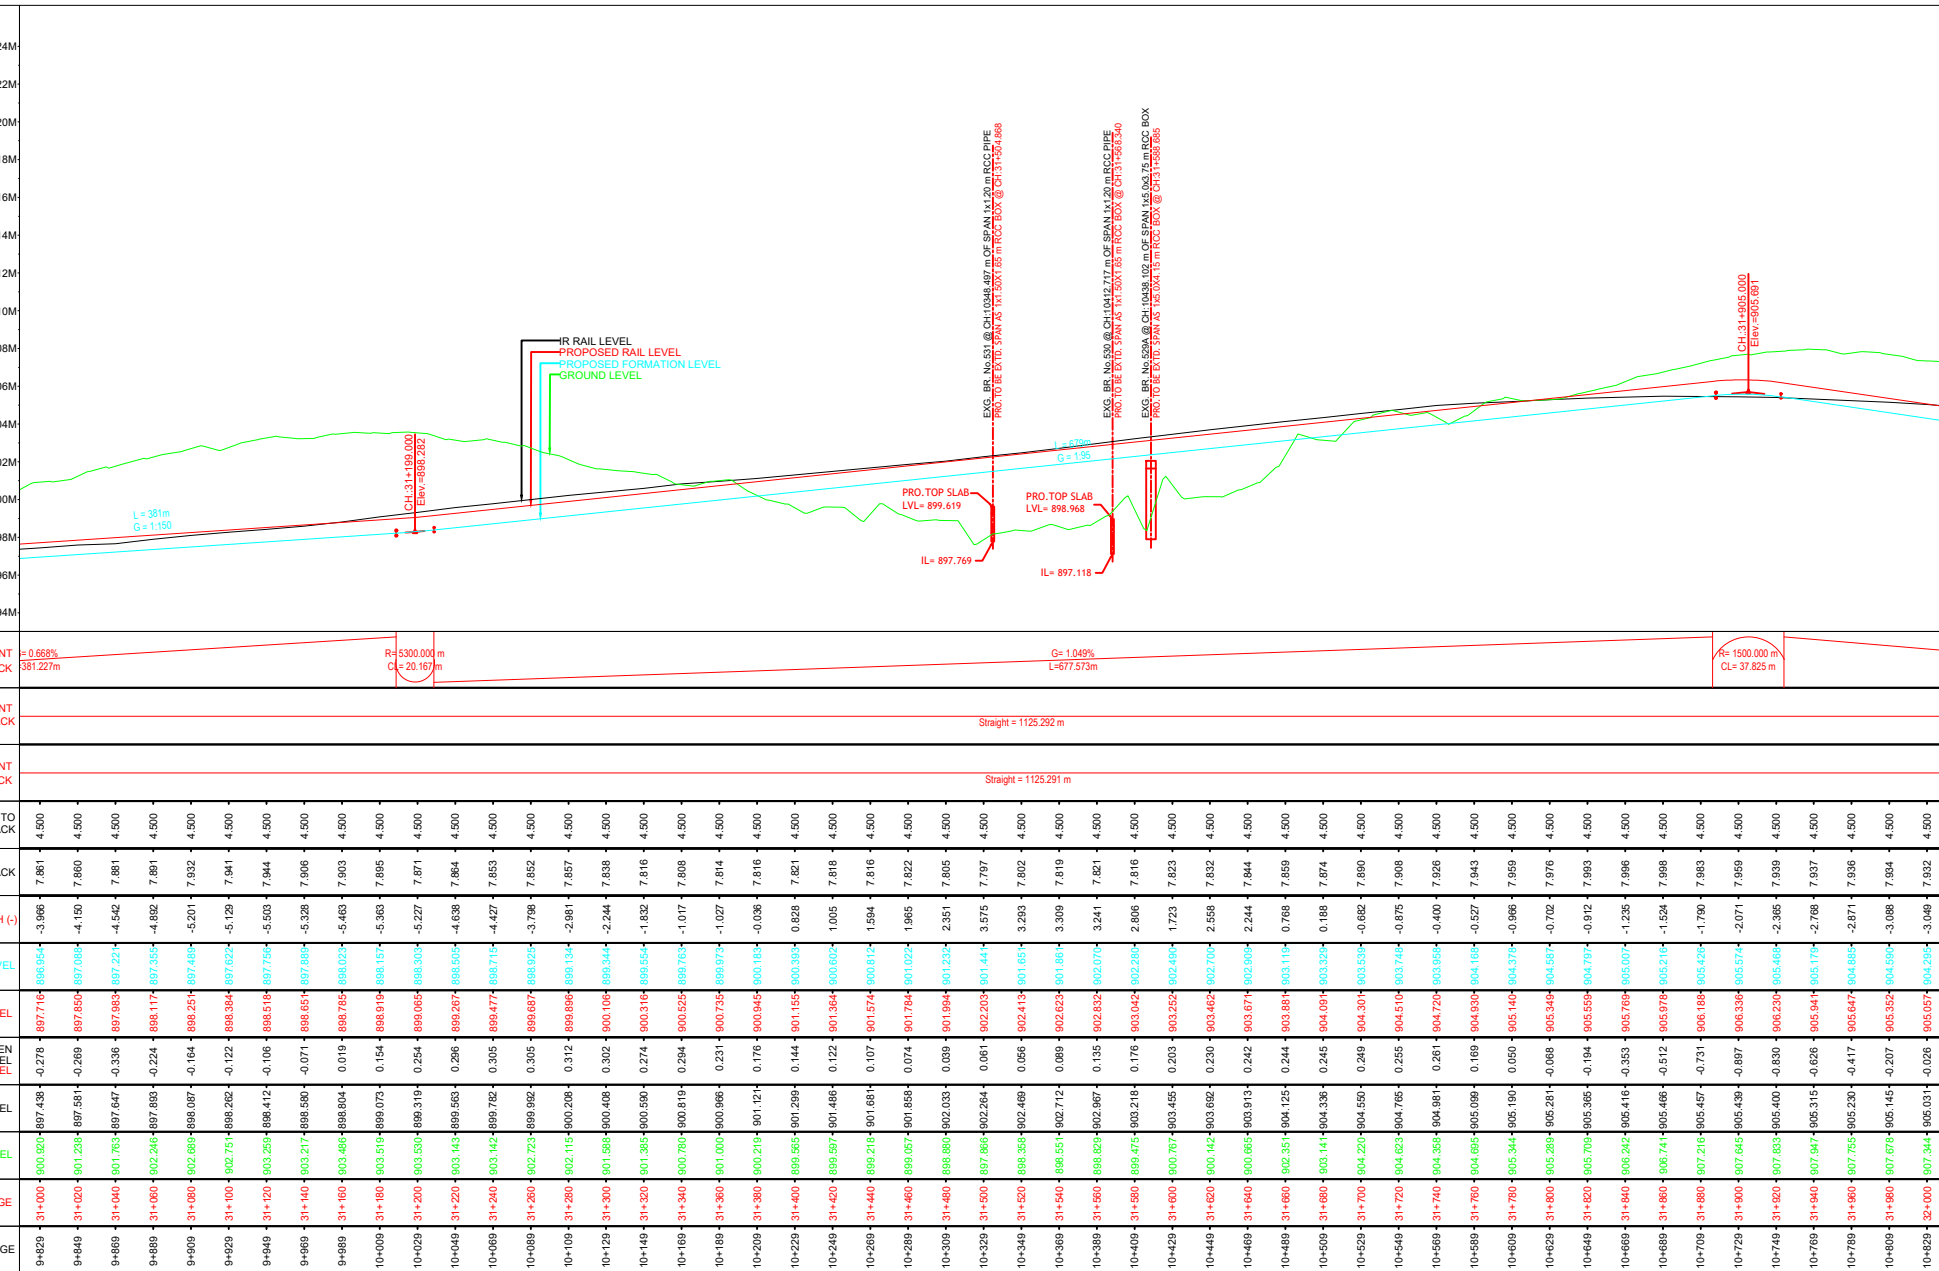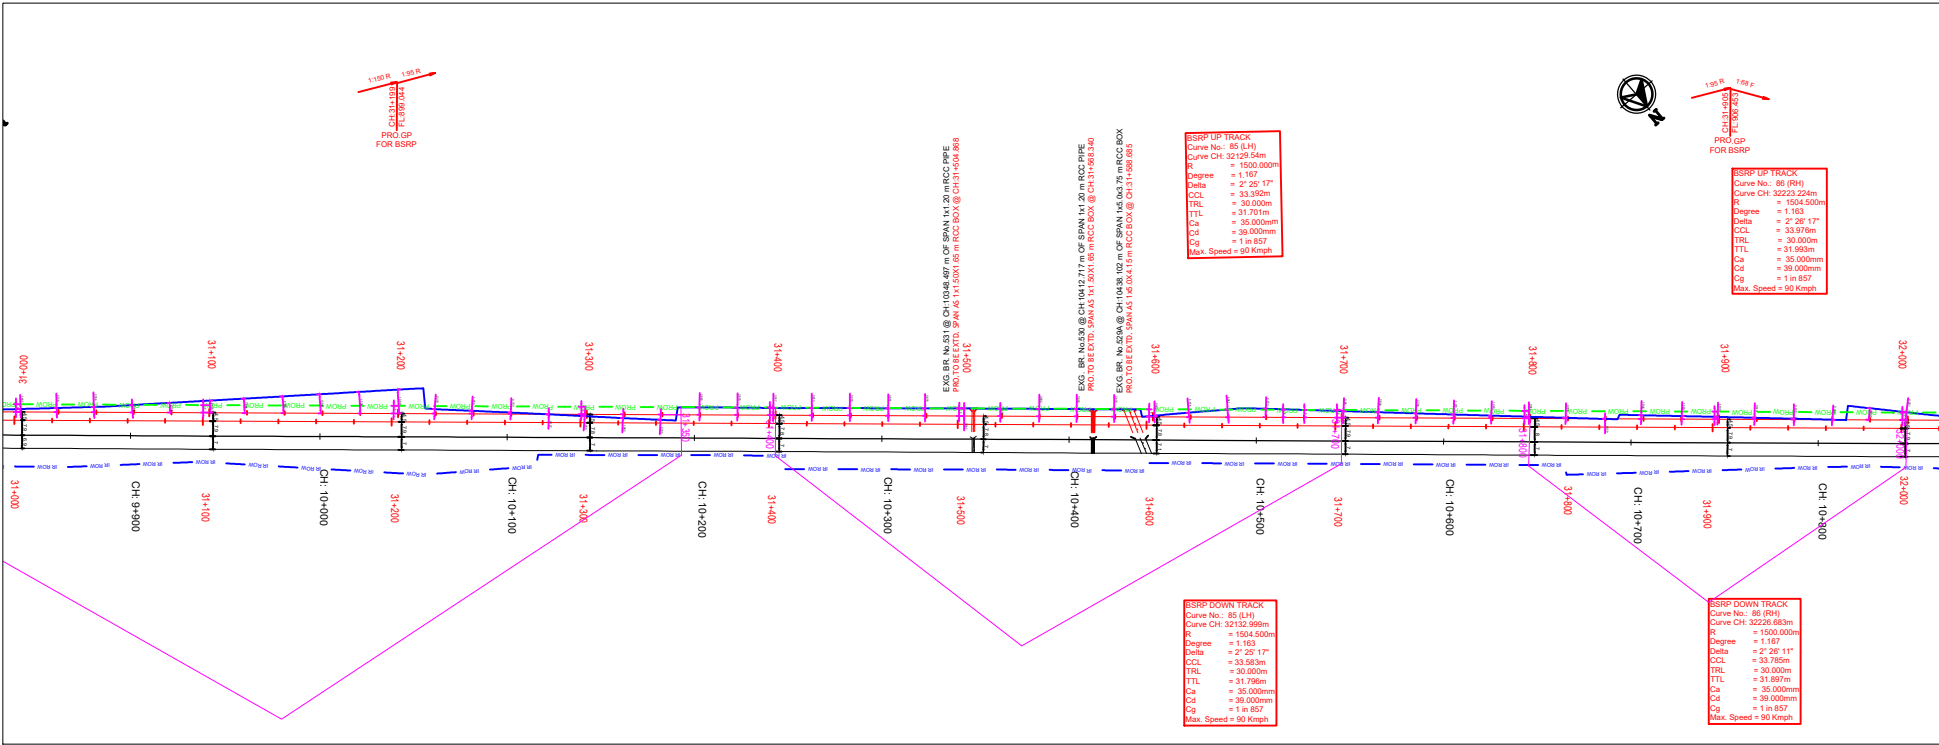

- NOTES -
1. ALL DIMENSIONS ARE IN METER UNLESS OTHERWISE STATED.
 2. DRAIN / RETAINING WALL DETAILS SHALL BE SUBMITTED SEPARATELY.
 3. SCHEDULE OF DIMENSIONS FOLLOWED AS PER BSRP.
 4. P-WAY DESIGN DETAILS ARE NOT PART OF THIS PACKAGE SCOPE.
 5. THE RUBROBRIDGES/STRUCTURE SHOWN IN THE DRAWING SHALL BE REFERRED TO RESPECTIVE GAD'S FOR DETAILS.
 6. DESIGN SLOPES SHALL BE AS PER THE APPROVED DESIGN REPORT.

LEGEND FOR PLAN:	
PROPOSED BSRP TRACK	
FUTURE BSRP WORK	
EXISTING IR TRACK	
FUTURE IR DOUBLING TRACK	
FUTURE IR QUADRUPLING TRACK	
IR SLEWING LINE	
EXISTING IR ROW AS PER ER	
PROPOSED ROW	

LEGEND FOR PROFILE:	
PROPOSED BSRP FORMATION LEVEL	
PROPOSED BSRP RAIL LEVEL	
EXISTING IR RAIL LEVEL	
GROUND LEVEL	

ALIGNMENT NOTATIONS:

R = RADIUS
COL = CIRCULAR CURVE LENGTH
TTL = TRANSITION LENGTH
TTL = TANGENT TO SPIRAL
Ca = ACTUAL CANT
Cc = CANT DEFICIENT
Cc = CANT GRADIENT

G = GRADIENT
L = GRADIENT LENGTH
TTC1 = TANGENT TO SPIRAL
TTC2 = CURVE TO SPIRAL
TTC2 = SPIRAL TO TANGENT

PROJECT :
BENGALURU SUBURBAN RAILWAY PROJECT
(BSRP) - CORRIDOR - 4

EMPLOYER :
RAIL INFRASTRUCTURE
DEVELOPMENT COMPANY
(KARNATAKA) LIMITED

GENERAL CONSULTANTS :
egis AECOM WSP
EGIS-AECOM-WSP

CONTRACTOR :

DETAILED DESIGN CONSULTANT (DDC) :

PROOF CONSULTANT (PC) :

TITLE: ALIGNMENT PLAN & PROFILE
FROM CH: 31+000 TO CH: 32+000

DESIGNED BY	CHECKED BY	APPROVED BY
SIGNATURE		
NAME		
DESIGNATION		
DATE		
PROJECT MANAGER	DETAILED DESIGN CONSULTANT	PROOF CONSULTANT
SIGN	SIGN	SIGN
NAME	NAME	NAME
DATE	DATE	DATE

GENERAL CONSULTANTS				
NAME	DESIGNATION	DATE	SIGN	PROJECT DIRECTOR
				SIGN
				NAME
				DATE

EMPLOYER

SIGNATURE		
NAME		
DESIGNATION		
DATE		

REVISIONS

0	20.07.2024	PRELIMINARY DESIGN
REV	DATE	DESCRIPTION

REVISION	0	PROJECTION	RELEASED FOR
DWG STATUS	P		<input checked="" type="checkbox"/> PRELIMINARY
DATE			<input type="checkbox"/> DEFINITIVE
SCALE	H-1:2000, V-1:200		<input type="checkbox"/> GOOD FOR CONSTRUCTION
SIZE	A1		<input type="checkbox"/> AS BUILT
SHEET			
DRG. No.	02140008	01010101	01010101

H

G

F

E

D

C

B

A