


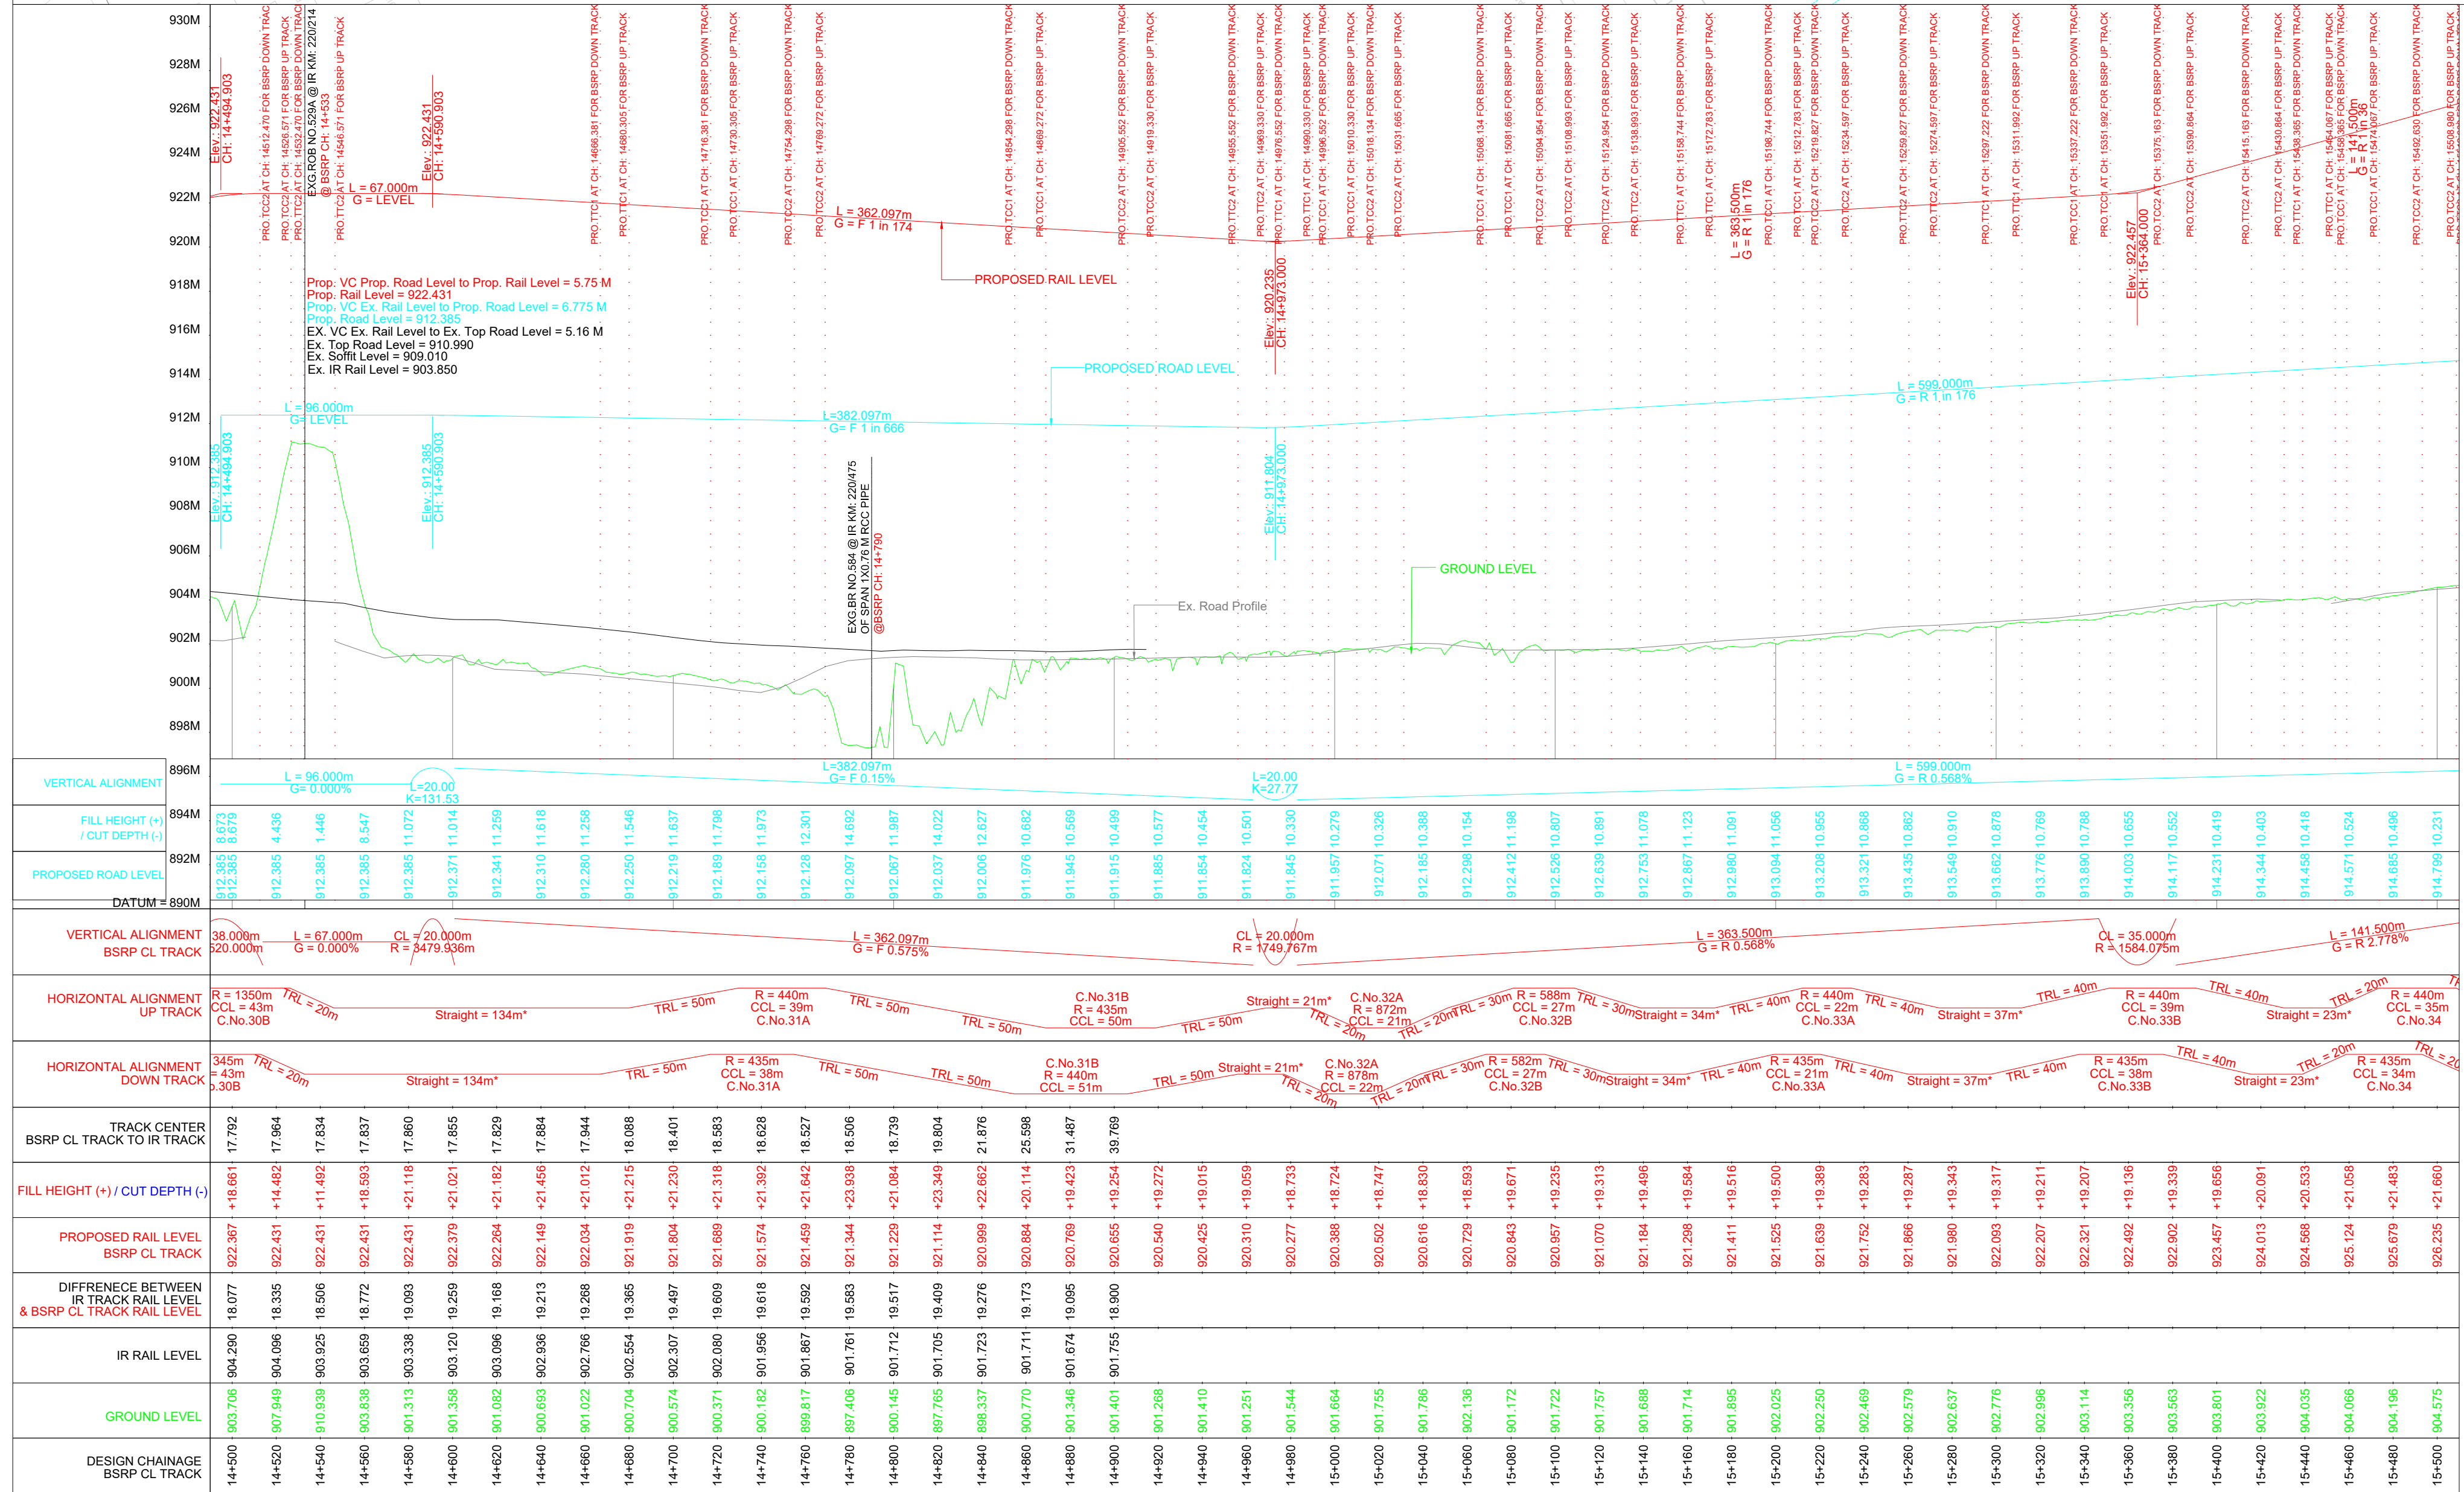

Note: Refer Road Plan & Profile along with Structure layout drawing for BBMP Double Decker Road merging with EX.ROB 529A @ BSRP CH.14+533 & IR KM.220/214 submitted vide letter no. 3078 dt.17.07.2024.



This drawing is the property of L&T Construction, Transportation Infrastructure, EDRC and not be passed on to any person or body not authorised by us to receive it nor be copied or otherwise made use either in full or in part by person or body without our prior permission in writing.

NOTES-

1. ALL DIMENSIONS ARE IN METER UNLESS OTHERWISE STATED.
2. DRAIN / RETAINING WALL DETAILS SHALL BE SUBMITTED SEPARATELY.
3. SCHEDULE OF DIMENSIONS FOLLOWED AS PER BSRP.
4. P-WAY DESIGN DETAILS ARE NOT PART OF THIS PACKAGE SCOPE.
5. THE RUB/ROB/BRIDGES/STRUCTURE SHOWN IN THE DRAWING SHALL BE REFERRED TO RESPECTIVE GAD'S FOR DETAILS.
6. DESIGN SLOPES SHALL BE AS PER THE APPROVED DESIGN REPORT.
7. IR DOUBLING SHOWN IN PLAN IS AS PER CLIENTS TENDER STAGE DRAWING AND NOT FINAL.

LEGEND FOR PLAN:

PROPOSED BSRP TRACK	
FUTURE BSRP WORK	
EXISTING IR TRACK	
FUTURE IR WORK	
EXISTING IR ROW	
PROPOSED BSRP ROW (LAQ)	

LEGEND FOR PROFILE:

PROPOSED BSRP FORMATION LEVEL	
PROPOSED BSRP RAIL LEVEL	
EXISTING IR RAIL LEVEL	
GROUND LEVEL	


ALIGNMENT NOTATIONS:

R = RADIUS	G = GRADIENT
CCL = CIRCULAR CURVE LENGTH	L = TRANSITION LENGTH
TRL = TRANSITION LENGTH	TCC1 = TANGENT TO SPIRAL
TCC1 = TANGENT TO SPIRAL	TCC2 = CURVE TO SPIRAL
Ca = ACTUAL CANT	TCC2 = CURVE TO SPIRAL
Cd = CANT DEFICIENT	TTG2 = SPIRAL TO TANGENT
Gg = CANT GRADIENT	

PROJECT:

BENGALURU SUBURBAN RAILWAY PROJECT (BSRP) - CORRIDOR - 2

EMPLOYER:

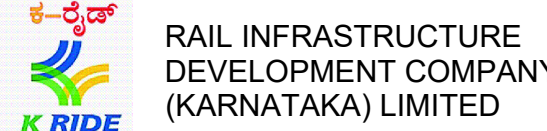


GENERAL CONSULTANTS:




CONTRACTOR:



DETAILED DESIGN CONSULTANT (DDC):

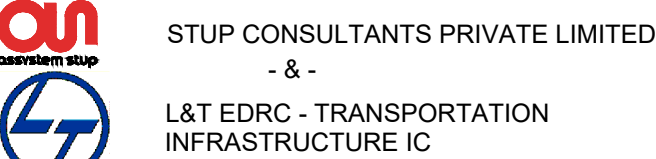

PROOF CONSULTANT (PC):

 

TITLE: ALIGNMENT PLAN & PROFILE FROM CH: 14+500 TO CH: 15+500

PREPARED BY: CHECKED BY: APPROVED BY:

SIGNATURE: AMIT DUBEY: PALLAB GHOSH: SUBRAMANIAN R.

DESIGNATION: ASST. MANAGER: MANAGER: DGM

DATE: PROJECT MANAGER (L&T): DETAILED DESIGN CONSULTANT: PROOF CONSULTANT:

SIGN: K.V. MAHADEV: SHASHIDHAR D. CHIKODI: NAME: ARVIND SALECHA

DATE: DATE: DATE:

GENERAL CONSULTANTS:

NAME: DESIGNATION: DATE: SIGN: PROJECT DIRECTOR:

SIGNATURE: NAME: DATE:

REVISIONS:

0 14.10.2024 GFC SUBMISSION FOR APPROVAL

REV DATE DESCRIPTION

REVISION DWG STATUS 0 G

DATE 14.10.2024

SCALE H-1:2000, V-1:200

SIZE A1

SHEET 16 OF 27

DRG. NO. 02 2 0 7 7 - C - R L T R - P P - 0 0 1 6

PROJECTION FIRST ANGLE

RELEASED FOR: PRELIMINARY

DEFINITIVE

GOOD FOR CONSTRUCTION

AS BUILT