
 


<u>REFERENCE DRAWINGS:-</u> (LATEST REVISION)	
Q22077--BSRP--CR2--C--VD--GEN--10--2001	GENERAL ARRANGEMENT DRAWING FOR VIADUCT PORTION FOR CH, 11+000 Km TO CH. 13+500 Km
Q22077--BSRP--CR2--C--VD--GEN--10--2002	
Q22077--BSRP--CR2--C--VD--GEN--10--2003	
Q22077--BSRP--CR2--C--VD--GEN--10--2004	
Q22077--BSRP--CR2--C--VD--GEN--10--2005	
Q22077--BSRP--CR2--C--VD--GEN--10--2006	
Q22077--C--RL--TR--PP--0013 TO 0014.....ALIGNMENT PLAN & PROFILE FROM CH: 11+200 TO CH: 13+500 (REV-D)	

LEGEND :		REFERENCE DRAWINGS :			
P : SINGLE PIER DP : DOWN LINE SINGLE PIER UP : UP LINE SINGLE PIER PP : PORTAL PIER CP : CANTILEVER PIER (PIER WITH ECCENTRIC PIER CAP)					
		QUALITY ASSURANCE			
The responsibility of control, check and verification of accuracy, correctness, completeness, integration and full compliance of Contract provisions in respect of design analysis and drawing rests with Design & Build Contractor		DDC		PC	Contractor
(PC): an Institute of chnology Madras P.O. Chennai 036 INDIA		SIGN  DATE 20/11/2024 MLR NAME SSV		 DATE 20/11/2024 PC NAME KVM	20/11/2024 KVM ISSUED BY
		PREPARED BY CHECKED BY		APPROVED BY APPROVED BY ISSUED BY	

**KEY PLAN**

JAI AHALLI STATION

YESHWANTHPUR STATION


MATHIKERE STATION

HEBBAL STATION



KANAKANAGAR STATION

BENNIGANAHALLI STATION

**EMPLOYER :**

 **RAIL INFRASTRUCTURE  
DEVELOPMENT COMPANY  
(KARNATAKA) LIMITED**

**GENERAL CONSULTANTS :**


 

**AECOM**  **egis**  **wsp** **AECOM-EGIS-WSP**





STATION BOX KEY PLAN			
<div style="border: 1px solid black; width: 100%; height: 100%;"></div>			
PROJECT : <b>BENGALURU SUBURBAN RAILWAY PROJECT (BSRP) K-RIDE CORRIDOR - 2</b>			
DRAWING TITLE : <b>GENERAL ARRANGEMENT DRAWING FOR VIADUCT PORTION FOR CH. 11+000 Km TO CH. 13+500 Km</b>			
DRAWING NO. : <b>O22077-BSRP-CR2-C-VD-GEN-10-2001</b>		REVISION :	DWG STATUS :
SCALE : <b>AS SHOWN</b>		DATE : <b>29/12/2023</b>	<div style="display: flex; justify-content: space-around; align-items: center;"> <span style="border: 1px solid black; padding: 2px 10px;">e</span> <span style="border: 1px solid black; padding: 2px 10px;">D</span> </div>
PRELIMINARY DWG (P), DEFINITIVE DWG (D), CONSTRUCTION DWG (C), AS BUILT DWG (B), SHOP DWG (S), MANUFACTURED DWG (M)			SHEET SIZE : <b>A1</b>





REFERENCE DRAWINGS:-- (LATEST REVISION)	
022077--BSRP--CR2--C--VD--GEN--10--2001	GENERAL ARRANGEMENT DRAWING FOR VIADUCT PORTION CH. 11+000 Km TO CH. 13+500 Km
022077--BSRP--CR2--C--VD--GEN--10--2002	
022077--BSRP--CR2--C--VD--GEN--10--2003.....	
022077--BSRP--CR2--C--VD--GEN--10--2004	
022077--BSRP--CR2--C--VD--GEN--10--2005	
022077--BSRP--CR2--C--VD--GEN--10--2006	
022077--C--RL--TR--PP--0013 TO 0014.....ALIGNMENT PLAN & PROFILE FROM CH: 11+200 TO CH: 13+500 (REV-D)	

PIER LINE SINGLE PIER LINE SINGLE PIER LINE PIER LEVER PIER  PIER (CAP)		REFERENCE DRAWINGS :			
QUALITY ASSURANCE					
The responsibility of control, check and verification of accuracy, correctness, completeness, integration and full compliance of Contract provisions in respect of design analysis and drawing rests with Design & Build Contractor.					
		DDC		PC	Contractor
SIGN					
DATE	20/11/2024	20/11/2024	20/11/2024		20/11/2024
NAME	MLR	SSV	PC		KVM
PREPARED BY		CHECKED BY	APPROVED BY	APPROVED BY	ISSUED BY

	<p><b>KEY PLAN</b></p> 
<p><b>EMPLOYER :</b></p>	 <p><b>RAIL INFRASTRUCTURE DEVELOPMENT COMPANY (KARNATAKA) LIMITED</b></p>
<p><b>GENERAL CONSULTANTS :</b></p>	 <p><b>AECOM egis wsp AECOM-EGIS-WS</b></p>


PROJECT : <span style="color: red; font-weight: bold;">BENGALURU SUBURBAN RAILWAY PROJECT (BSRP)</span> <span style="color: red; font-weight: bold;">K-RIDE CORRIDOR - 2</span>					
DRAWING TITLE : <span style="color: blue; font-weight: bold;">GENERAL ARRANGEMENT DRAWING FOR VIADUCT PORTION</span> <span style="color: blue; font-weight: bold;">FOR CH. 11+000 Km TO CH. 13+500 Km</span>					
DRAWING NO. : <span style="color: blue; font-weight: bold;">O220777-BSRP-CR2-C-VD-GEN-10-2002</span>	<table border="1" style="width: 100%; border-collapse: collapse;"> <tr> <td style="padding: 2px;">REVISION</td> <td style="padding: 2px;">DWG STATUS</td> </tr> <tr> <td style="text-align: center; padding: 5px;"><span style="font-size: 1.5em;">e</span></td> <td style="text-align: center; padding: 5px;"><span style="font-size: 1.5em;">D</span></td> </tr> </table>	REVISION	DWG STATUS	<span style="font-size: 1.5em;">e</span>	<span style="font-size: 1.5em;">D</span>
REVISION	DWG STATUS				
<span style="font-size: 1.5em;">e</span>	<span style="font-size: 1.5em;">D</span>				
<table border="1" style="width: 100%; border-collapse: collapse;"> <tr> <td style="width: 50%; padding: 2px;">SCALE : AS SHOWN</td> <td style="width: 50%; padding: 2px;">DATE : 29/12/2023</td> </tr> </table>		SCALE : AS SHOWN	DATE : 29/12/2023		
SCALE : AS SHOWN	DATE : 29/12/2023				
PRELIMINARY DWG (P), DEFINITIVE DWG (D), CONSTRUCTION DWG (C), AS BUILT DWG (B), SHOP DWG (S), MANUFACTURED DWG (M)					
SHEET SIZE : A1					








← TO BENNIGANAHALLI STATION      TO HEBBAL STATION →

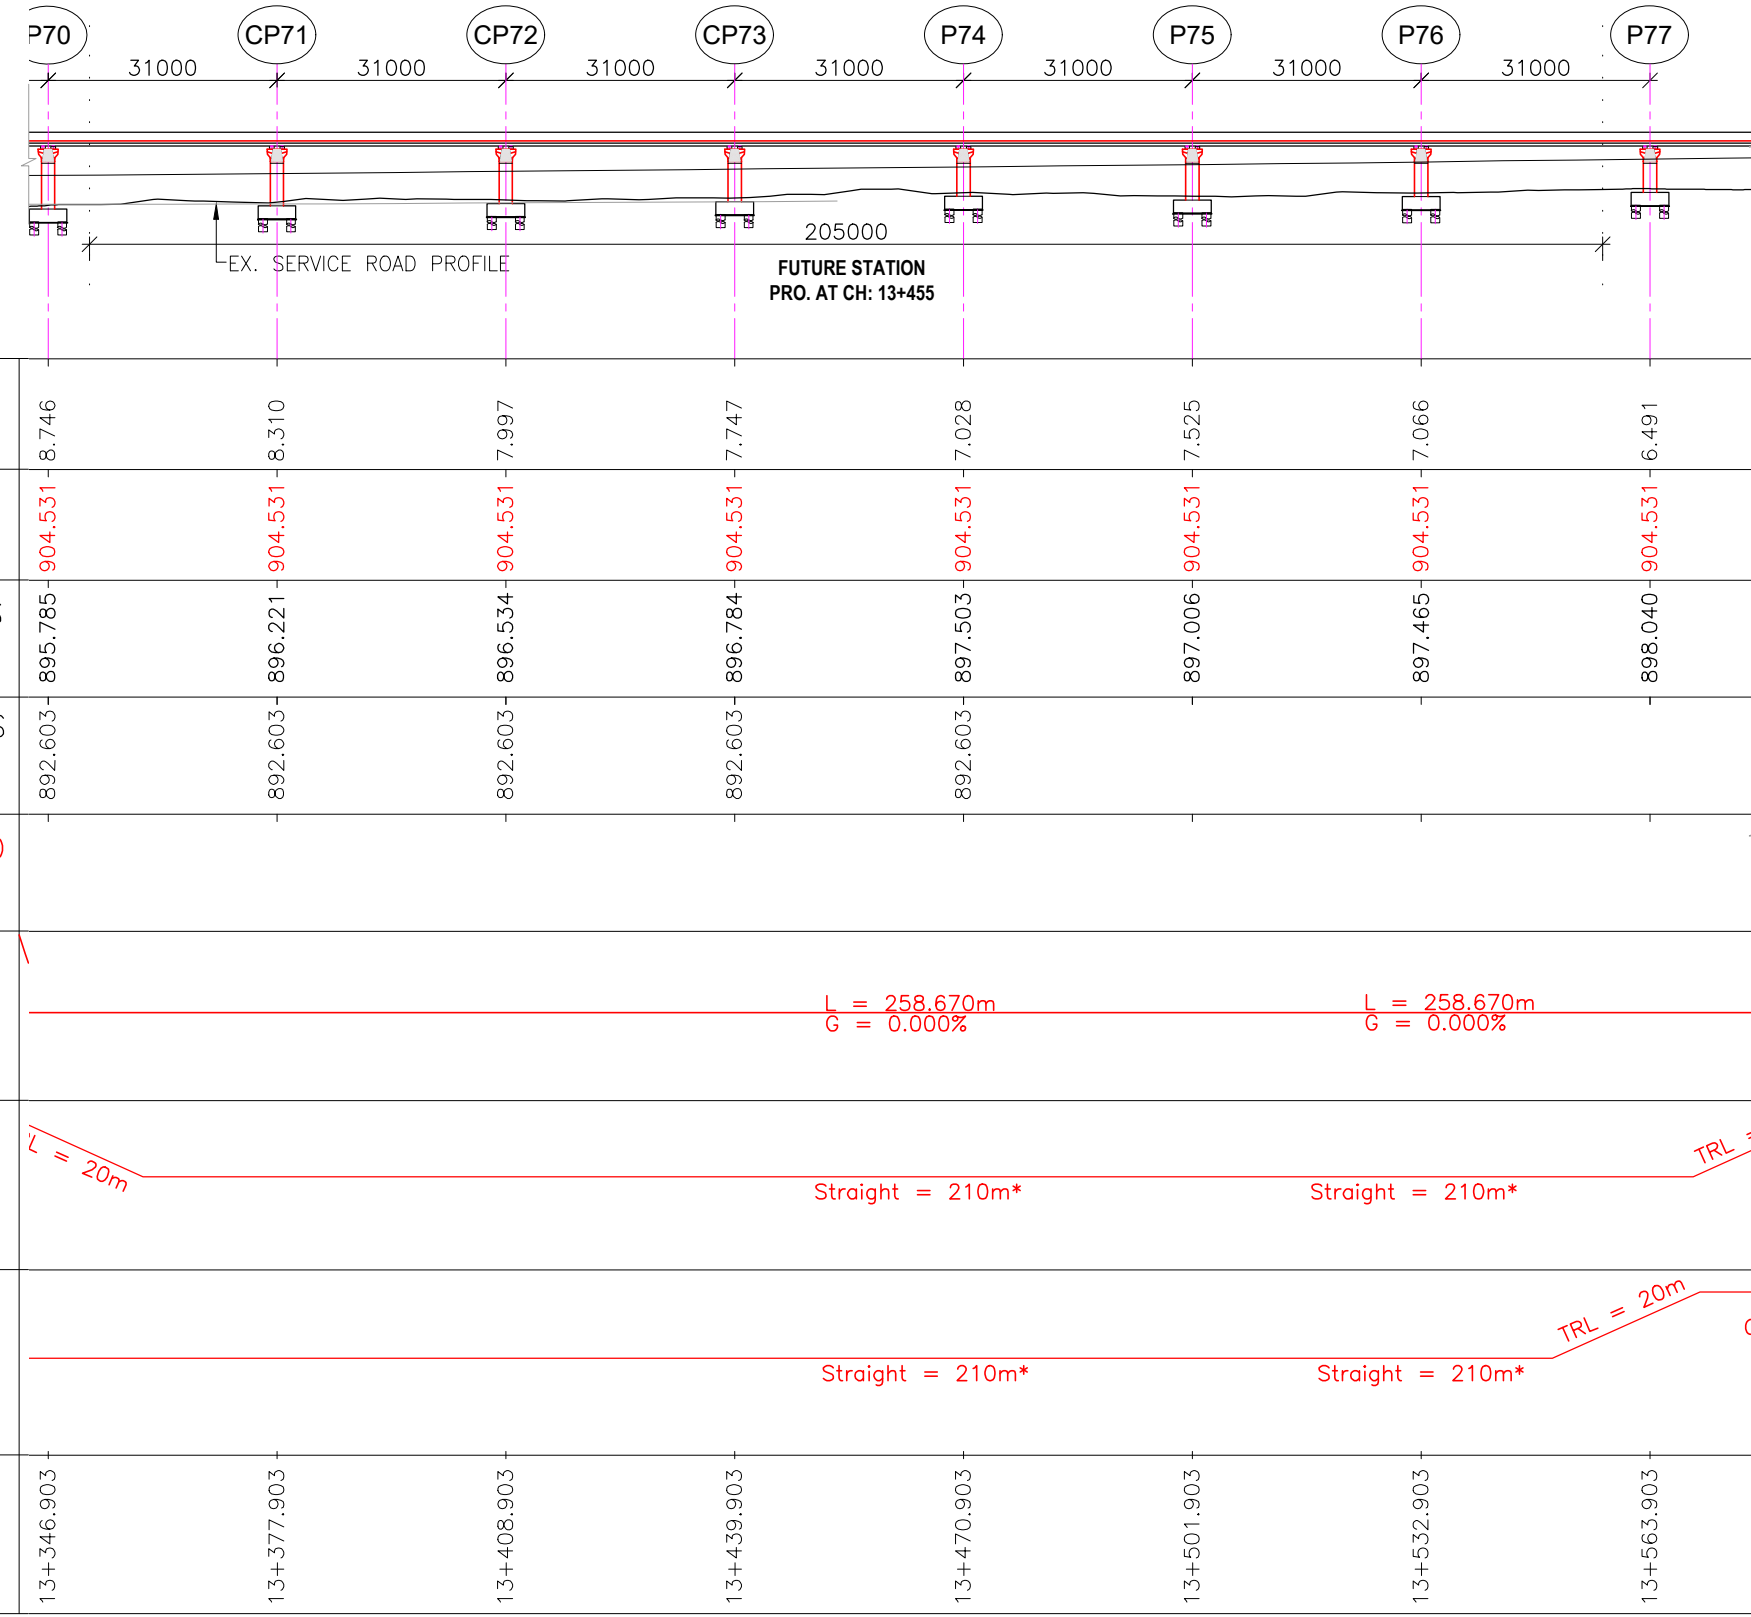

LONGITUDINAL ELEVATION  
(SCALE 1:1000)

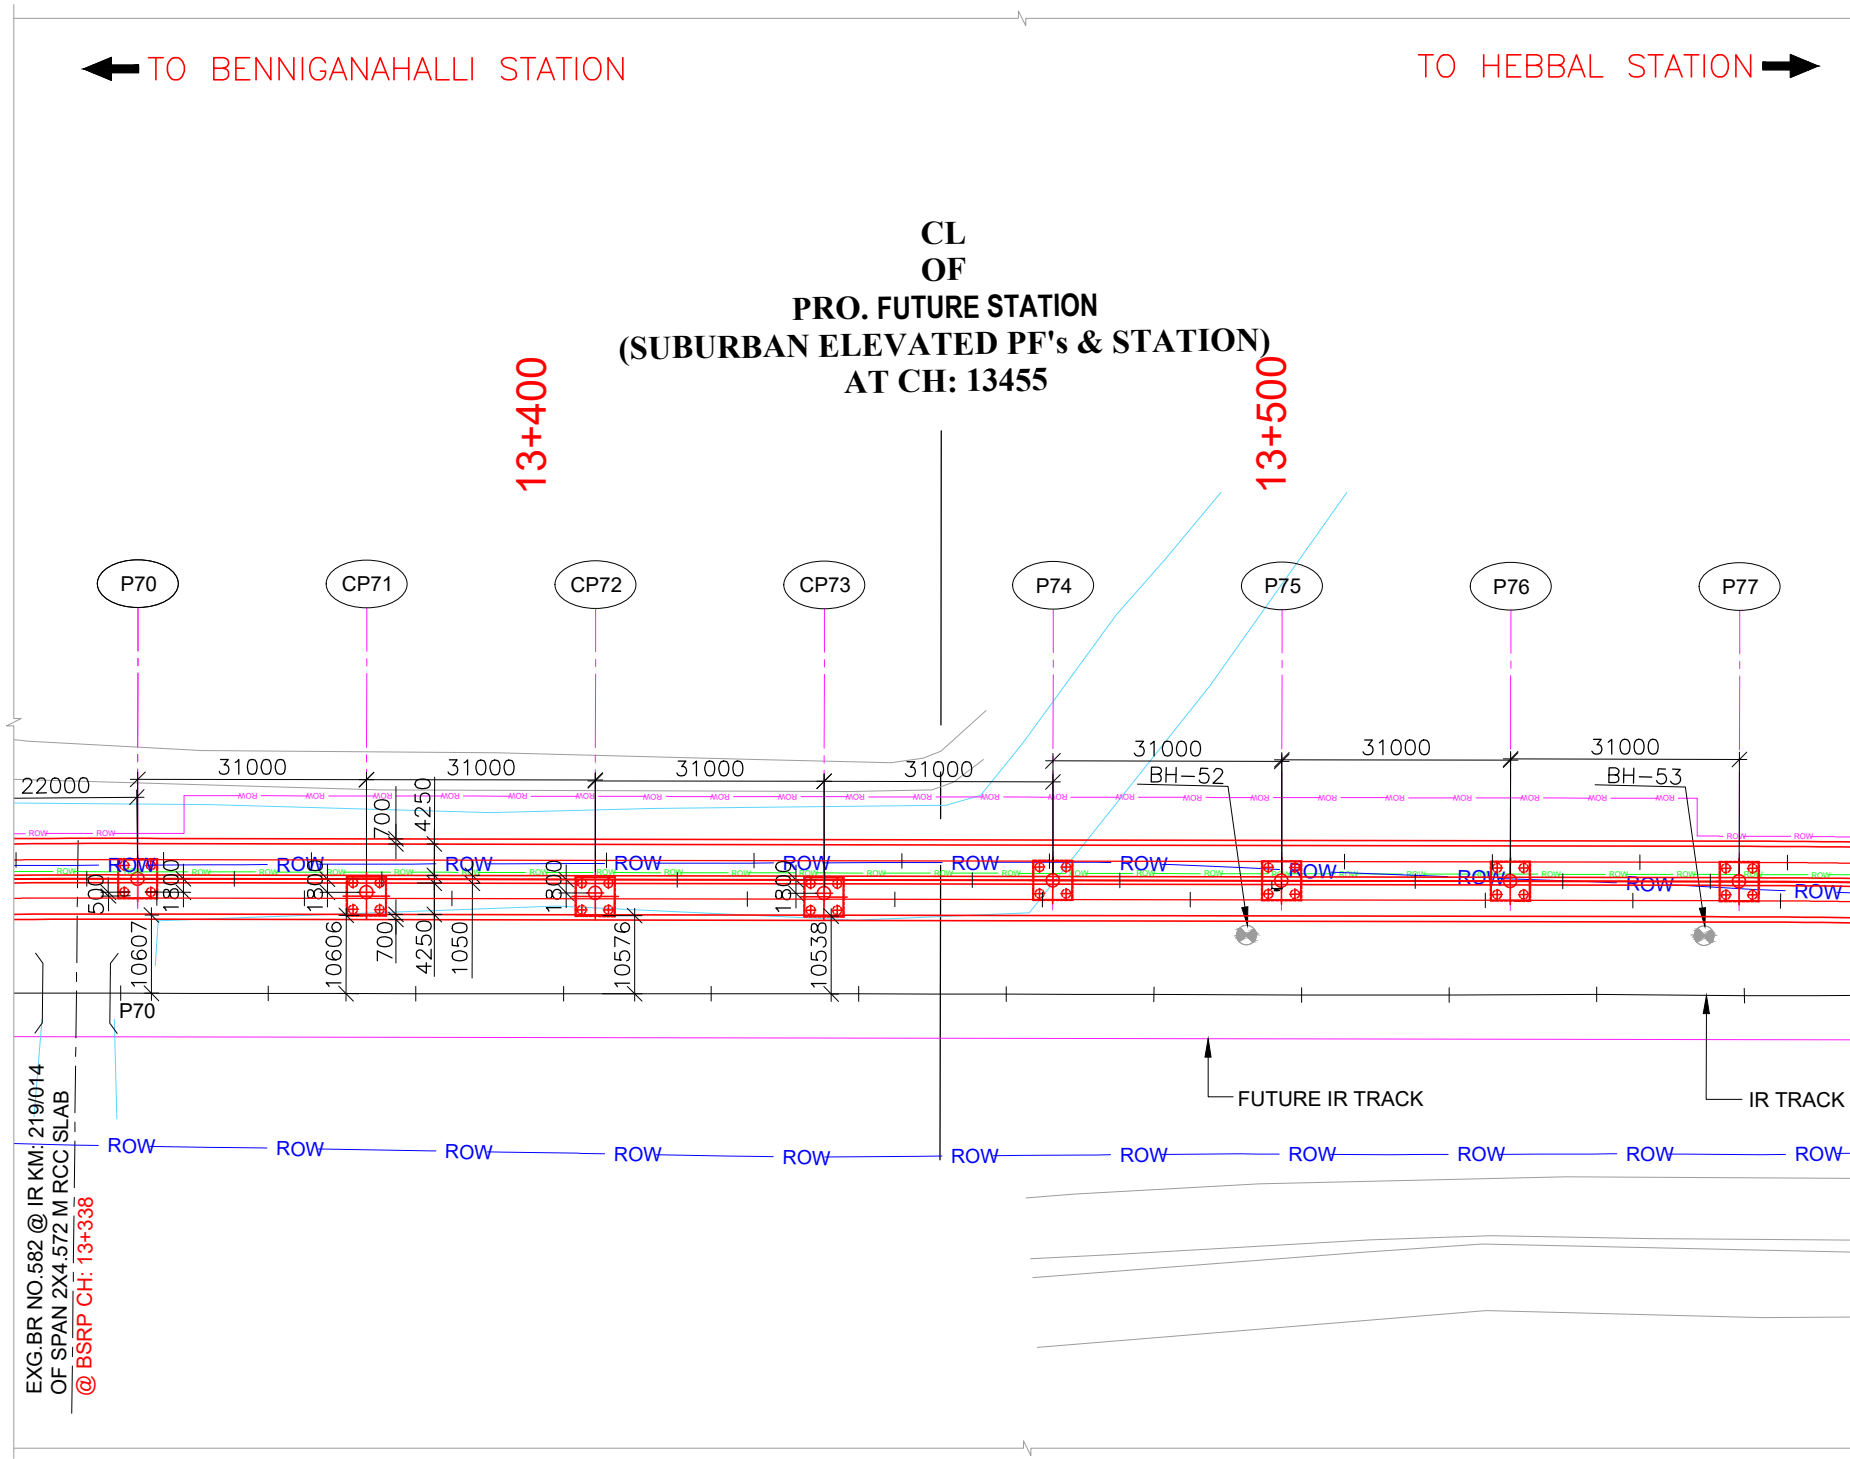

PLAN  
(SCALE 1:1000)

LEGEND FOR PLAN	
PROPOSED BSRP TRACK	
EXISTING IR TRACK	
FUTURE IR WORK	
EXISTING ROW AS PER ER	
PROPOSED ROW AS PER ER	
PROPOSED ROW AS PER IR	
EXISTING SERVICE ROAD	
PROPOSED ROAD	
LEGEND FOR PROFILE	
PROPOSED BSRP RAIL LEVEL	
EXISTING IR RAIL LEVEL	
GROUND LEVEL	
PROPOSED BSRP VERTICAL ALIGNMENT	

REFERENCE DRAWINGS:- (LATEST REVISION)

022077-BSRP-CR2-C-VD-GEN-10-2001 GENERAL ARRANGEMENT  
022077-BSRP-CR2-C-VD-GEN-10-2002 DRAWING FOR VIADUCT PORTION  
022077-BSRP-CR2-C-VD-GEN-10-2004 FOR CH. 11+000 Km TO CH. 13+500 Km  
022077-BSRP-CR2-C-VD-GEN-10-2005  
022077-BSRP-CR2-C-VD-GEN-10-2006


022077-C-RL-TR-PP-0013 TO 0014.....ALIGNMENT PLAN & PROFILE FROM CH: 11+200 TO CH: 13+500 (REV-D)

- NOTES:
- ALL DIMENSIONS AND LEVELS ARE IN METER, UNLESS OTHERWISE SPECIFIED.
  - DIMENSIONS ARE NOT TO BE SCALED. ONLY WRITTEN DIMENSIONS SHALL BE FOLLOWED.
  - ALL SUPERSTRUCTURE ARE PRECAST PRETENSIONED U-GIRDER UNLESS OTHERWISE MENTIONED.
  - CHAINAGES MENTIONED ARE AT THE CENTER LINE OF ALIGNMENT.

REVISIONS	
REV	DATE
a	20/12/2023
b	20/12/2024
c	20/12/2024
d	20/12/2024
e	20/12/2024

CONTRACTOR:	TRANSPORTATION INFRASTRUCTURE IC EDRC-SPECIAL BRIDGES
DETAILED DESIGN CONSULTANT (DDC):	STUP Consultants Pvt. Ltd. PLOT NO. 10, 11, 12, 999, 1000

CONTRACTOR:	TRANSPORTATION INFRASTRUCTURE IC EDRC-SPECIAL BRIDGES
DETAILED DESIGN CONSULTANT (DDC):	STUP Consultants Pvt. Ltd. PLOT NO. 10, 11, 12, 893, 894

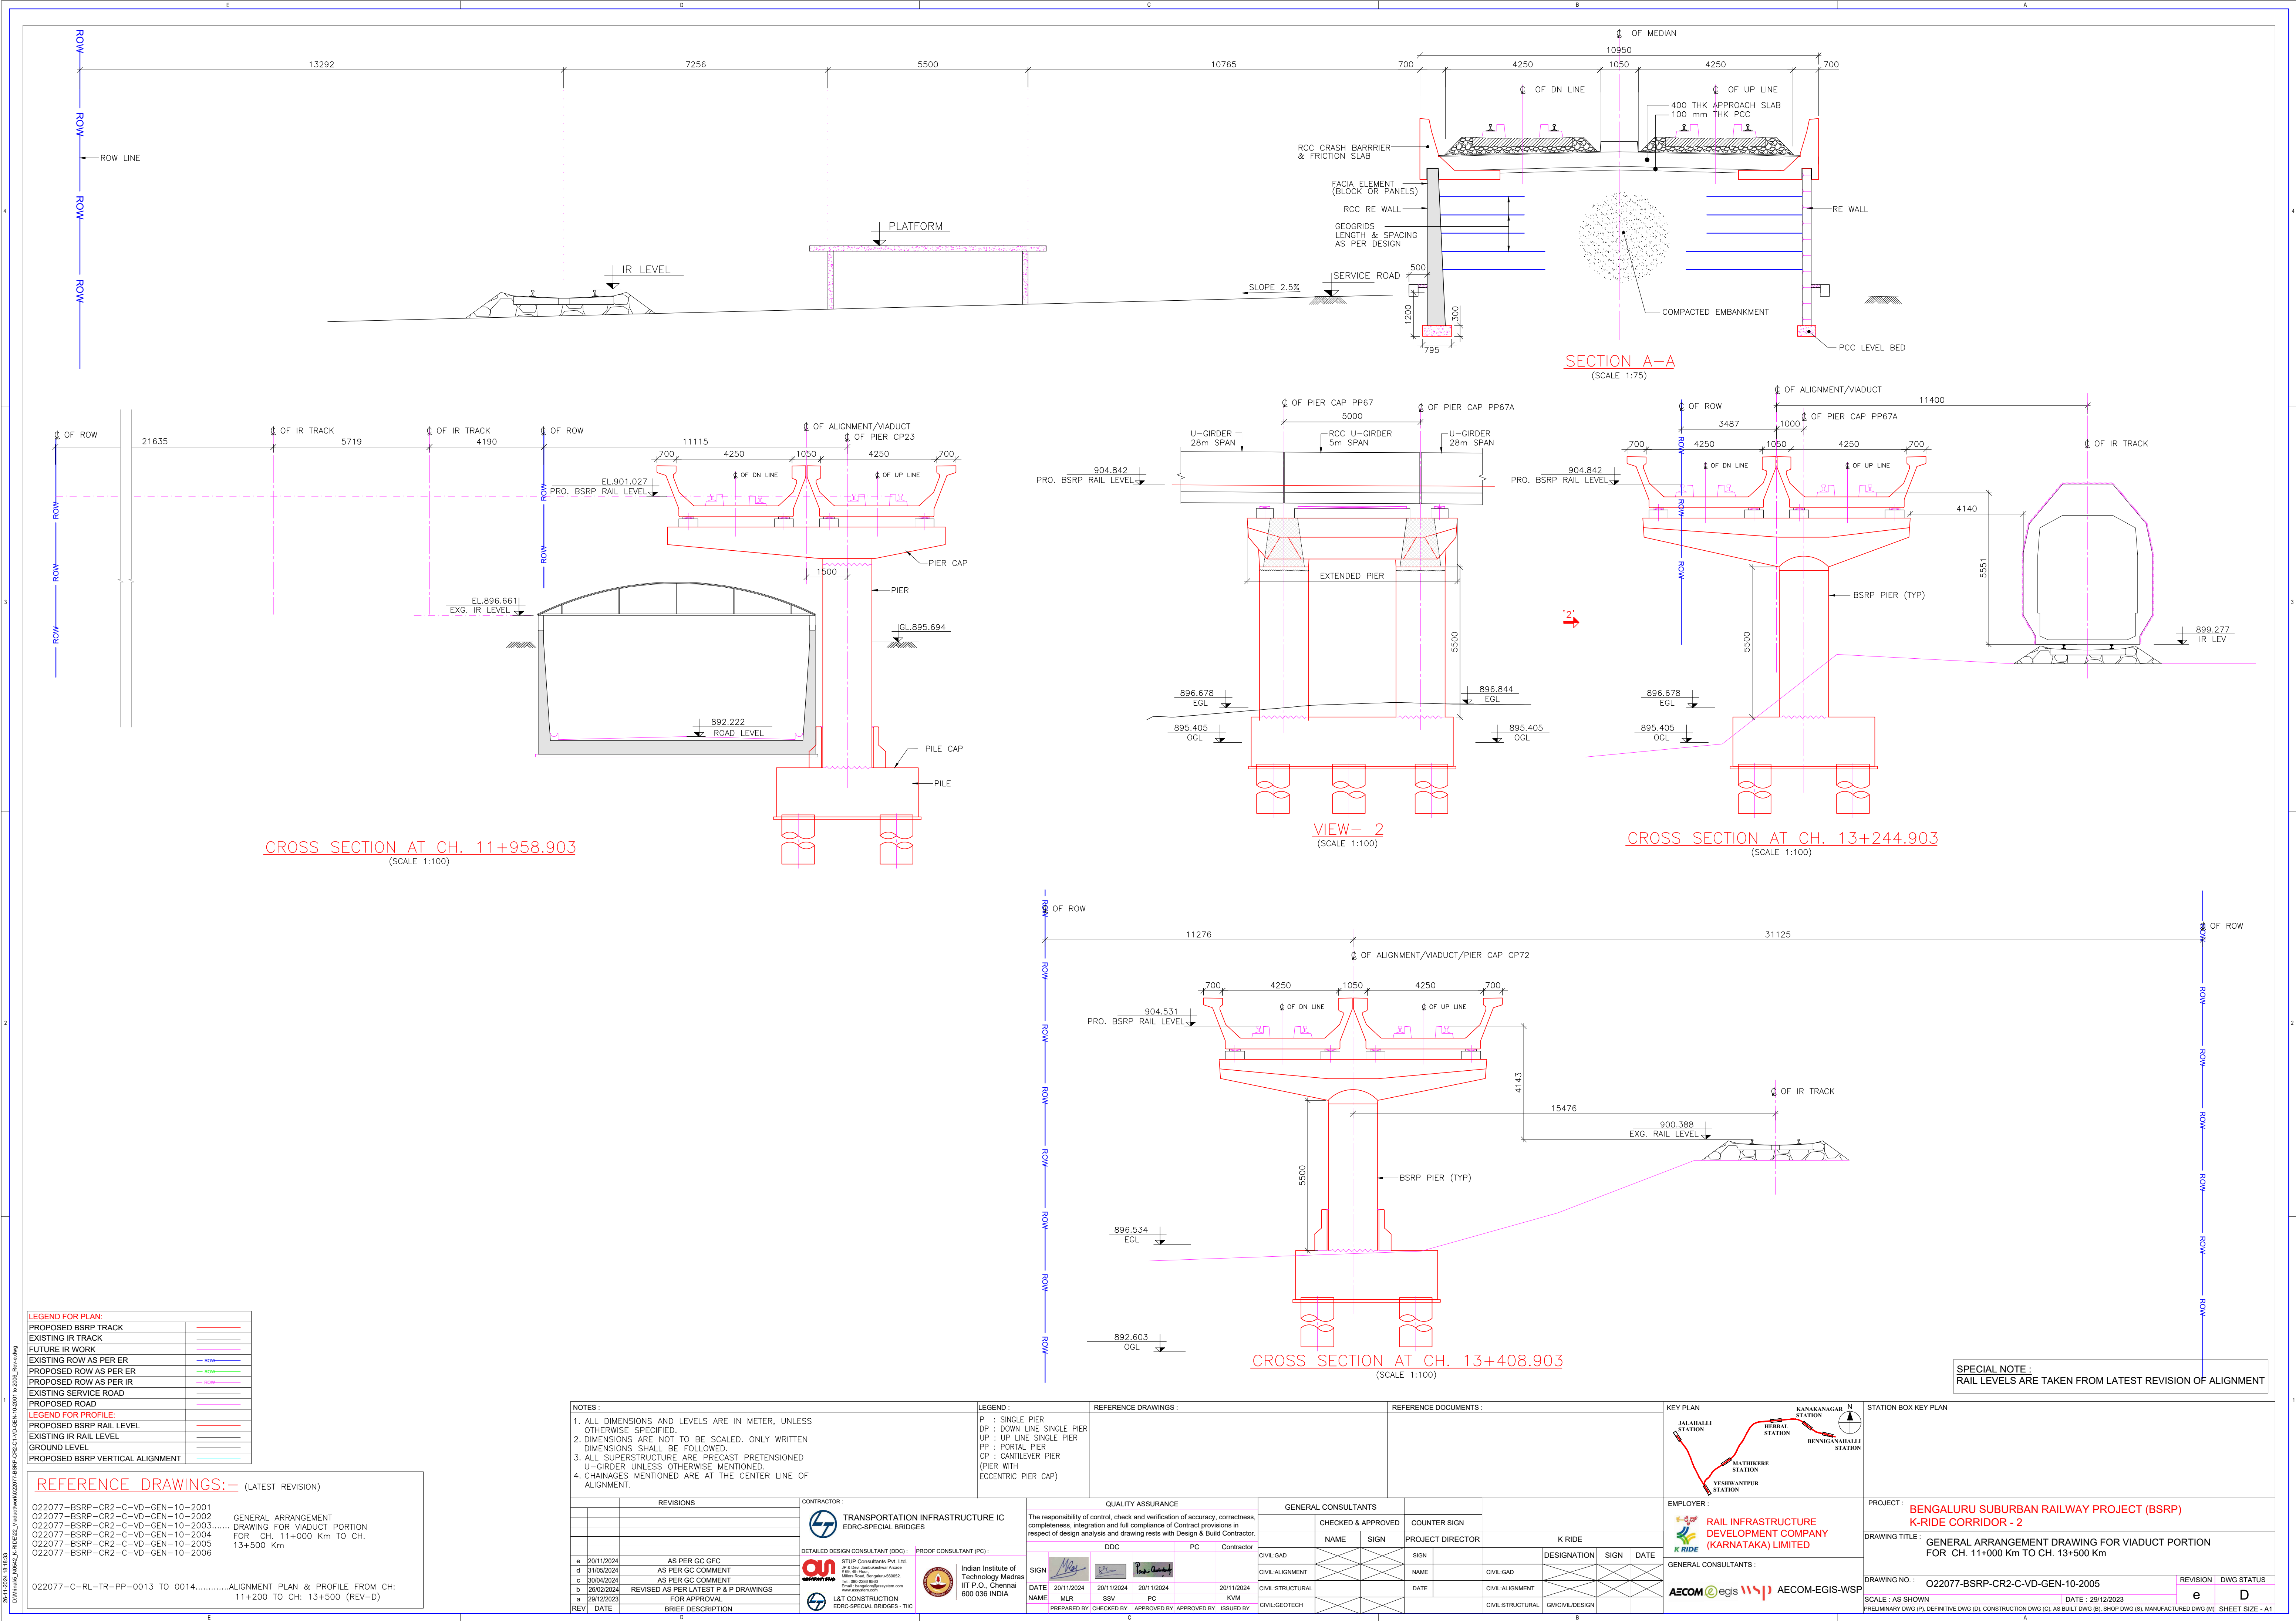

**LEGEND FOR PLAN:**

PROPOSED BSRP TRACK	---
EXISTING IR TRACK	---
FUTURE IR WORK	---
EXISTING ROW AS PER ER	---
PROPOSED ROW AS PER ER	---
PROPOSED ROW AS PER IR	---
EXISTING SERVICE ROAD	---
PROPOSED ROAD	---
<b>LEGEND FOR PROFILE:</b>	
PROPOSED BSRP RAIL LEVEL	---
EXISTING IR RAIL LEVEL	---
GROUND LEVEL	---
PROPOSED BSRP VERTICAL ALIGNMENT	---

**REFERENCE DRAWINGS:-** (LATEST REVISION)

022077-BSRP-CR2-C-VD-GEN-10-2001	GENERAL ARRANGEMENT
022077-BSRP-CR2-C-VD-GEN-10-2002	DRAWING FOR VIADUCT PORTION
022077-BSRP-CR2-C-VD-GEN-10-2003	FOR CH. 11+000 Km TO CH. 13+500 Km
022077-BSRP-CR2-C-VD-GEN-10-2004	
022077-BSRP-CR2-C-VD-GEN-10-2005	
022077-BSRP-CR2-C-VD-GEN-10-2006	

022077-C-RL-TR-PP-0013 TO 0014.....ALIGNMENT PLAN & PROFILE FROM CH: 11+200 TO CH: 13+500 (REV-D)

**NOTES:**

- ALL DIMENSIONS AND LEVELS ARE IN METER, UNLESS OTHERWISE SPECIFIED.
- DIMENSIONS ARE NOT TO BE SCALED. ONLY WRITTEN DIMENSIONS SHALL BE FOLLOWED.
- ALL SUPERSTRUCTURE ARE PRECAST PRETENSIONED U-GIRDER UNLESS OTHERWISE MENTIONED.
- CHAINAGES MENTIONED ARE AT THE CENTER LINE OF ALIGNMENT.

**LEGEND:**

P : SINGLE PIER  
DP : DOWN LINE SINGLE PIER  
UP : UP LINE SINGLE PIER  
PP : PORTAL PIER  
CP : CANTILEVER PIER (PIER WITH ECCENTRIC PIER CAP)

**REFERENCE DRAWINGS:**

**REFERENCE DOCUMENTS:**

**KEY PLAN**

**STATION BOX KEY PLAN**

**PROJECT:** BENGALURU SUBURBAN RAILWAY PROJECT (BSRP) K-RIDE CORRIDOR - 2

**DRAWING TITLE:** GENERAL ARRANGEMENT DRAWING FOR VIADUCT PORTION FOR CH. 11+000 Km TO CH. 13+500 Km

**DRAWING NO.:** 022077-BSRP-CR2-C-VD-GEN-10-2005

**SCALE:** AS SHOWN

**DATE:** 29/12/2023

**REVISION** **DWG STATUS**

**e** **D**

**SHEET SIZE:** A1


**CONTRACTOR:**

**TRANSPORTATION INFRASTRUCTURE IC**  
EDRC-SPECIAL BRIDGES


**DETAILED DESIGN CONSULTANT (DDC):**

**STUP Consultants Pvt. Ltd.**  
PLOT NO. 10, 11, 12, 2026, 202




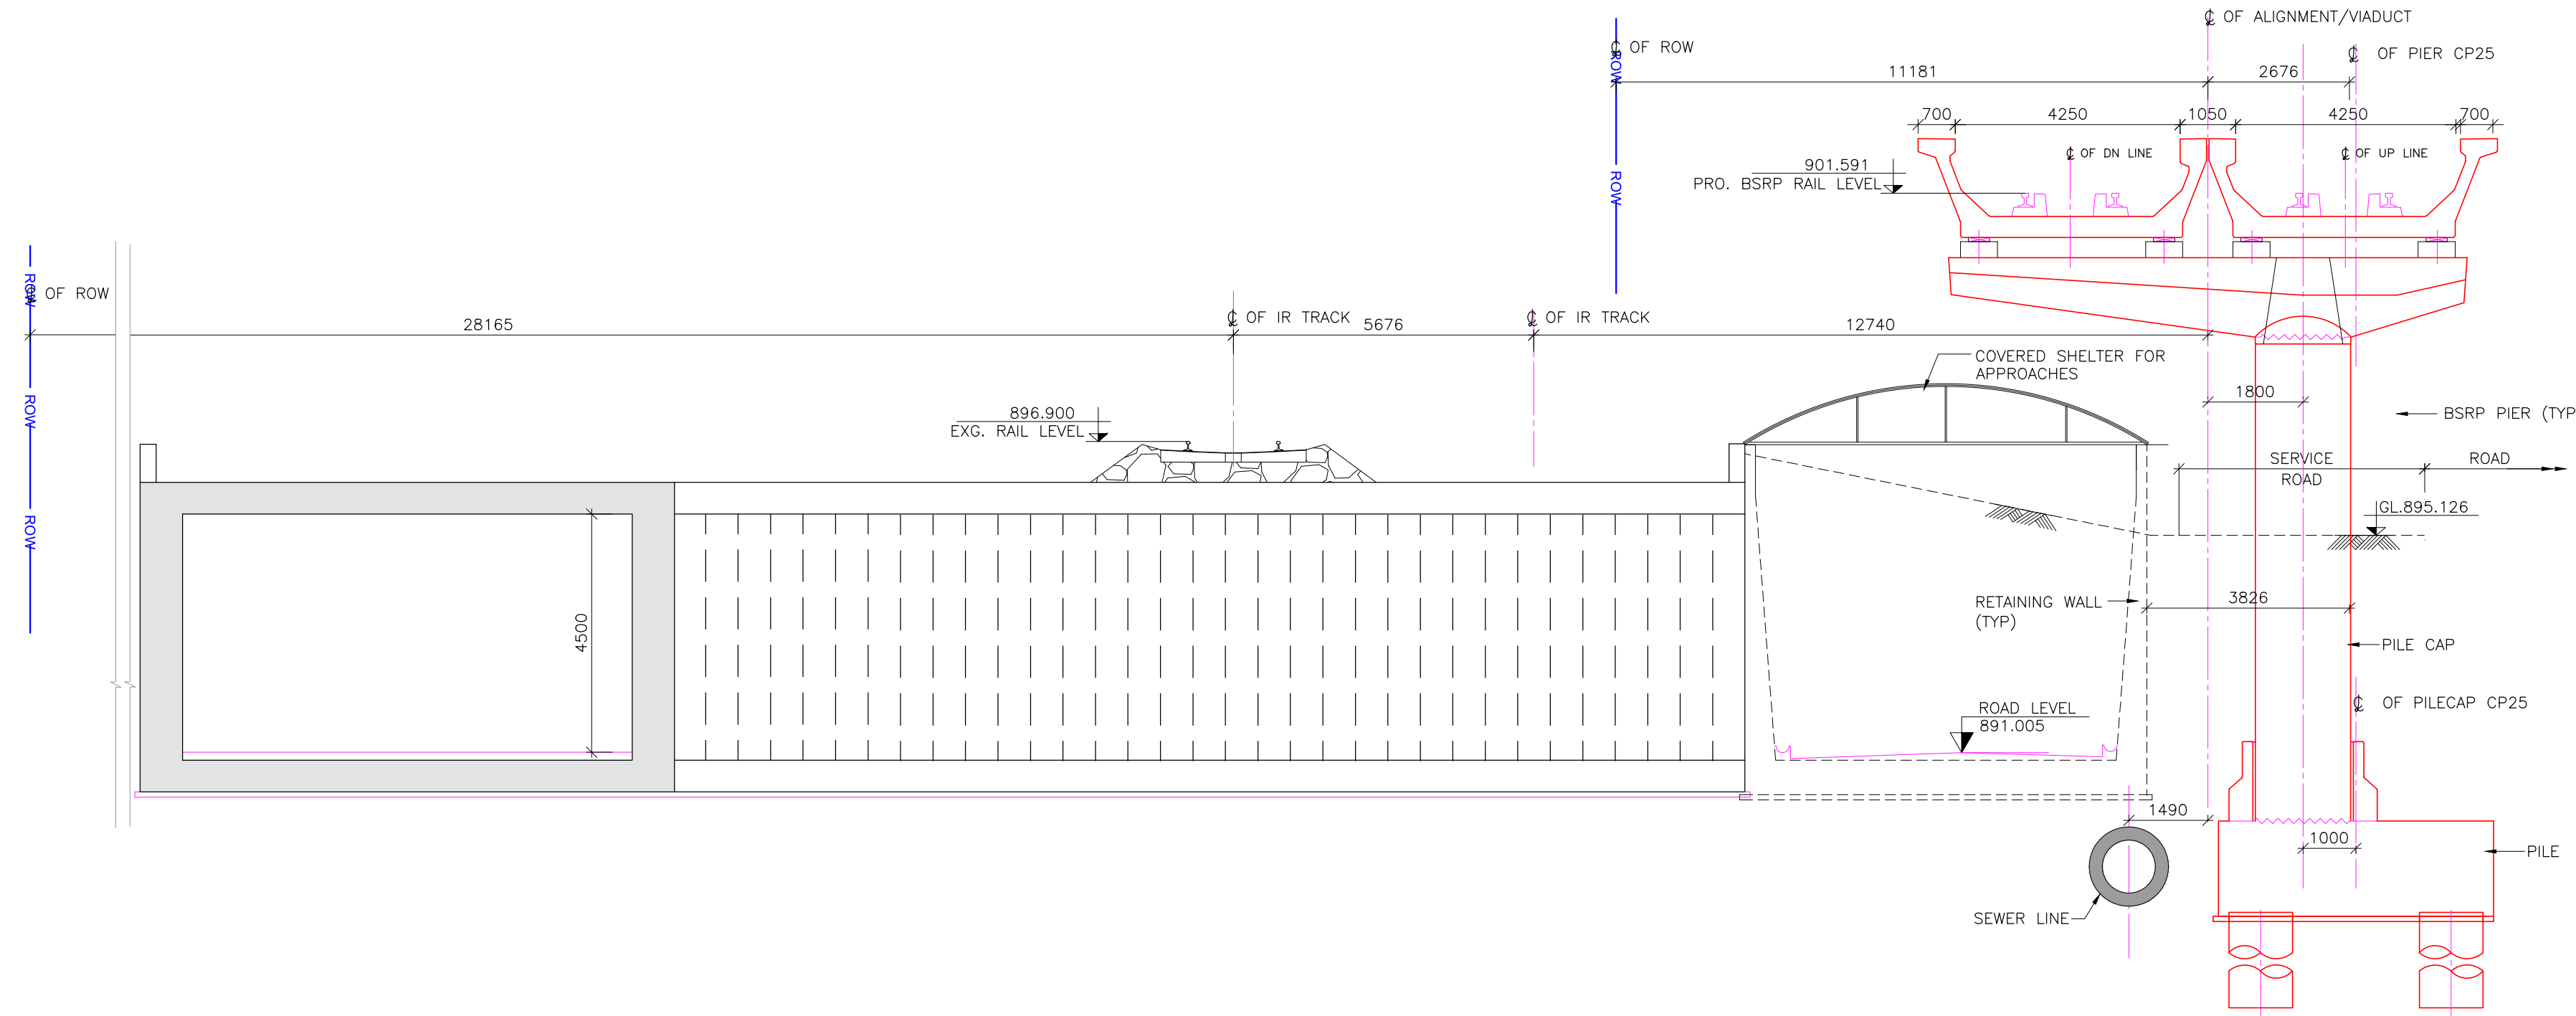


CROSS SECTION AT CH. 12+020.903  
(SCALE 1:100)

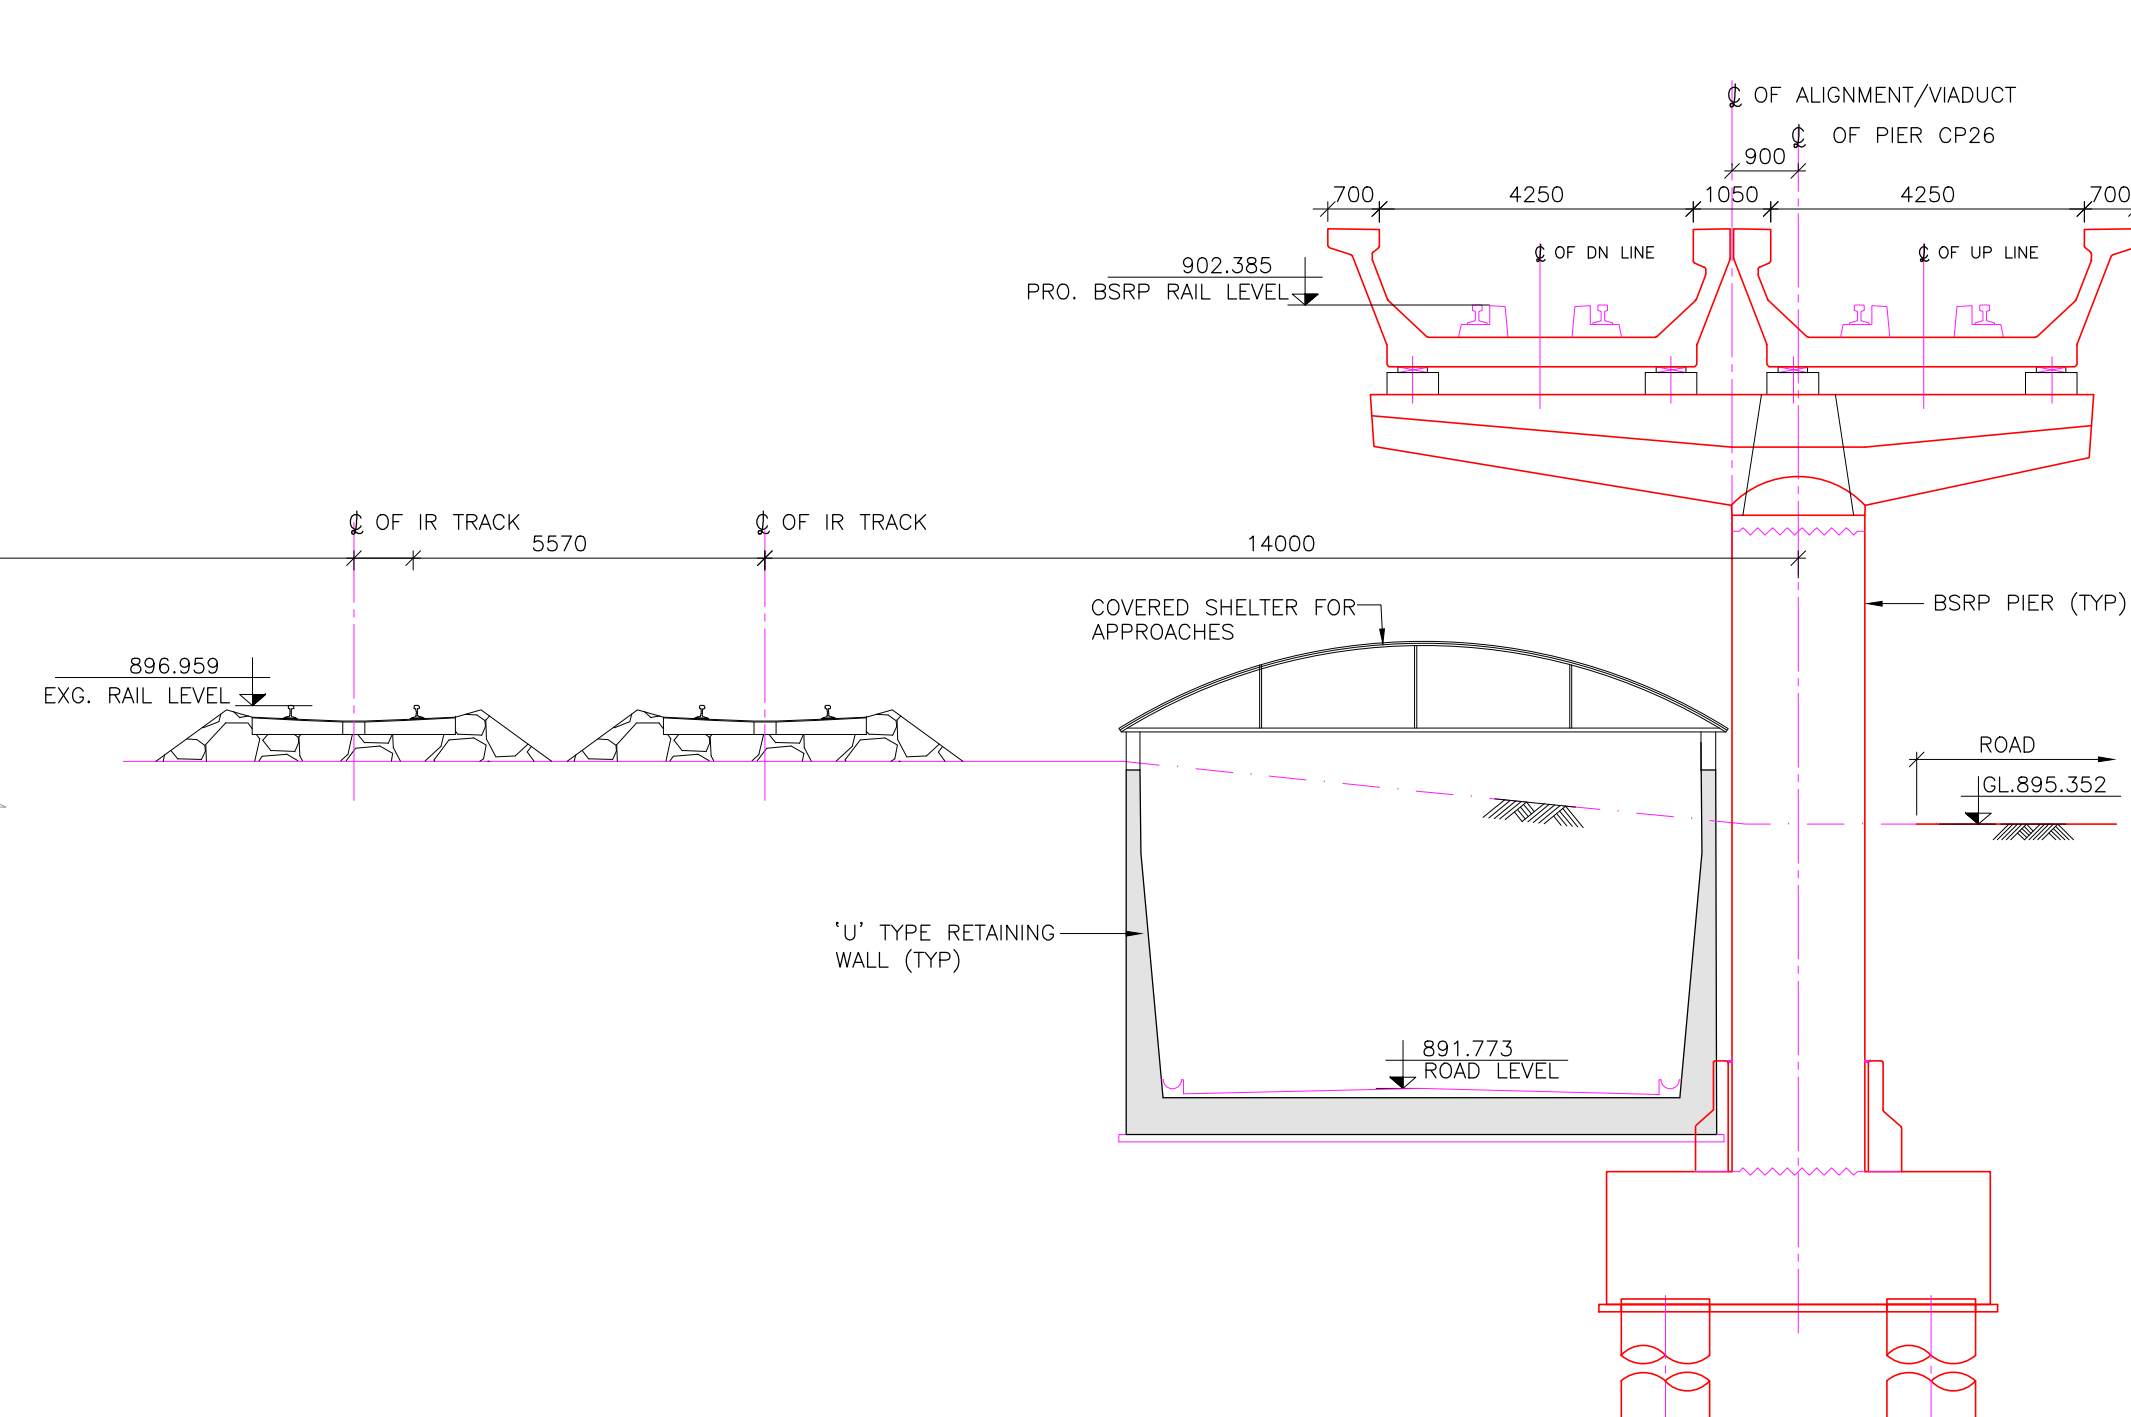


CROSS SECTION AT CH. 12+051.903  
(SCALE 1:100)

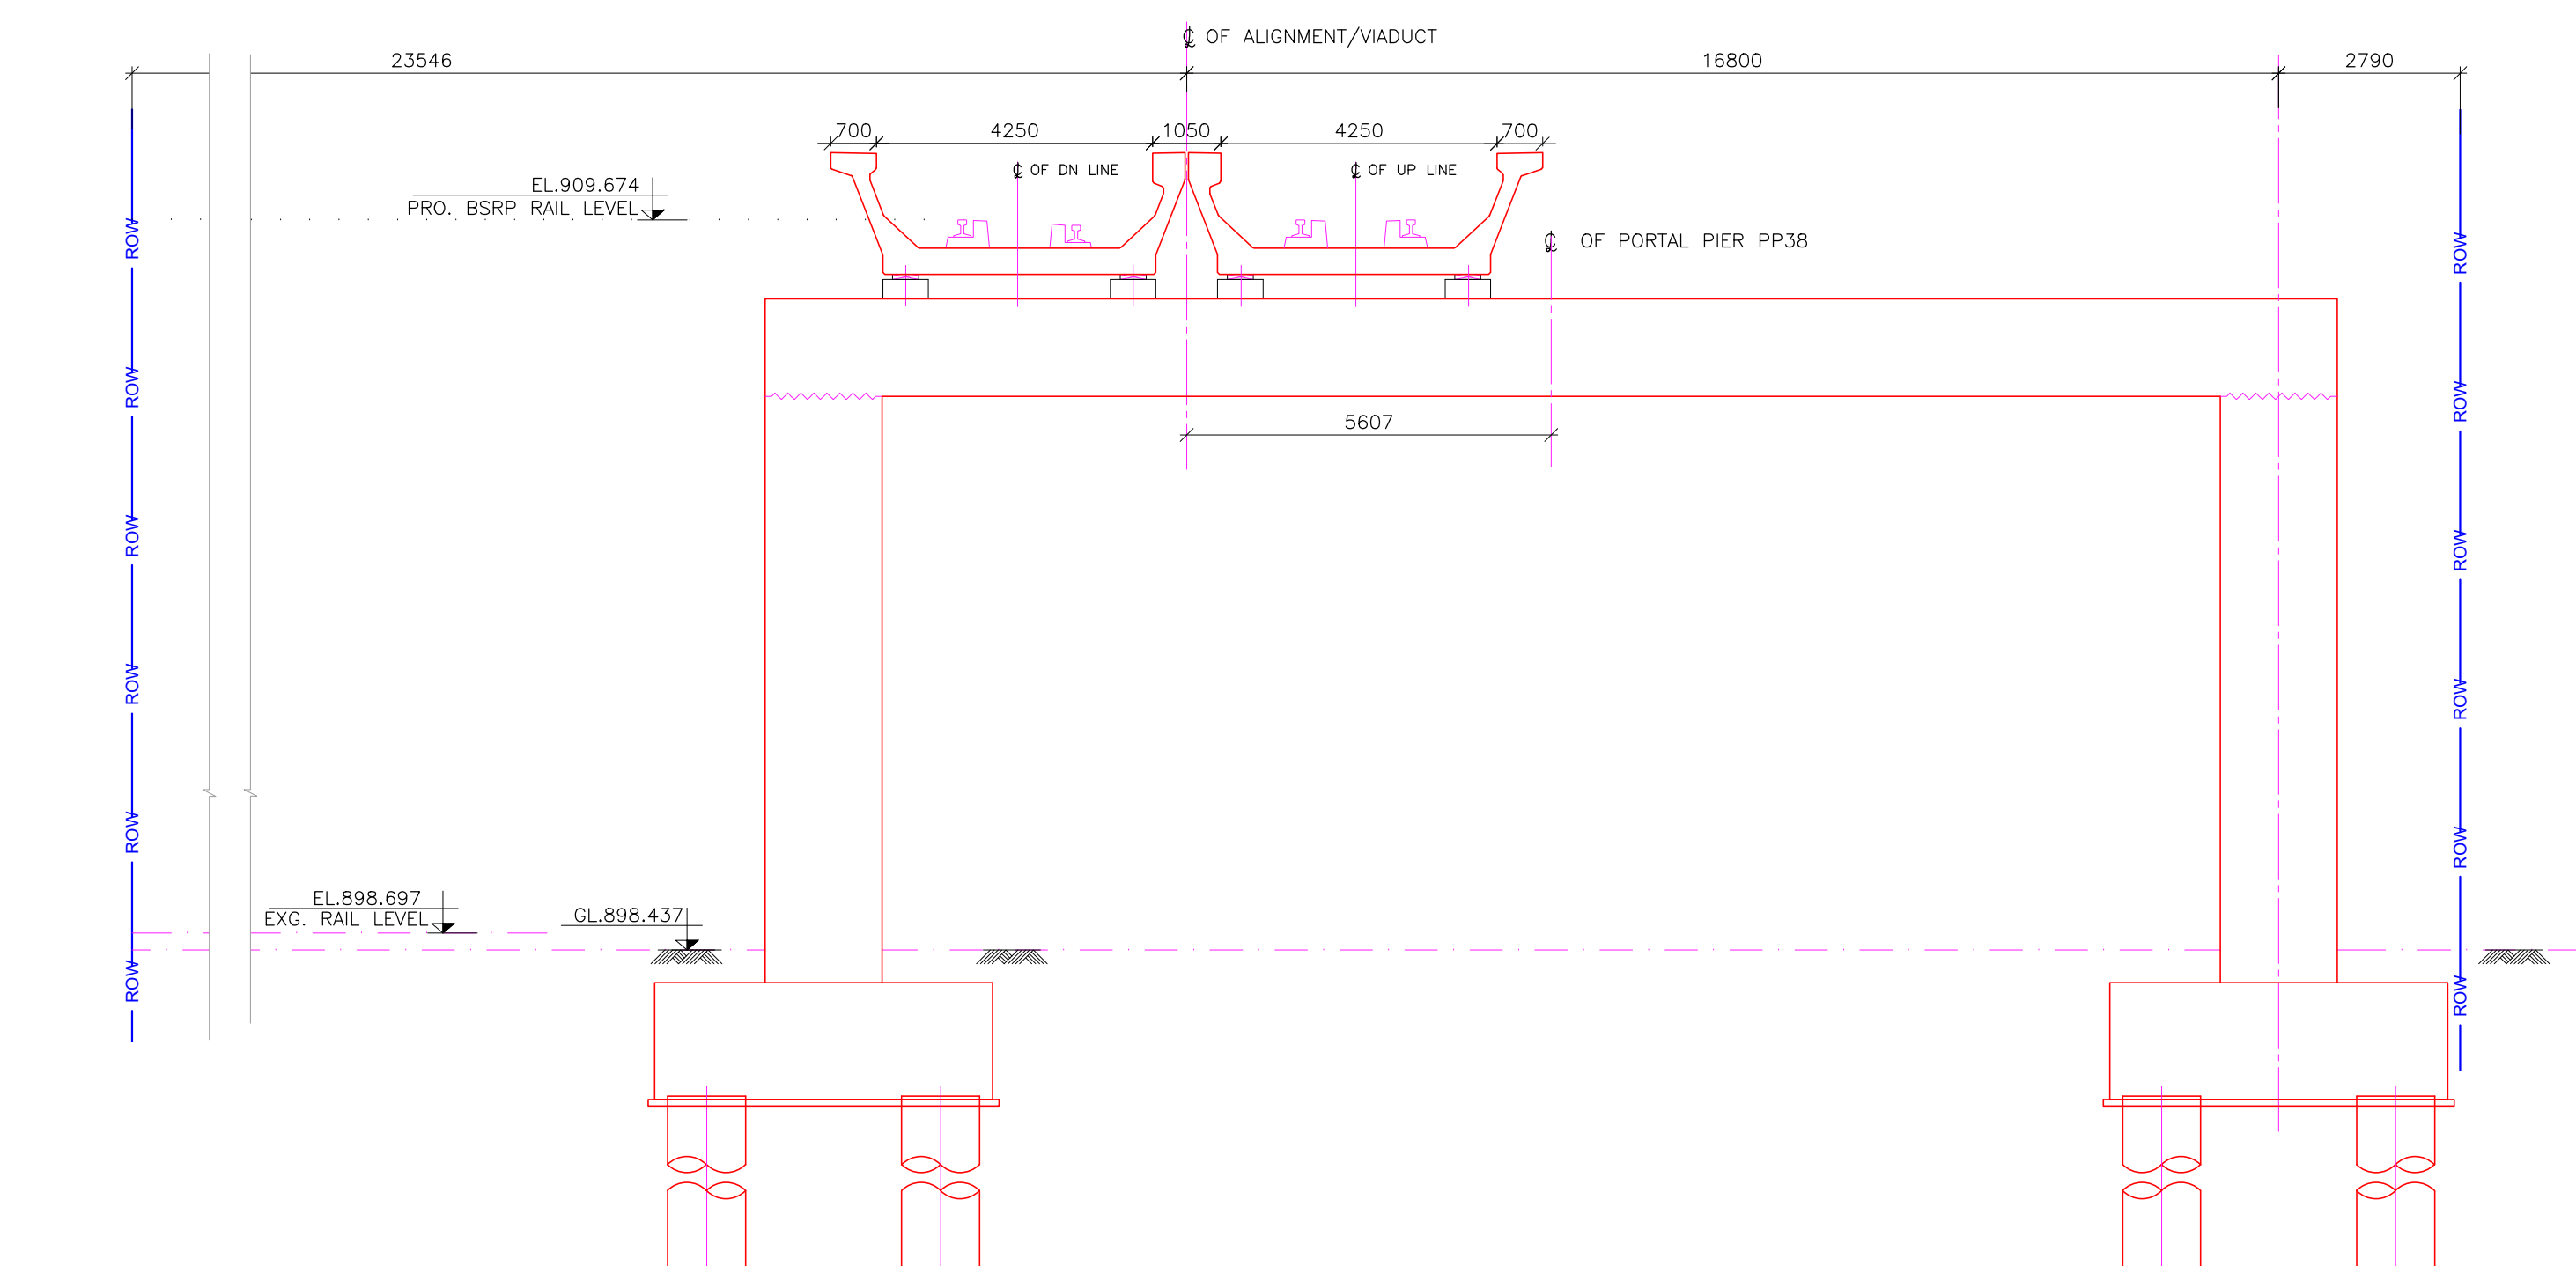

CROSS SECTION AT CH. 12+405.903  
(SCALE 1:100)

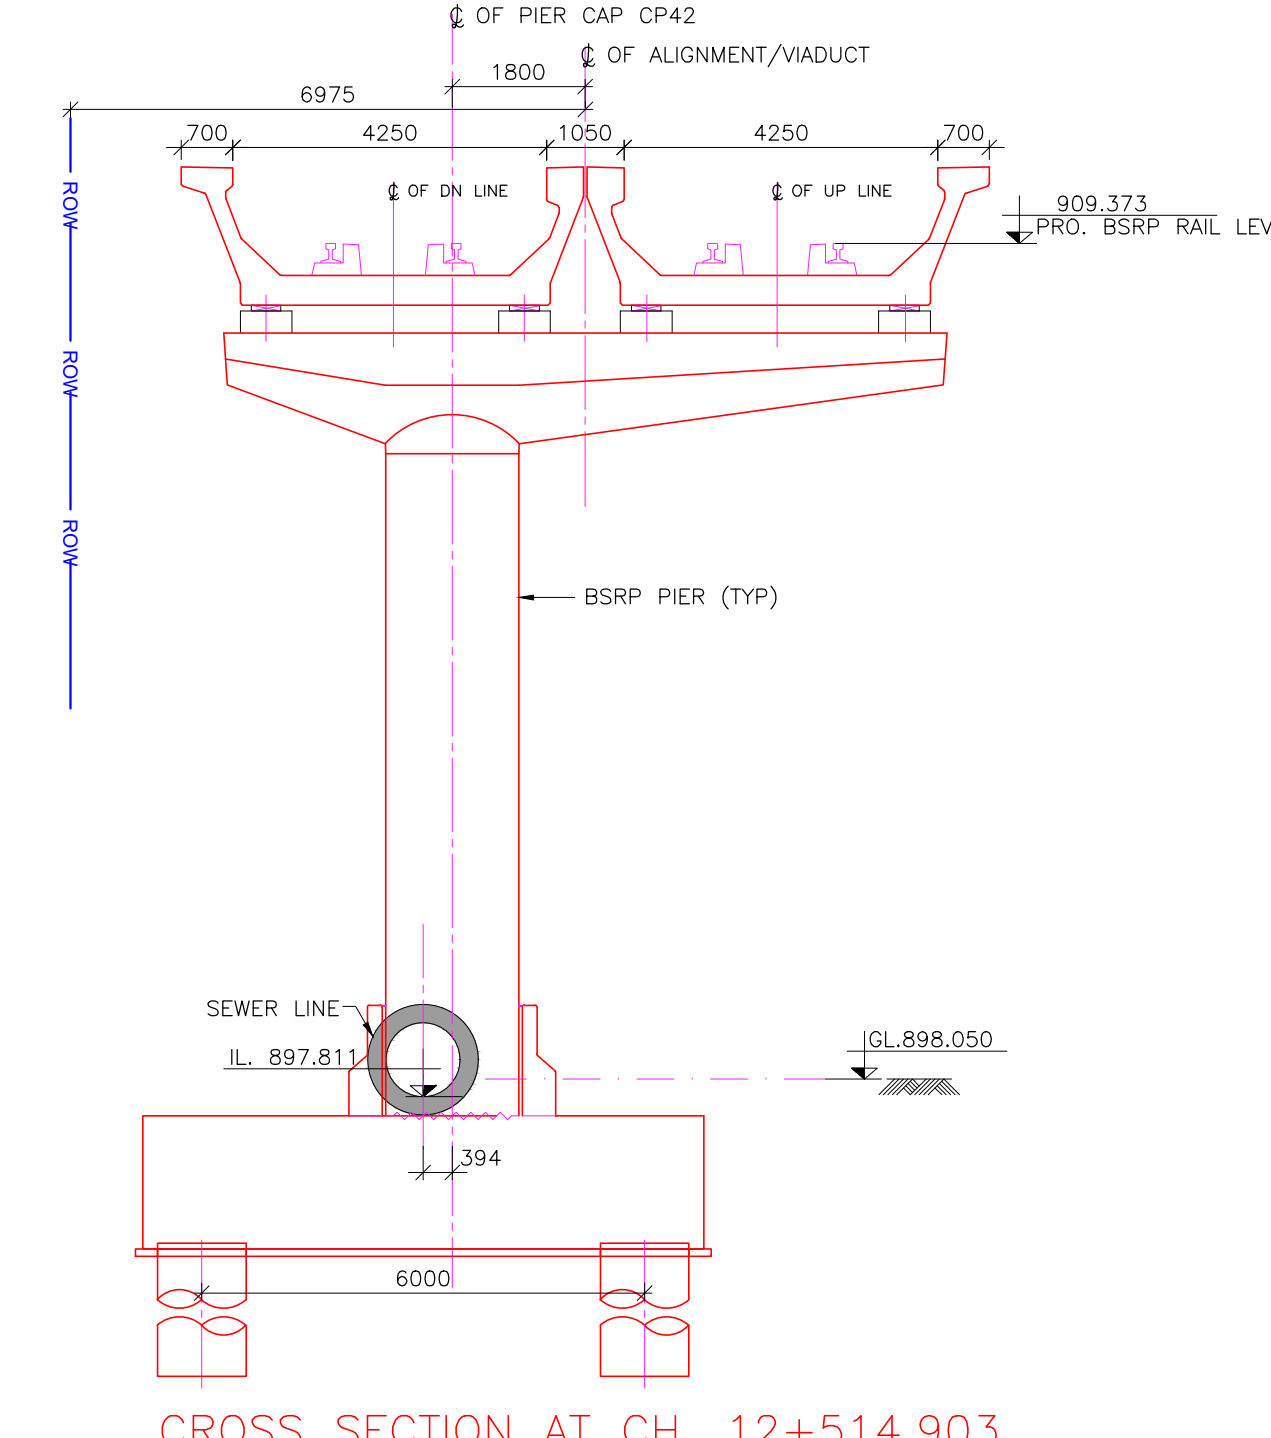

CROSS SECTION AT CH. 12+514.903  
(SCALE 1:100)

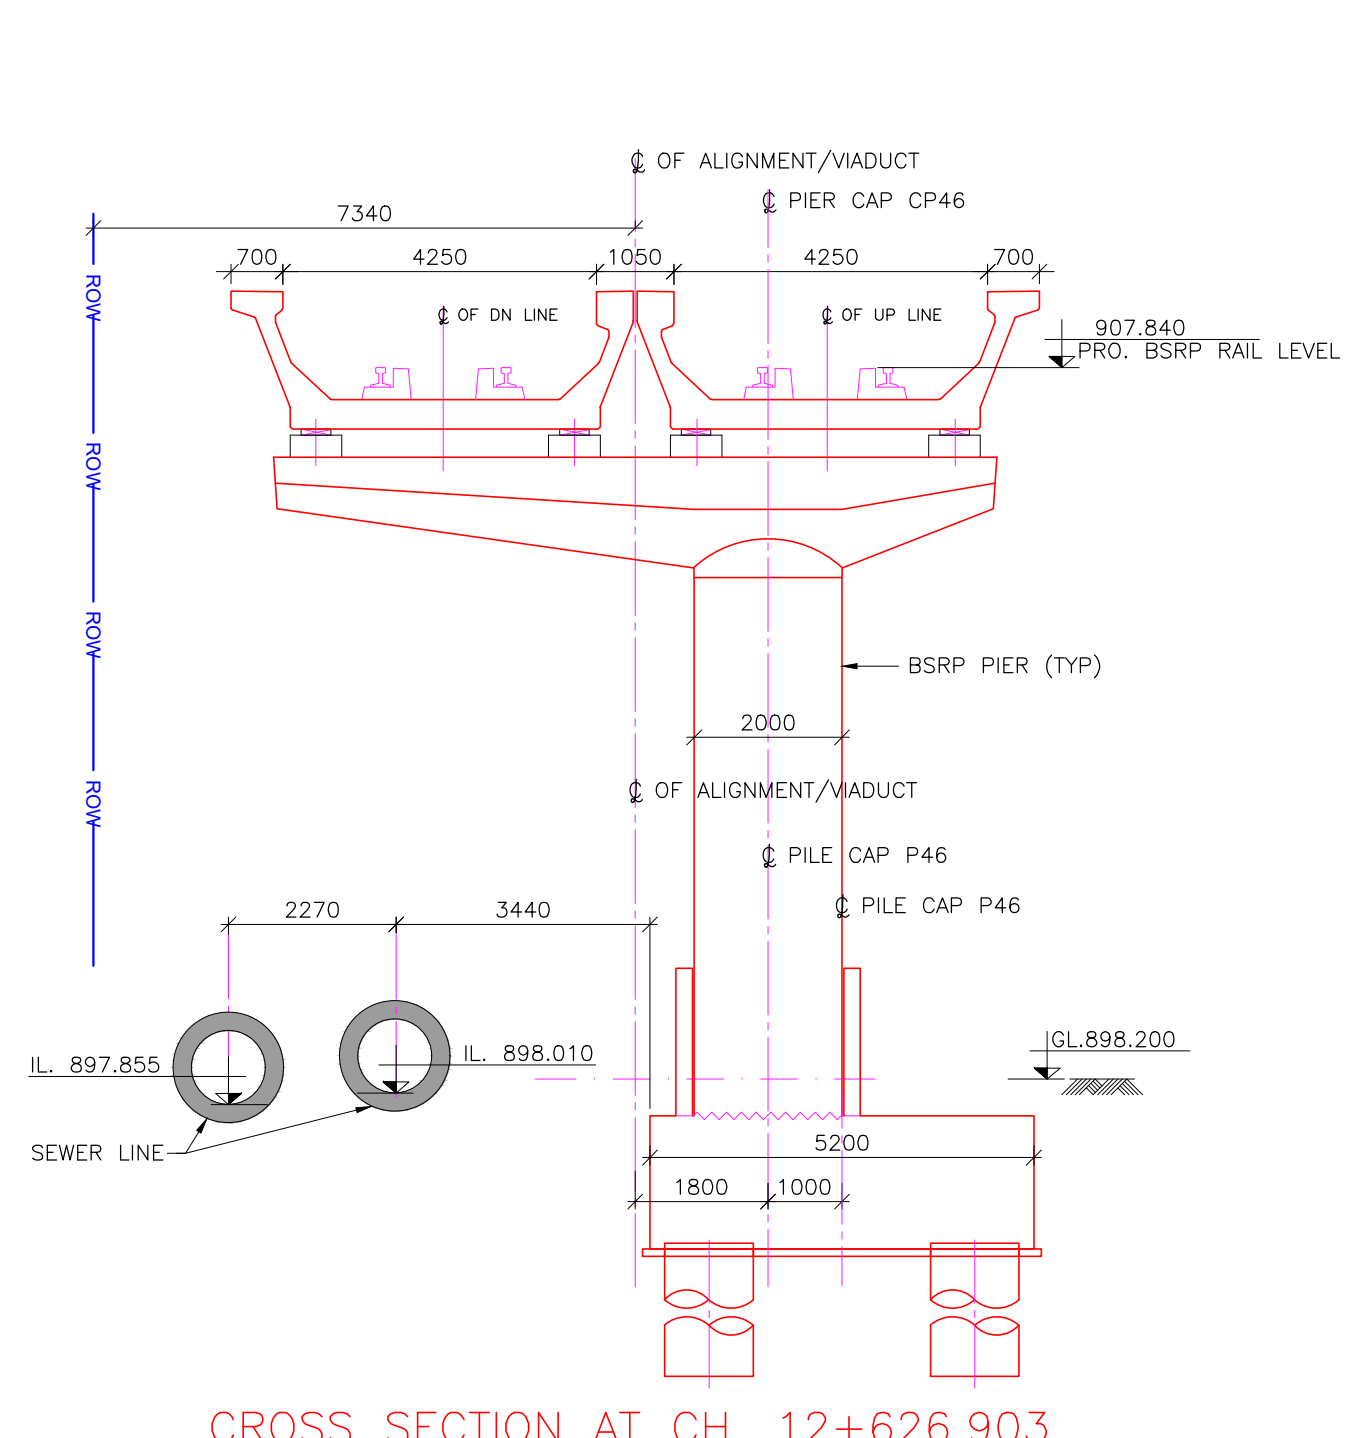

CROSS SECTION AT CH. 12+626.903  
(SCALE 1:100)

LEGEND FOR PLAN	
PROPOSED BSRP TRACK	---
EXISTING IR TRACK	---
FUTURE IR WORK	---
EXISTING ROW AS PER ER	---
PROPOSED ROW AS PER ER	---
PROPOSED ROW AS PER IR	---
EXISTING SERVICE ROAD	---
PROPOSED ROAD	---
LEGEND FOR PROFILE	
PROPOSED BSRP RAIL LEVEL	---
EXISTING IR RAIL LEVEL	---
GROUND LEVEL	---
PROPOSED BSRP VERTICAL ALIGNMENT	---

REFERENCE DRAWINGS:- (LATEST REVISION)

022077-BSRP-CR2-C-VD-GEN-10-2001	GENERAL ARRANGEMENT
022077-BSRP-CR2-C-VD-GEN-10-2002	DRAWING FOR VIADUCT PORTION
022077-BSRP-CR2-C-VD-GEN-10-2003	FOR CH. 11+000 Km TO CH. 13+500 Km
022077-BSRP-CR2-C-VD-GEN-10-2004	
022077-BSRP-CR2-C-VD-GEN-10-2005	
022077-BSRP-CR2-C-VD-GEN-10-2006	

022077-C-RL-TR-PP-0013 TO 0014.....ALIGNMENT PLAN & PROFILE FROM CH: 11+200 TO CH: 13+500 (REV-D)


- NOTES:
1. ALL DIMENSIONS AND LEVELS ARE IN METER, UNLESS OTHERWISE SPECIFIED.
  2. DIMENSIONS ARE NOT TO BE SCALED. ONLY WRITTEN DIMENSIONS SHALL BE FOLLOWED.
  3. ALL SUPERSTRUCTURE ARE PRECAST PRETENSIONED U-CORNER UNLESS OTHERWISE MENTIONED.
  4. CHAINAGES MENTIONED ARE AT THE CENTER LINE OF ALIGNMENT.

LEGEND:

P : SINGLE PIER  
DP : DOWN LINE SINGLE PIER  
UP : UP LINE SINGLE PIER  
PP : PORTAL PIER  
CP : CANTILEVER PIER (PIER WITH ECCENTRIC PIER CAP)

REFERENCE DRAWINGS :

REFERENCE DOCUMENTS :

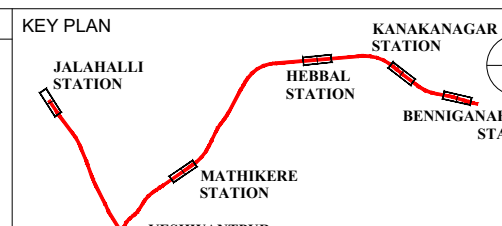

STATION BOX KEY PLAN

SPECIAL NOTE:  
RAIL LEVELS ARE TAKEN FROM LATEST REVISION OF ALIGNMENT

REVISIONS	
REV	DESCRIPTION
a	29/12/2023 FOR APPROVAL
b	29/12/2023 REVISED AS PER LATEST P & P DRAWINGS
c	30/04/2024 AS PER GC COMMENT
d	31/05/2024 AS PER GC COMMENT
e	20/11/2024 AS PER GC GFC

CONTRACTOR:	TRANSPORTATION INFRASTRUCTURE IC EDRC-SPECIAL BRIDGES
DETAILED DESIGN CONSULTANT (DDC):	STUP Consultants Pvt. Ltd. PLOT NO. 10, 11, 12, 999, 1000

CONTRACTOR:	TRANSPORTATION INFRASTRUCTURE IC EDRC-SPECIAL BRIDGES
DETAILED DESIGN CONSULTANT (DDC):	STUP Consultants Pvt. Ltd. PLOT NO. 10, 11, 12, 999, 1000

QUALITY ASSURANCE	GENERAL
-------------------	---------