

REVISIONS		
REV.NO.	DATE	DESCRIPTION
R6	07.06.2025	REVISED AS PER GC COMMENTS
R5	30.05.2025	REVISED AS PER GC COMMENTS
R4	20.05.2025	REVISED AS PER GC COMMENTS
R3	12.04.2025	REVISED AS PER GC COMMENTS
R2	03.02.2025	REVISED AS PER GC COMMENTS
R1	03.02.2025	FLOOR PLAN AND TERRACE PLAN

DDC CONSULTANT
BARSYL
BALAJI RAILROAD
SYSTEMS (P) LIMITED


PROOF CONSULTANT (PC):

DETAILED DESIGN CONSULTANT DDC				
PREPARED , CHECKED AND APPROVED				
DESIGNATION	SIGNATURE	DATE	PC	CONSULTANT
PREPARED BY ARCHITECT				
CHECKED BY DESIGN LEAD				
APPROVED BY DGM-OPS				
APPROVED BY GBC CONSULTANT				

GENERAL CONSULTANT(AECOM-EGIS-WSP)			
CHECKED AND APPROVED			
DESIGNATION	SIGNATURE	DATE	COUNTER SIGN PROJECT DIRECTOR

KRIDE			
CHECKED AND APPROVED			
DESIGNATION	SIGNATURE	DATE	

EMPLOYER :		PROJECT :	
RAIL INFRASTRUCTURE DEVELOPMENT COMPANY(KARNATAKA) LIMITED		BENGALURU SUBURBAN RAILWAY PROJECT (BSRP)	
		KRIDE SOLADEVANAHALLI DEPOT	
DRAWING TITLE :		BATTERY AND CHARGING	
DRAWING NO :		SDH-DP-BTR-01-ARC-DD-001	
SCALE - 1:75		DATE	
AS SHOWN		1 OF 2	07.06.2025
PRELIMINARY DWG(P), DEFINITIVE DWG(D),CONSTRUCTION DWG(C)		REVISION	DWG STATUS
AS BUILT DWG(B), SHOP DWG(S), MANUFACTURED DWG(M)		R6	P
		SHEET SIZE	
		A1	

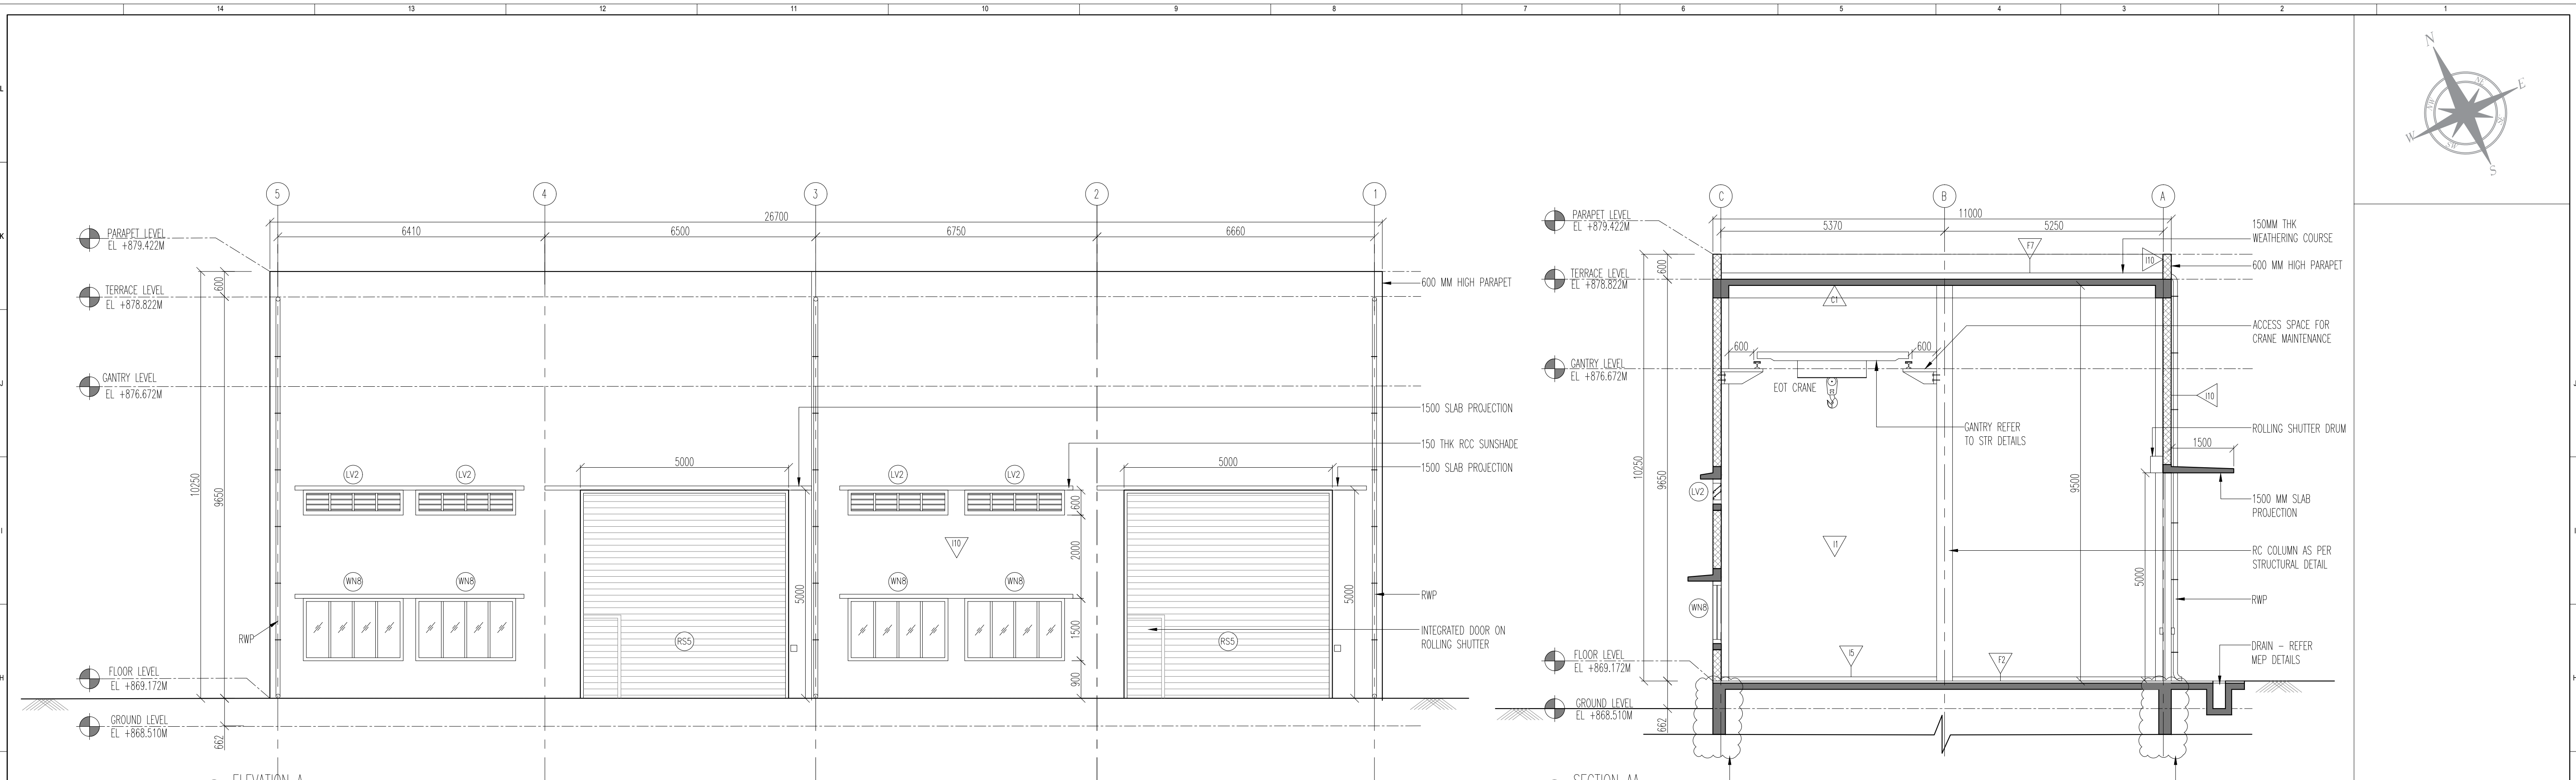

PRELIMINARY DWG(P), DEFINITIVE DWG(D), CONSTRUCTION DWG(C) AS BUILT DWG(B), SHOP DWG(S), MANUFACTURED DWG(M)	SHEET SIZE A1
---	------------------



PROJECT :					
BENGALURU SUBURBAN RAILWAY PROJECT (BSRP)					
KRIDE SOLADEVANAHALLI DEPOT					
DRAWING TITLE :		BATTERY AND CHARGING ELEVATION AND SECTION			
DRAWING NO : SDH-DP-BTR-01-ARC-DD-002					
SCALE - 1:75 AS SHOWN		SHEET NO.	DATE	REVISION	DWG STATUS
		2 OF 2	07.06.2025	R6	P
PRELIMINARY DWG(P), DEFINITIVE DWG(D),CONSTRUCTION DWG(C) AS BUILT DWG(B), SHOP DWG(S), MANUFACTURED DWG(M)					SHEET SIZE A1