



1 CONTROL ROOM GROUND FLOOR PLAN

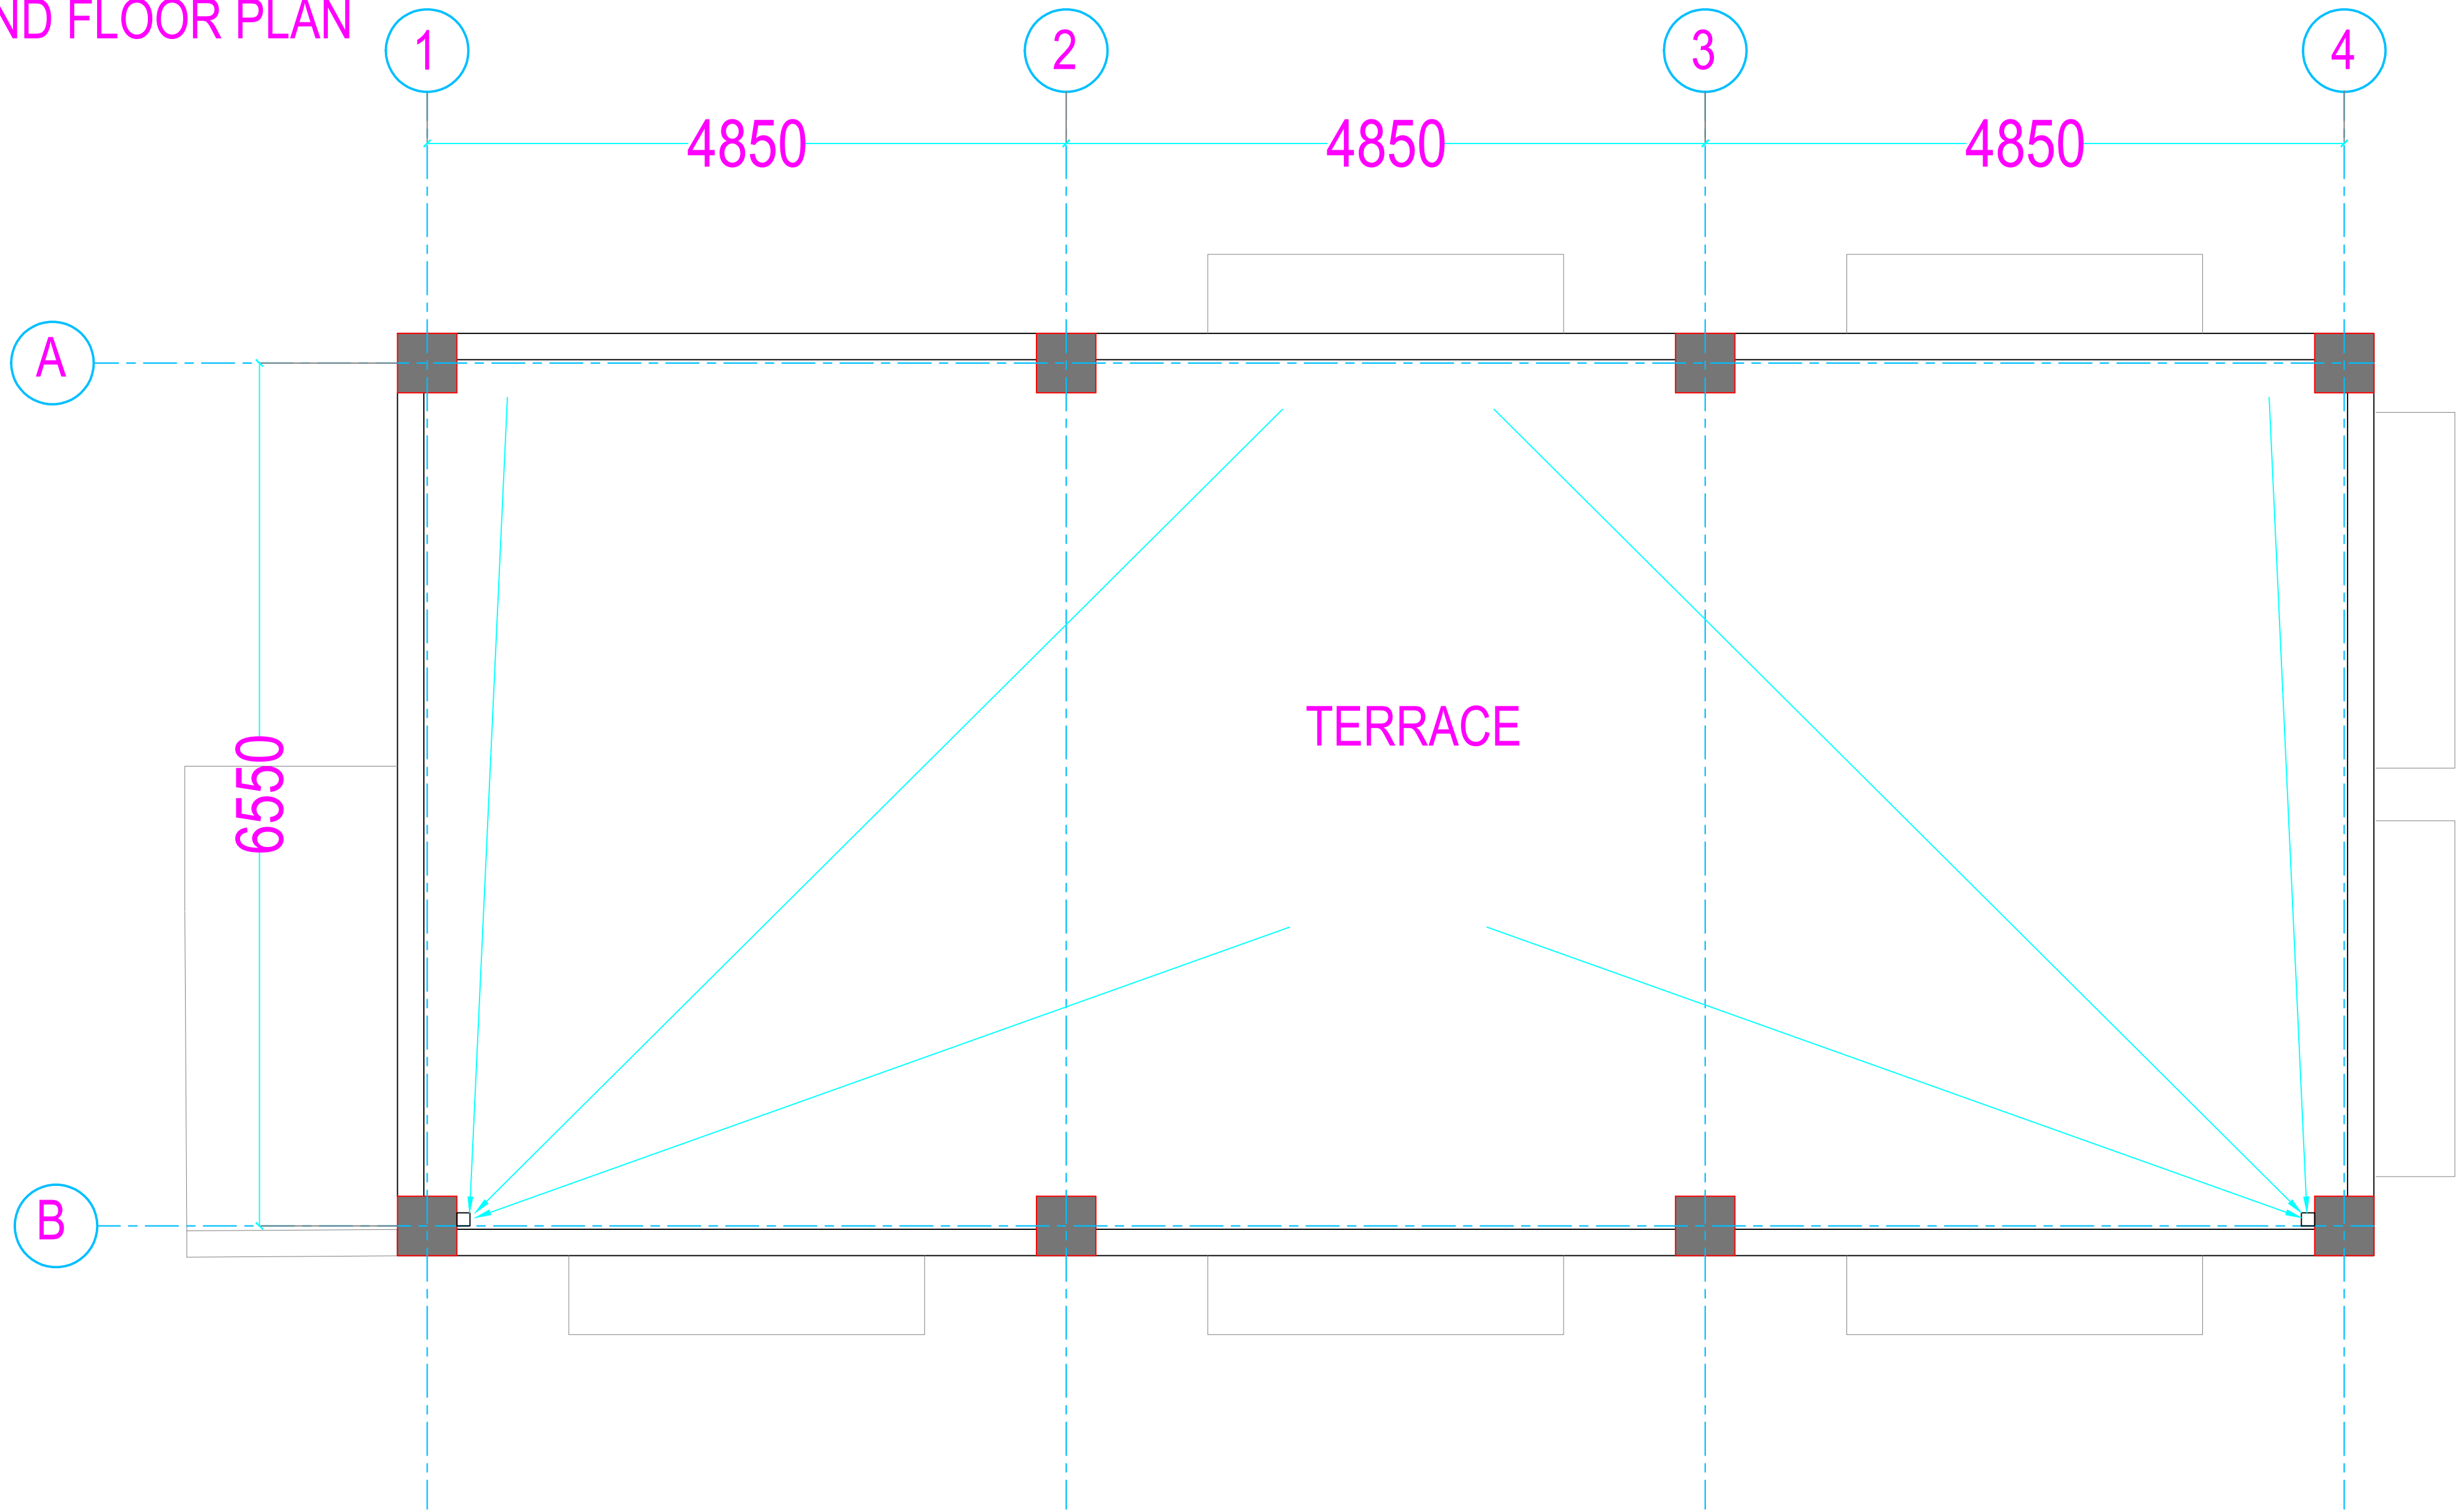

2 CONTROL ROOM TERRACE PLAN

TENDER DRAWING

- THIS DRAWING IS FOR INFORMATION AND REFERENCE AS A GENERAL GUIDANCE ONLY.
- ALL DEPOT FACILITIES, PLANTS & MACHINERIES, ACCOMMODATION FACILITIES, SYSTEM WIDE REQUIREMENTS ETC SHALL BE VERIFIED FOR MAINTENANCE REQUIREMENT OF ROLLING STOCK AND INFRASTRUCTURE FACILITIES.
- ALL DIMENSIONS ARE IN METER UNLESS NOTED OTHERWISE AND TO BE READ ONLY NOT MEASURED.
- ABSOLUTE RAIL LEVEL SHALL BE DERIVED FROM APPROVED ALIGNMENT DRAWINGS.
- STRUCTURE SYSTEM SHOWN IS INDICATIVE. ALL STRUCTURE MEMBER SIZES TO BE DETAILED BY DESIGNER AT LATER STAGE.
- THIS DRAWINGS HAVE BEEN DEVELOPED IN CONFORMITY TO DPR, SDO, BSR&R OTHER CODES REQUIREMENTS.
- SYSTEM ROOM SIZES, HEIGHTS, DOOR SIZE, FLOOR HEIGHT AND OUTCUT DIMENSIONS TO BE VERIFIED BY RELEVANT DISCIPLINES OF ENGINEERING.
- SHAFTS FOR ELECTRICAL, SAT, PLUMBING, DRAINAGE, SEWAGE DISPOSAL, RAIN WATER HARVESTING, FIRE AND OTHER SYSTEMS SHALL BE PROVIDED AS PER SYSTEM AND MEP REQUIREMENTS.
- ALL FINISHES ARE SUBJECT TO K-RIDE APPROVAL.
- SPACE CONSIDERED FOR ELECTRICAL & SAT CABLE TRENCH, DURING THE DETAILED DESIGN STAGE ELECTRICAL & SAT CABLE TRENCH WILL BE PROVIDED BASED ON DESIGN.
- 1 IN 8 S TURNOUTS PROVIDED IN THE DEPOT.
- PM DISTANCE PROVIDED AT 4.25M METERS.

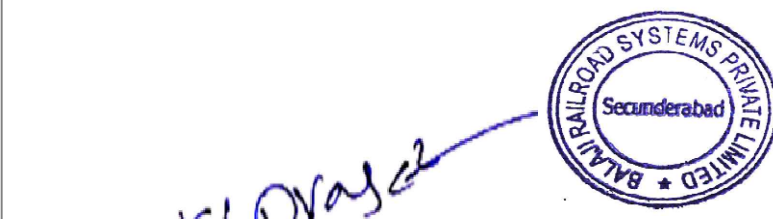

TENDER DRAWING		BARSYL		BALAJI RAILROAD SYSTEMS (P) LIMITED	
REV NO	DESCRIPTION	DATE	DESIGNED	CHECKED	APPROVED
1					



GENERAL CONSULTANT	
PROJECT DIRECTOR	GM / PLANNING
SR ALIGNMENT EXPERT	GM / CIVIL / DEPOT
CHIEF TRACK EXPERT	GM / ROLLING STOCK
CHIEF SIGNALLING EXPERT	GM / TRACTION
CHIEF TRACTION EXPERT	GM / SIGNALLING
CHIEF TELECOM EXPERT	
SR ROLLING STOCK ENGINEER	



K RIDE

DIRECTOR PROJECT PLANNING

DIRECTOR SYSTEM

K RIDE		RAIL INFRASTRUCTURE DEVELOPMENT COMPANY (KARNATAKA) LIMITED	
PROJECT ID: 2388			
TITLE:		SOLADEVANAHALLI DEPOT AUTO COACH WASH PLANT DETAILED DESIGN PLAN CONTROL ROOM PLAN	
CONSULTANT :		BARSYL BALAJI RAILROAD SYSTEMS (P) LIMITED.	
SCALE 1:50	SHEET NO. 1 OF 1	DRG NO: KRIDE_BSRP_RS_DEPOT_S0VL	REV 01