
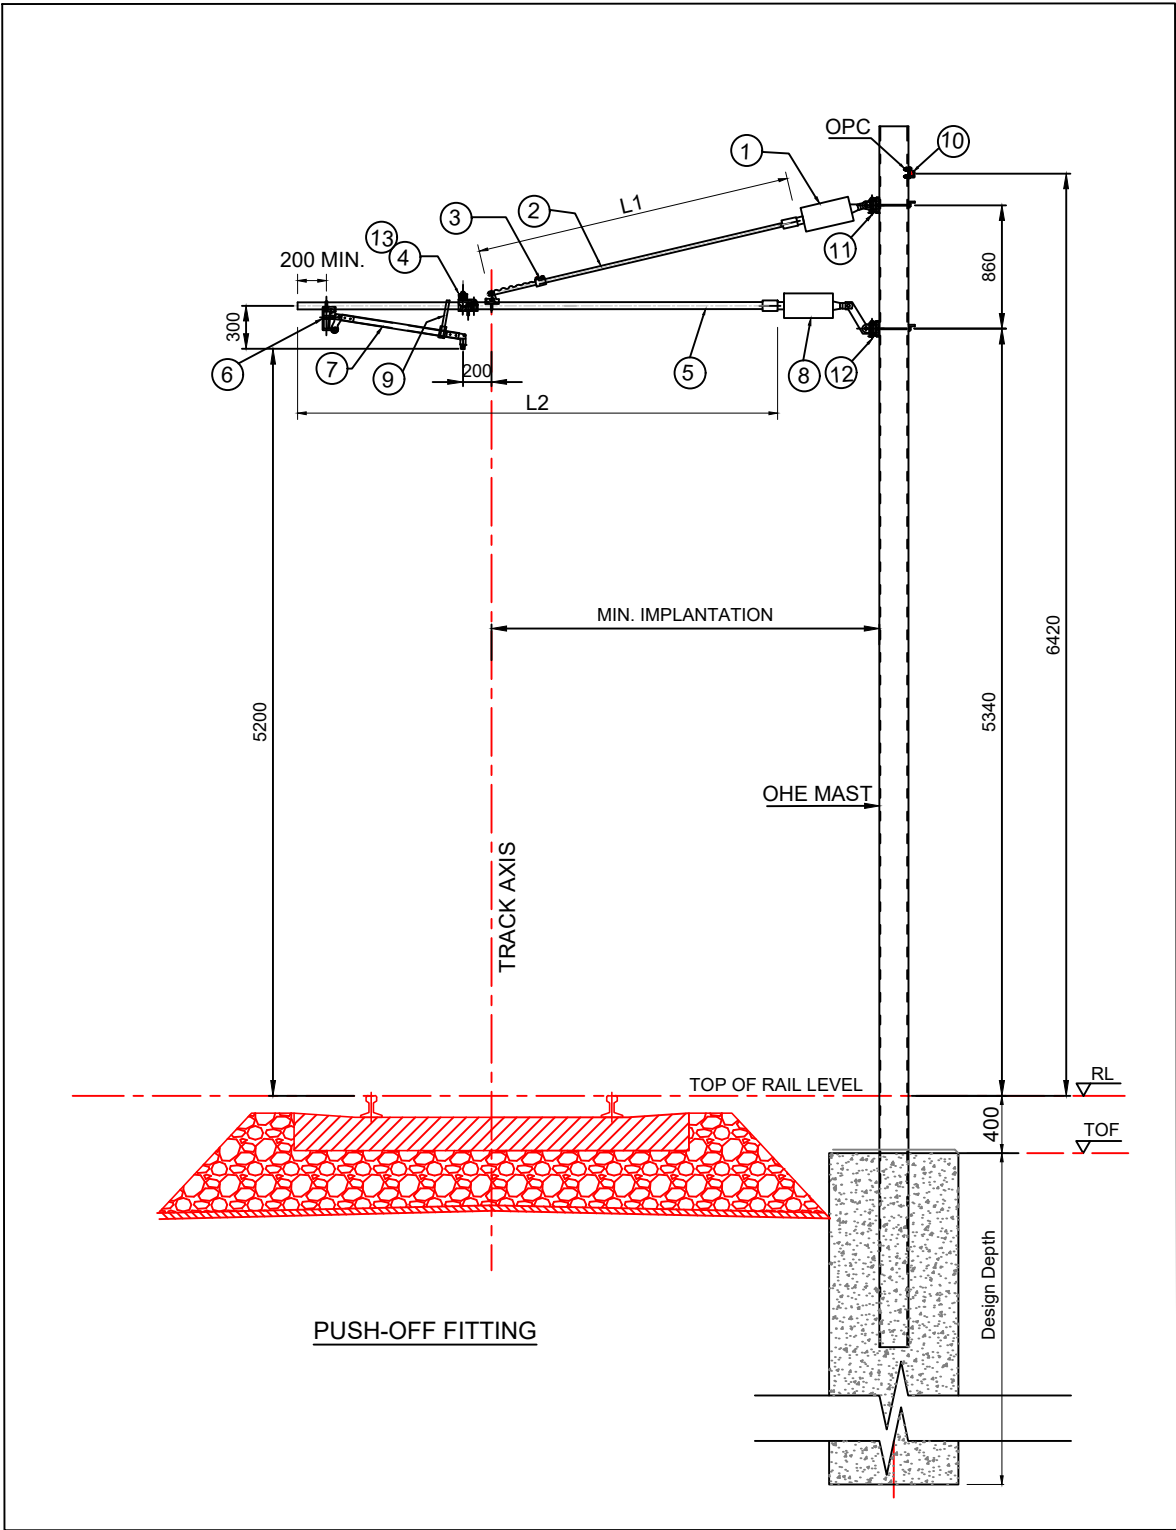


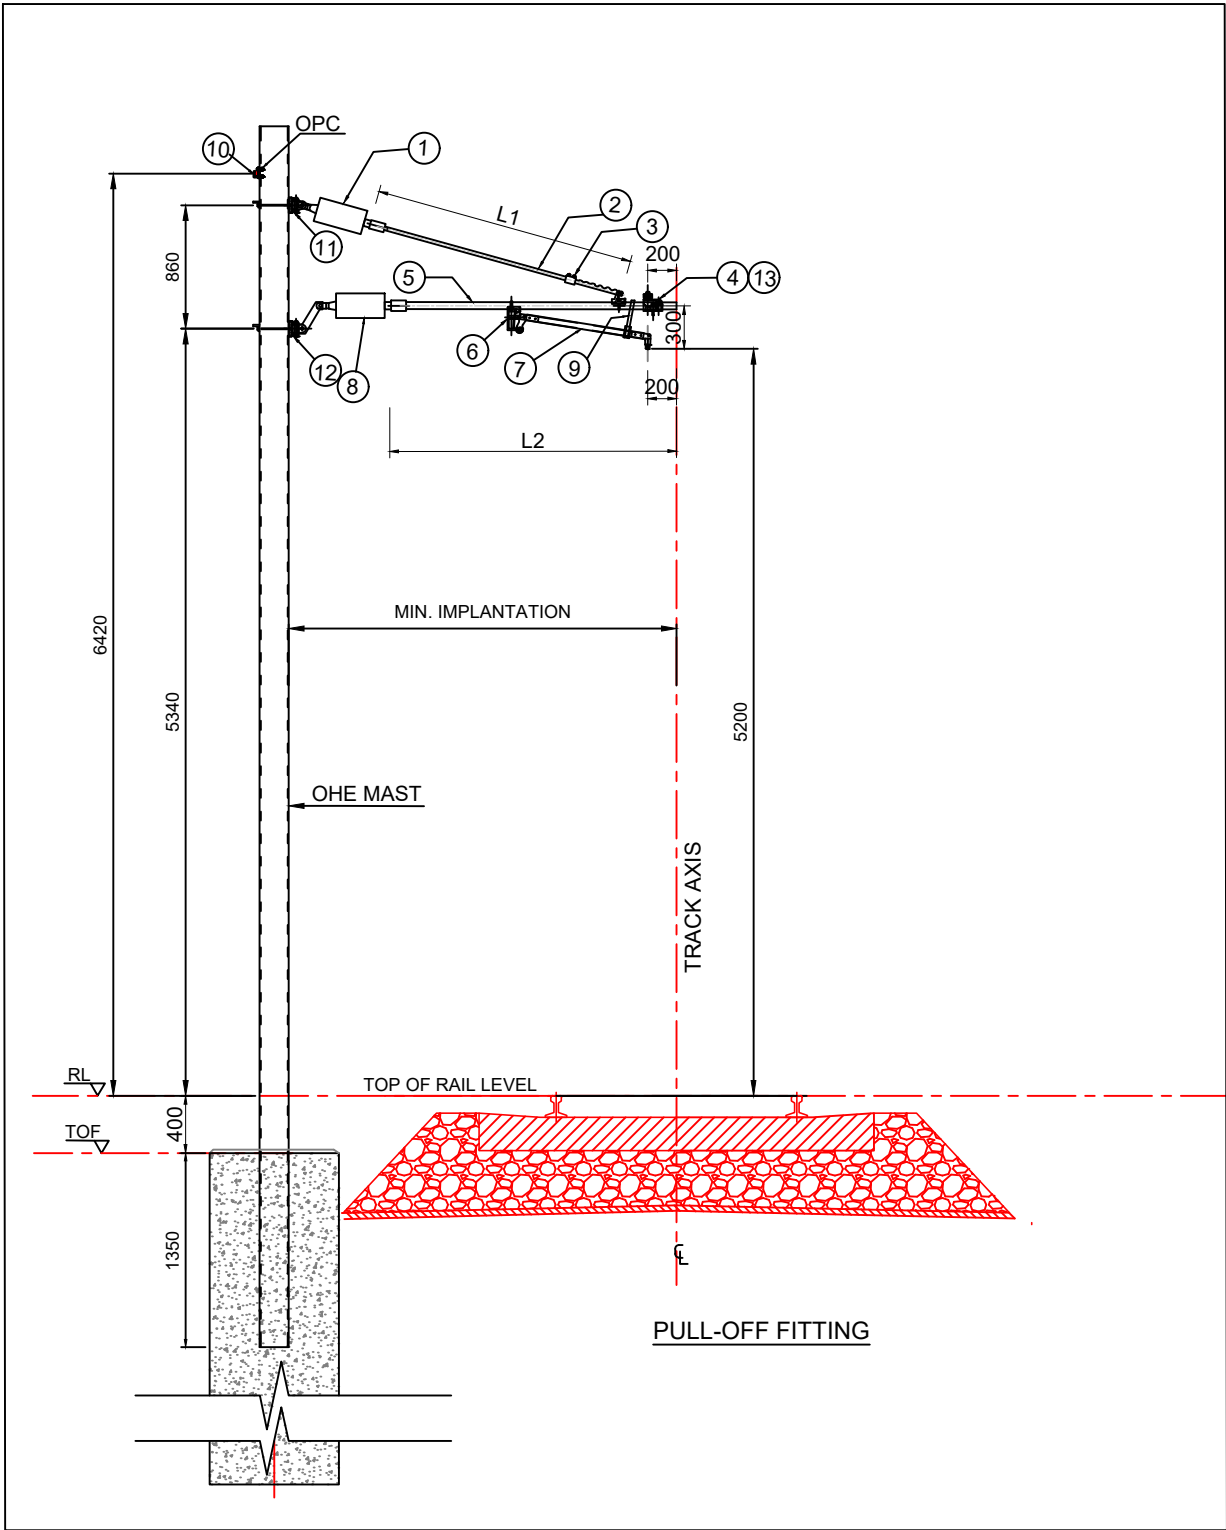

- NOTES:**
1. All dimensions are in mm unless otherwise specified.
 2. The arrangement shown is tentative , actual design will be confirmed on receipt of information from the relevant vendor.
 3. L1 shows the length of Stay Tube and L2 shows the length of Bracket Tube.
 4. Single cantilever for Tramway OHE based on ETI/OHE/G/04204 MOD 'B'
 5. The OPC clamping arrangement shall be as per RDSO drawing RE/33/P/7040 _MOD 'E'.
 6. For Foundation details refer separate drawing.
 7. Tender drawings are indicative only.

LEGEND:	
NO.	PART NAME
1	STAY ARM INSULATOR ASSEMBLY
2	STAY TUBE
3	TUBULAR STAY SLEEVE WITH ADJUSTER
4	LARGE CATENARY DIRECT CLAMP
5	LARGE BRACKET TUBE ASSEMBLY
6	LARGE REGISTER ARM HOOK
7	STEADY ARM
8	BRACKET INSULATOR ASSEMBLY
9	ANTIWIND CLAMP
10	EARTH WIRE MAST CLAMP- 7040
11	TOP FITTING
12	BOTTOM FITTING
13	BRIDLE WIRE SLEEVE

- NOTES:**
1. ALL DIMENSIONS ARE IN METER UNLESS MENTIONED OTHERWISE.
 2. ALL DIMENSIONS ARE TO BE READ AND NOT TO BE MEASURED.
 3. ANY DISCREPANCY IN THE DRAWING MUST BE BROUGHT TO THE NOTICE OF THE DESIGNER.
 4. INTERFACE WITH OTHER DESIGN DISCIPLINE WILL BE DONE AS PER AVAILABILITY OF DETAILS.

REV	DATE	DESCRIPTION	Originator	Checked	Approved
R1	02-09-2024	Revised as per K-RIDE comments	KD	CK / NP	RK / SK
R0	13-08-2024	FIRST SUBMISSION	DK / SB	CK / NP	RK / SK

K RIDE

DM / ELE / KRIDE Sr. DGM / ELE / KRIDE AGM / ELE / KRIDE

Certified that this document has been designed and checked in accordance with GC Quality Assurance Plan.

egis AECOM WSP
EGIS-AECOM-WSP
Senior Discipline Expert Chief Discipline Expert Project Director

Certified that this document has been designed and checked in accordance with DDC Quality Assurance Plan.

Detailed Design Consultant for design of Traction & Auxiliary Power Supply and Distribution for BSRP

SYSTRAM
SYSTRAM/VA CONSULTING (INDIA) PVT. LTD.
10th and 11th Floor, Tower-B, 12/3, Vattika
Mindscapes, Mathura Road, NH2, Sector 27D,
Faridabad, Haryana 121013

Drawn: D. Kumar, S. Bhati
Checked: D. Kalyan, N. Parmar
Approved: R. Kapoor, S. Kumar

Client: **K RIDE**
RAIL INFRASTRUCTURE DEVELOPMENT COMPANY (KARNATAKA) LIMITED

Project Title: Bengaluru Suburban Rail Project (BSRP)
(Detailed Design Consultant for design of Traction & Auxiliary Power Supply and Distribution for BSRP)

CORRIDOR-2 & 4

Drawing Title: TYPICAL ARRANGEMENT OF TRAMWAY OHE WITH SINGLE CANTILEVER AT DEPOT AND SIDING
Project Stage: Tender Drawing

Paper Size: A3 Discipline: Power Supply & Traction System Date: 13/08/2024 Scale: NTS
Drawing no.: KRDD01-TDR-GEN-GEN-OCS-DWG-00011 Revision: R1

FOR TENDER PURPOSE ONLY