


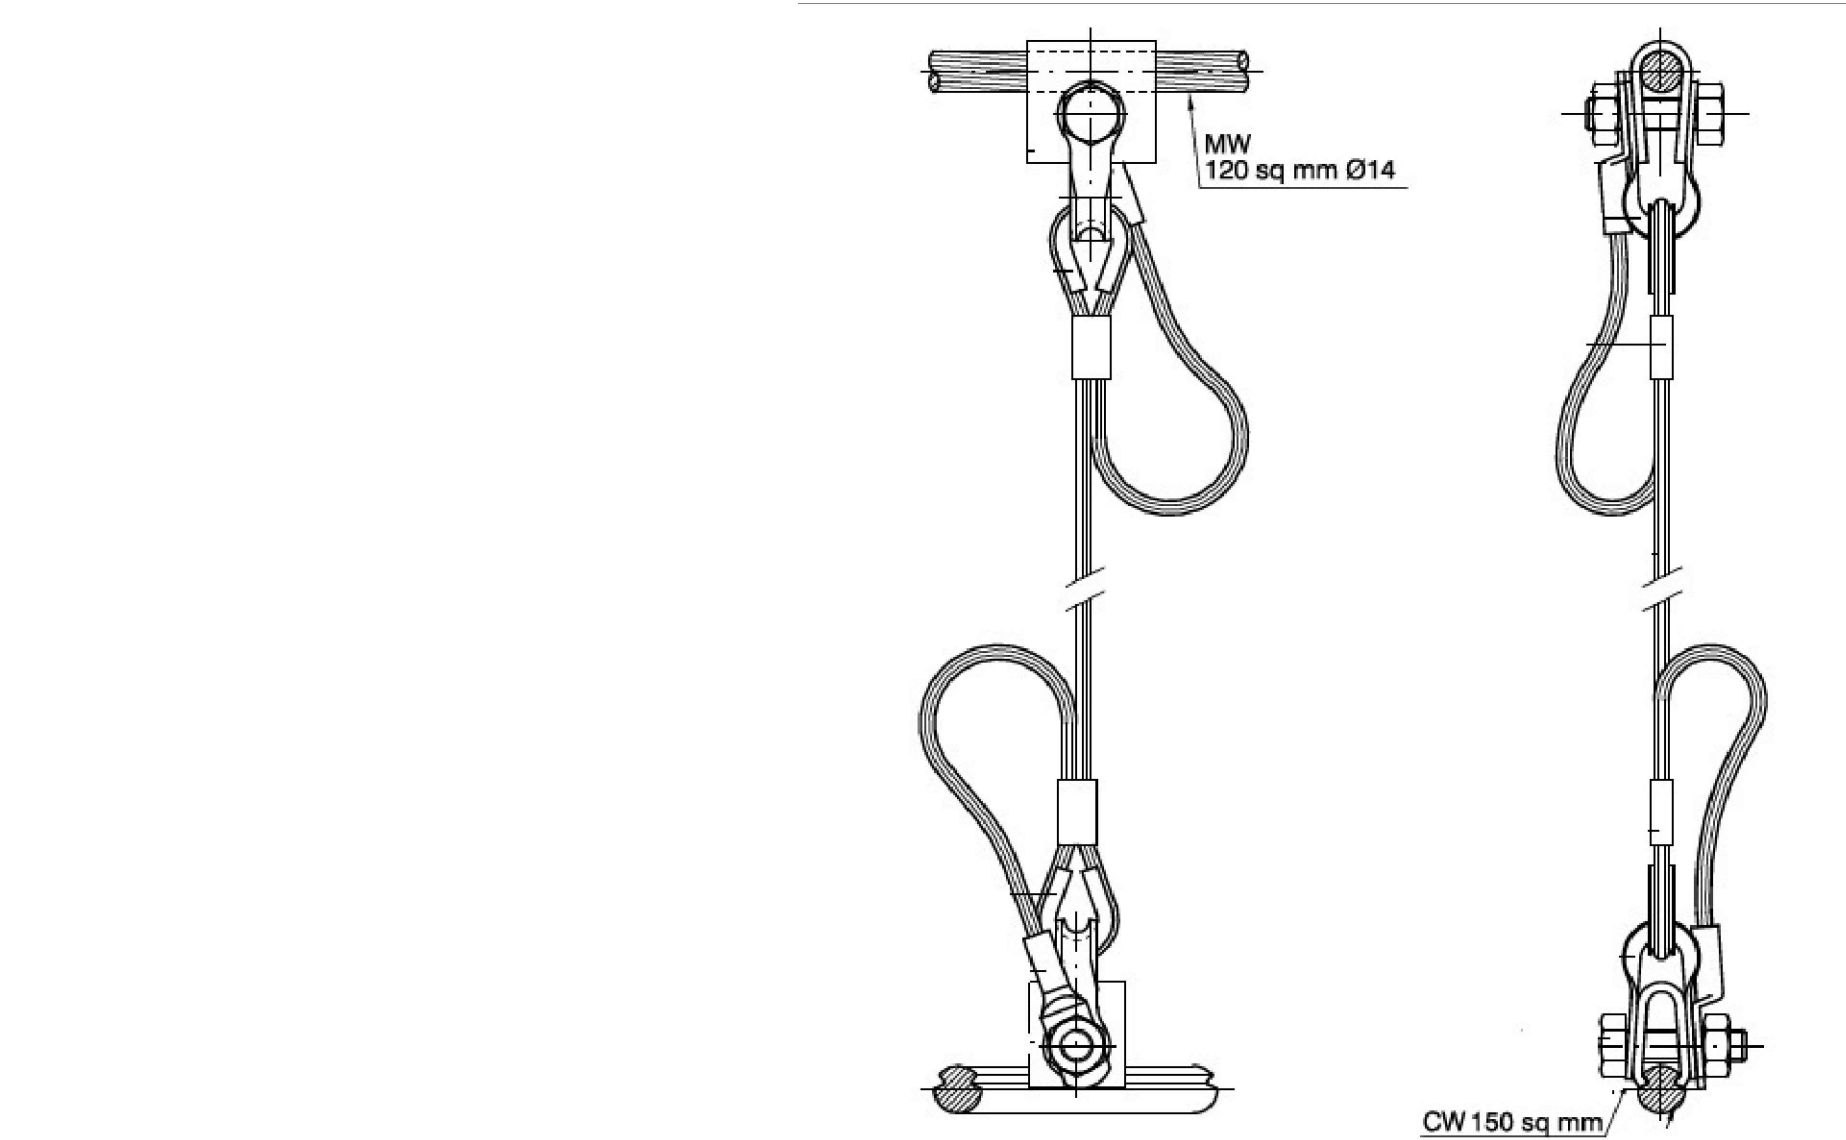

NOTE:-
1 ARRANGEMENT SHOWN IS A TYPICAL DRAWING AND FINAL DRAWING TO BE SUBMITTED BY THE CONTRACTOR AS PER APPROVED VENDOR.
2 FOR MORE DETAILS REFER TECHNICAL SPECIFICATIONS.

NOTES: 1. ALL DIMENSIONS ARE IN METER UNLESS MENTIONED OTHERWISE. 2. ALL DIMENSIONS ARE TO BE READ AND NOT TO BE MEASURED. 3. ANY DISCREPANCY IN THE DRAWING MUST BE BROUGHT TO THE NOTICE OF THE DESIGNER. 4. INTERFACE WITH OTHER DESIGN DISCIPLINE WILL BE DONE AS PER AVAILABILITY OF DETAILS.						K RIDE DM / ELE / KRIDE Sr. DGM / ELE / KRIDE AGM / ELE / KRIDE			Certified that this document has been designed and checked in accordance with GC Quality Assurance Plan. egis AECOMwsp EGIS-AECOM-WSP Senior Discipline Expert Chief Discipline Expert Project Director Certified that this document has been designed and checked in accordance with DDC Quality Assurance Plan. Detailed Design Consultant for design of Traction & Auxiliary Power Supply and Distribution for BSRP SYSTRAMVA CONSULTING (INDIA) PVT. LTD. 10th and 11th Floor, Tower-B, 12/3, Vatika Miniscapes, Mathura Road, NH2, Sector 27D, Faridabad, Haryana 121015 Drawn D. Kumar S. Bhati Checked: D. Kalyan N. Parmar Approved: R. Kapoor S. Kumar <i>[Signature]</i>			Client: K RIDE RAIL INFRASTRUCTURE DEVELOPMENT COMPANY (KARNATAKA) LIMITED Project Title: Bengaluru Suburban Rail Project (BSRP) (Detailed Design Consultant for design of Traction & Auxiliary Power Supply and Distribution for BSRP) CORRIDOR-2 & 4 Drawing Title: GENERAL ARRANGEMENT OF CURRENT CARRYING DROPPER Project Stage: Tender Drawing Paper Size: A3 Discipline: Power Supply & Traction System Date: 13/08/2024 Scale: NTS Drawing no.: KRDD01-TDR-GEN-GEN-OCS-DWG-00021 Revision: R0		
---	--	--	--	--	--	---	--	--	--	--	--	--	--	--

FOR TENDER PURPOSE ONLY