


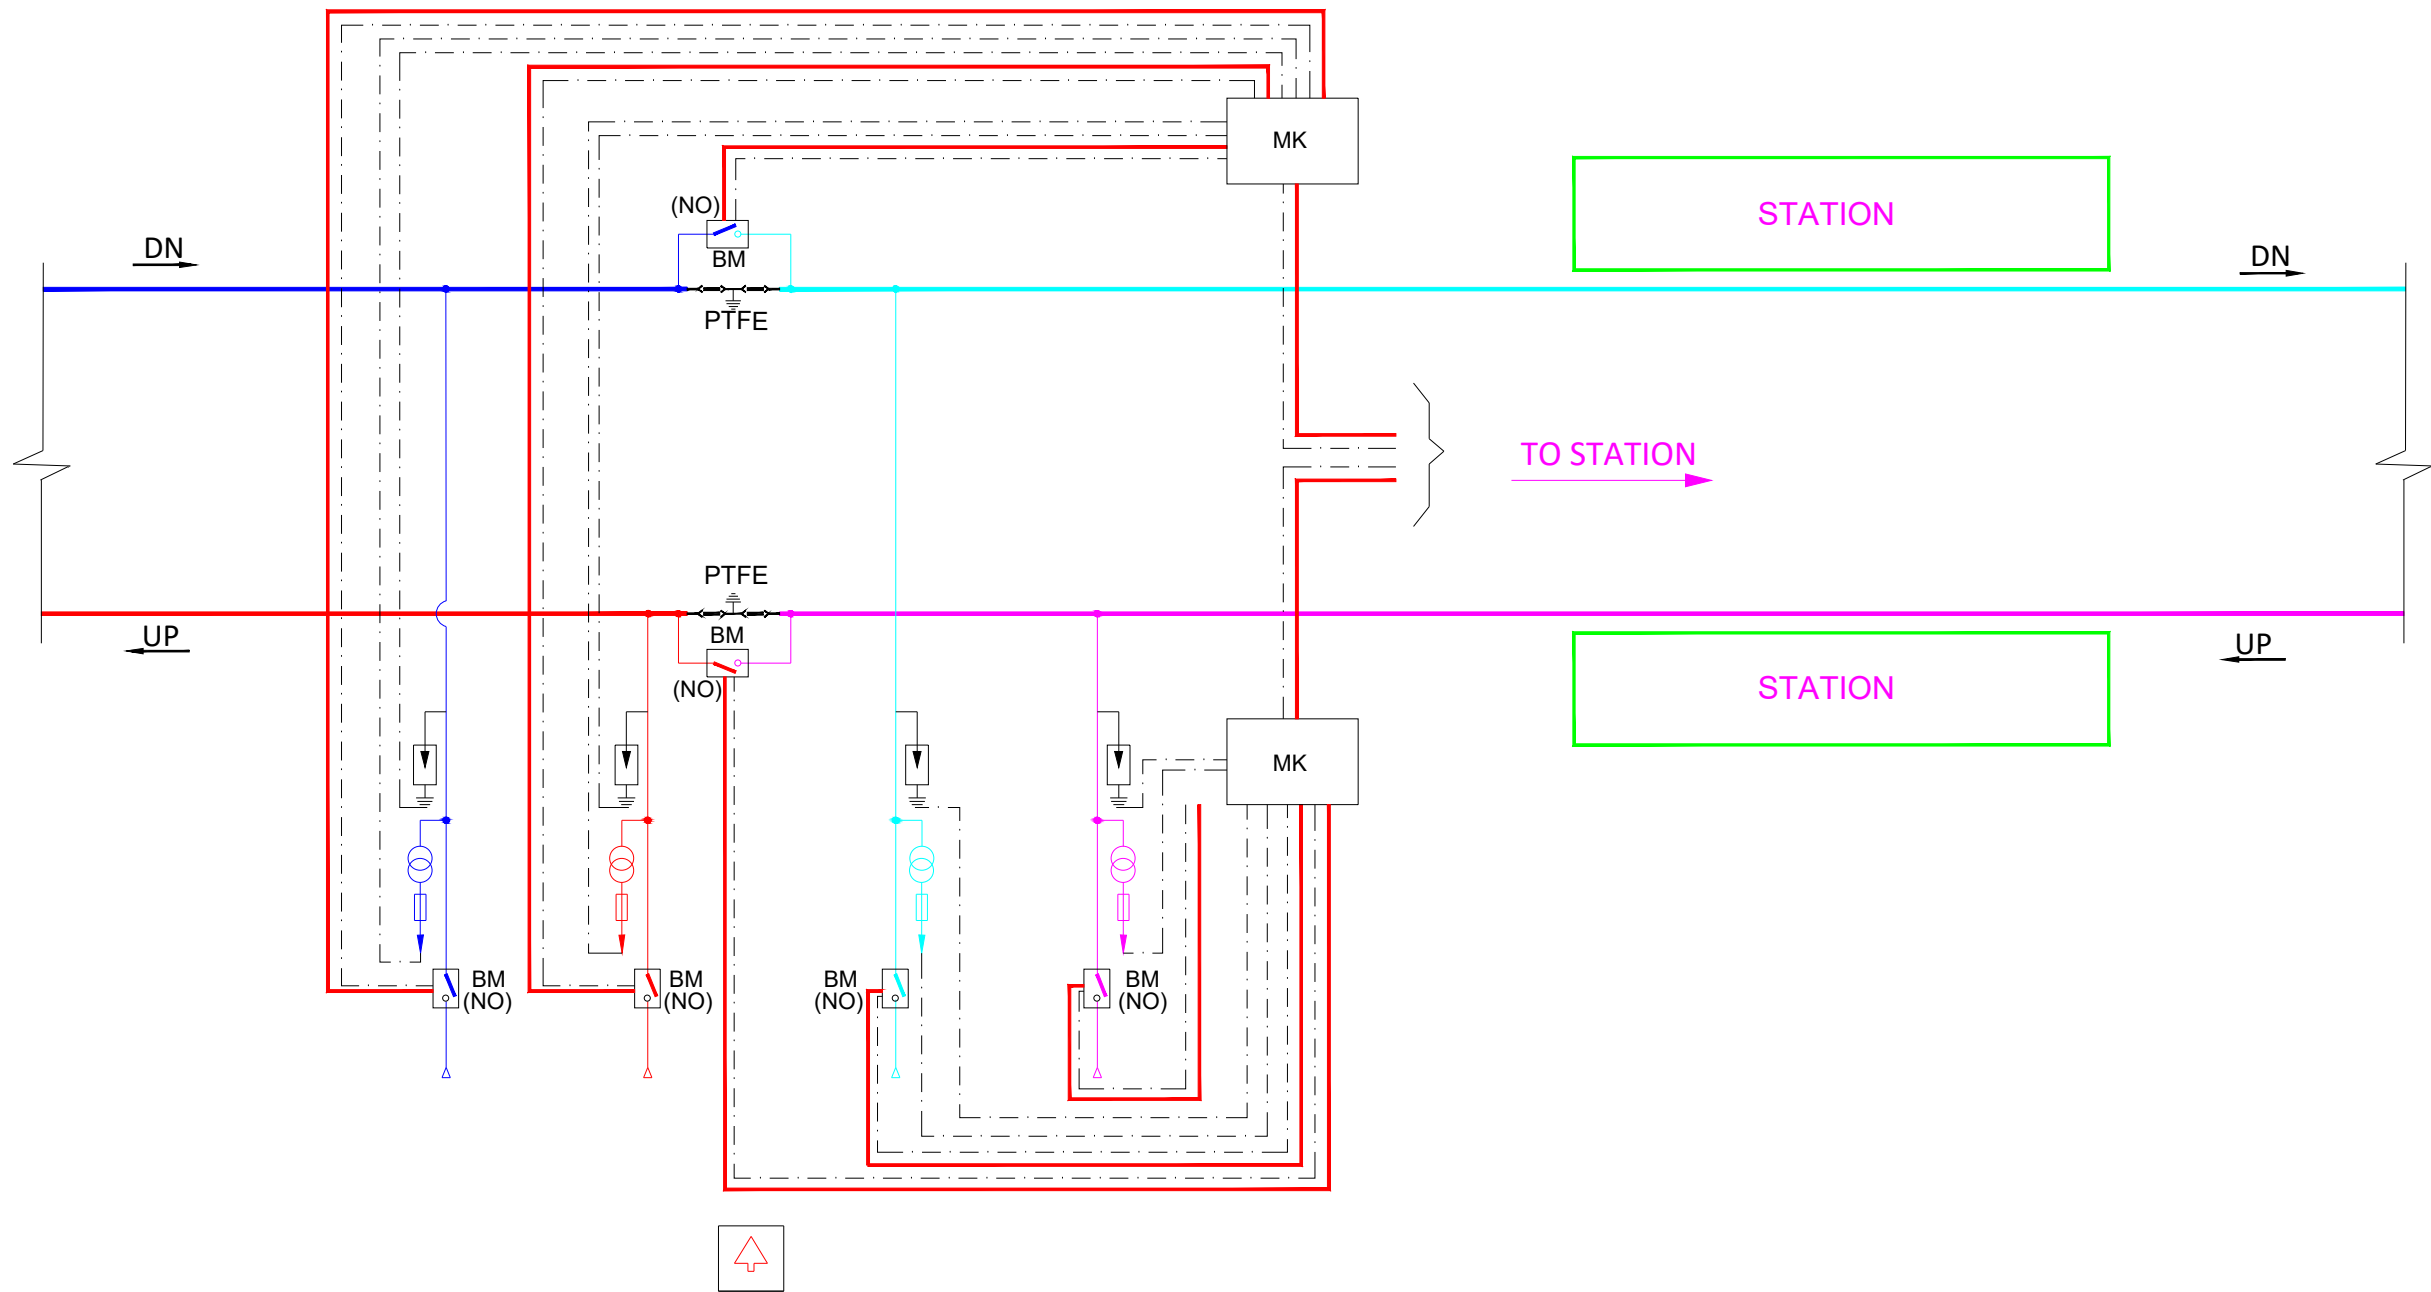


- NOTES:**
1. ALL DIMENSIONS ARE IN MM UNLESS OTHERWISE SPECIFIED.
 2. ALL DIMENSIONS ARE TO BE READ AND NOT TO BE MEASURED.
 3. THIS IS JUST TYPICAL ARRANGEMENT AND MAY CHANGE DURING DETAIL DESIGN STAGE AS PER VENDOR DRAWINGS.
 4. FROM SAFETY POINT OF VIEW, MESH FRAME SHOULD BE PROVIDED AT COUNTRY SIDE OF POTENTIAL TRANSFORMER & LIGHTNING ARRESTER.
 5. LIGHTNING ARRESTERS HAVE BEEN PROPOSED ALONG WITH POTENTIAL TRANSFORMER.
 6. ALL EQUIPMENTS WILL BE SUPPORTED ON 8200 MAST.
 7. JUMPERS CONNECTING EQUIPMENT TO OHE SHOULD HAVE SUITABLE ELECTRICAL CLEARANCES.
 8. SUITABLE CLEARANCES SHOULD BE MAINTAIN BETWEEN ALL EQUIPMENT AND SUPPORTING STRUCTURE.
 9. LENGTH OF THE ALL JUMPERS IS DIRECTLY RELATED TO THE NORMAL SET-UP TEMPERATURE OF THE PARTICULAR EQUIPMENT AND THE JUMPER LOOP MUST HAVE SUFFICIENT SLACK TO ALLOW FOR MAXIMUM DIFFERENTIAL MOVEMENT BETWEEN CATENARIES OR THE CONNECTING WIRES.
 11. TENDER DRAWINGS ARE INDICATIVE ONLY.


LEGEND		
S. No.	SYMBOLS	DESCRIPTION
1.		25KV POTENTIAL TRANSFORMER
2.		INTERRUPTER
3.		SECTION INSULATOR
4.		CONTROL CABLES
5.		LT POWER SUPPLY CABLES
6.		LIGHTNING ARRESTOR (LA)
7.		PTFE TYPE NEUTRAL SECTION

FOR TENDER PURPOSE ONLY

NOTES: 1. ALL DIMENSIONS ARE IN METER UNLESS MENTIONED OTHERWISE. 2. ALL DIMENSIONS ARE TO BE READ AND NOT TO BE MEASURED. 3. ANY DISCREPANCY IN THE DRAWING MUST BE BROUGHT TO THE NOTICE OF THE DESIGNER. 4. INTERFACE WITH OTHER DESIGN DISCIPLINE WILL BE DONE AS PER AVAILABILITY OF DETAILS.			K RIDE			Certified that this document has been designed and checked in accordance with GC Quality Assurance Plan.  EGIS-AECOM-WSP Senior Discipline Expert Chief Discipline Expert Project Director			Client:  RAIL INFRASTRUCTURE DEVELOPMENT COMPANY (KARNATAKA) LIMITED		
			DM / ELE / KRIDE			Sr. DGM / ELE / KRIDE			AGM / ELE / KRIDE		
									Project Title: Bengaluru Suburban Rail Project (BSRP) (Detailed Design Consultant for design of Traction & Auxiliary Power Supply and Distribution for BSRP)		
									Corridor-2 (Benniganahalli -Soladevanahalli)		
									Drawing Title: Project Stage:		
									FEEDING POST (FP) ELECTRICAL SCHEMATIC DIAGRAM (SHEET-1 OF 3) Tender Drawing		
									Paper Size: A3 Discipline: Power Supply & Traction System Date: 13/08/2024 Scale: NTS		
									Drawing no.: KRDD01-TDR-GEN-GEN-OCS-DWG-00023 Revision: R1		
R1	02-09-2024	Revised as per K-RIDE comments	KD	CK / NP	RK / SK						
R0	13-08-2024	FIRST SUBMISSION	DK / SB	CK / NP	RK / SK						
REV	DATE	DESCRIPTION	Originator	Checked	Approved						

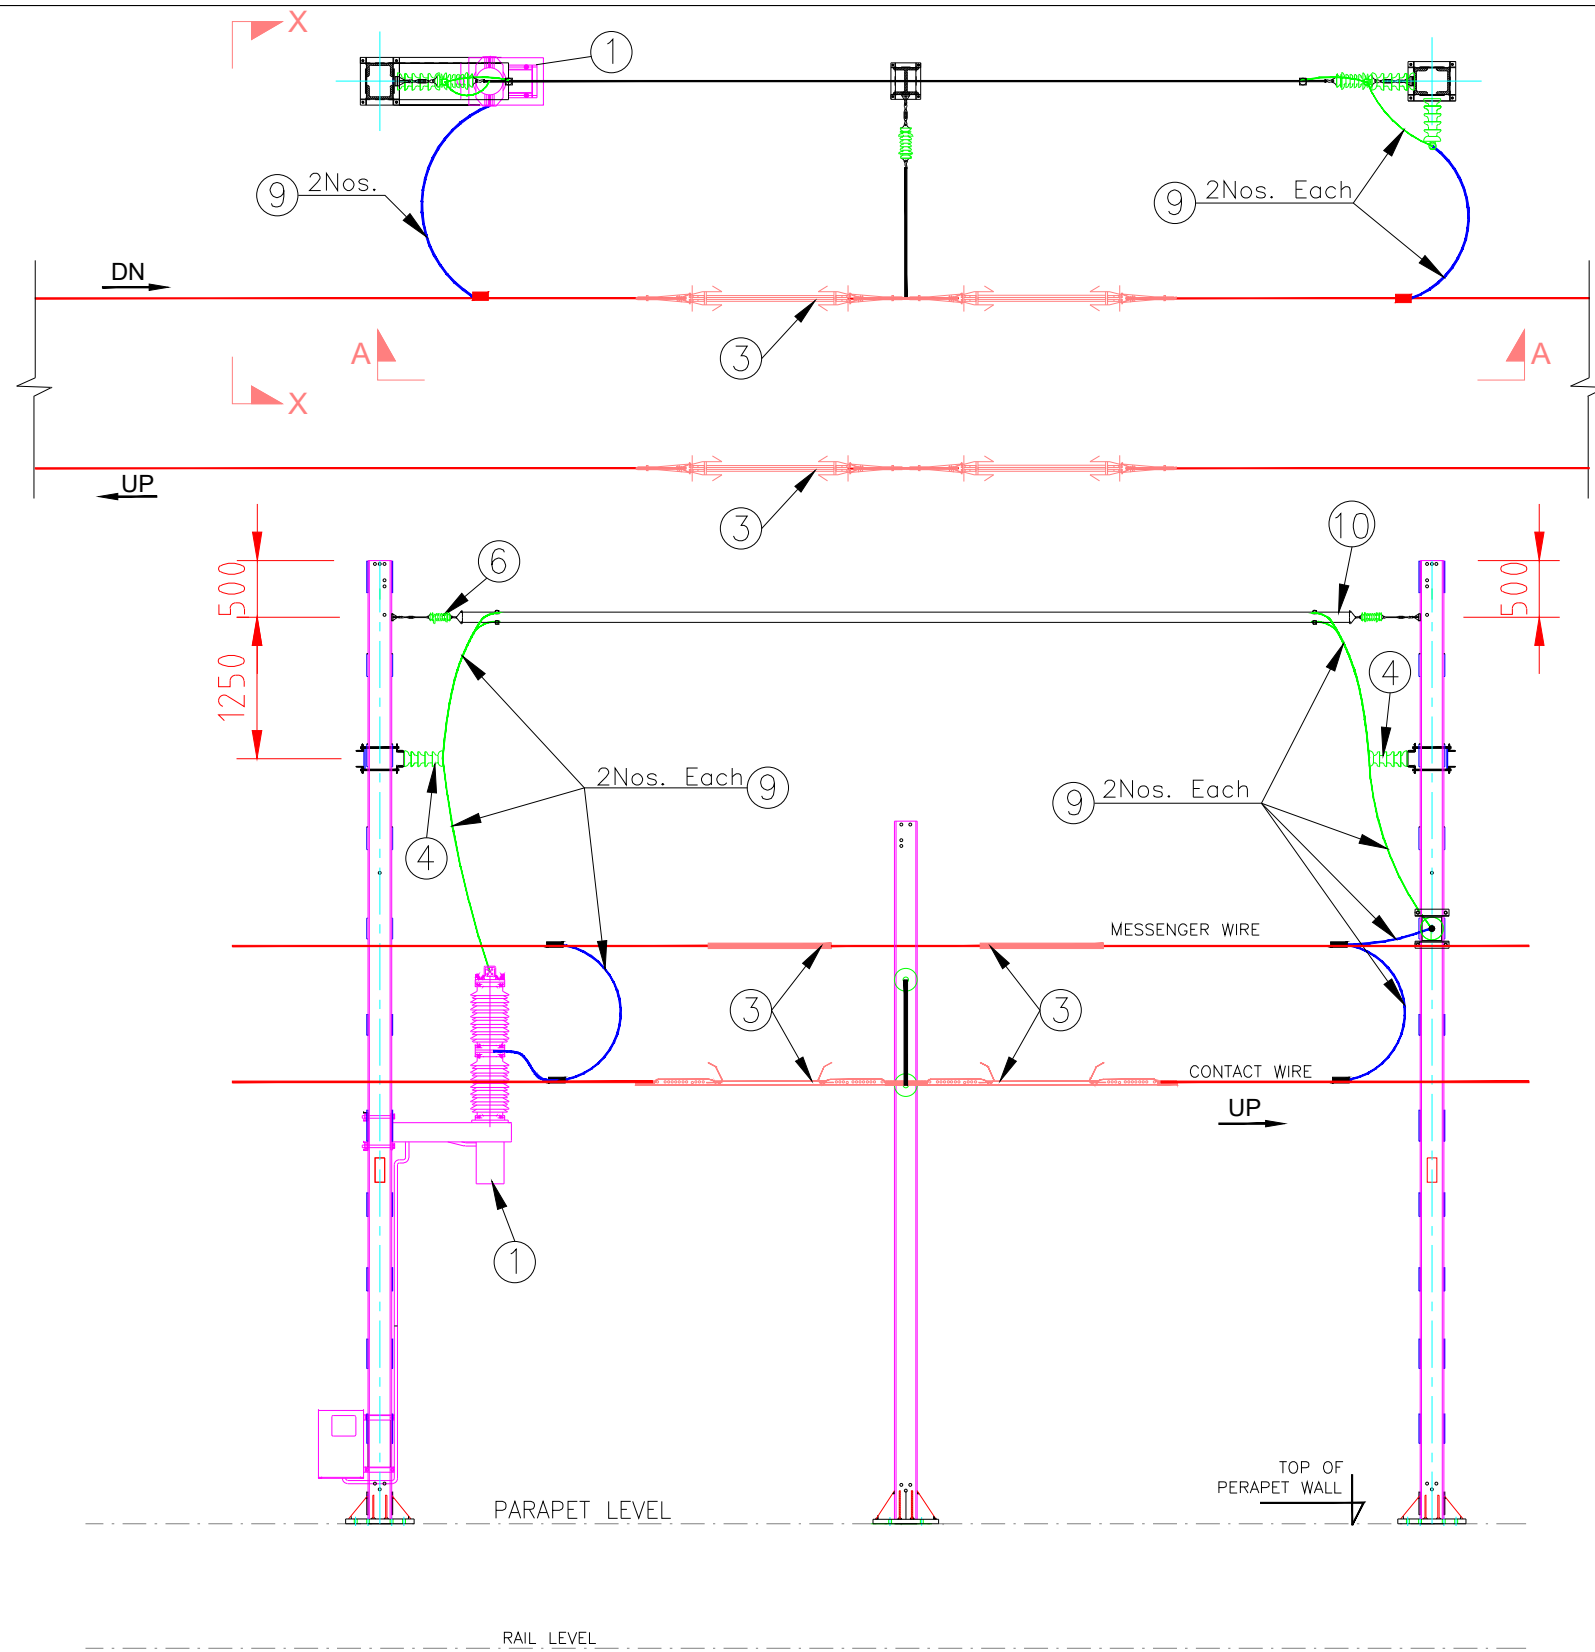

VIEW AT 'A-A'
(DN LINE)

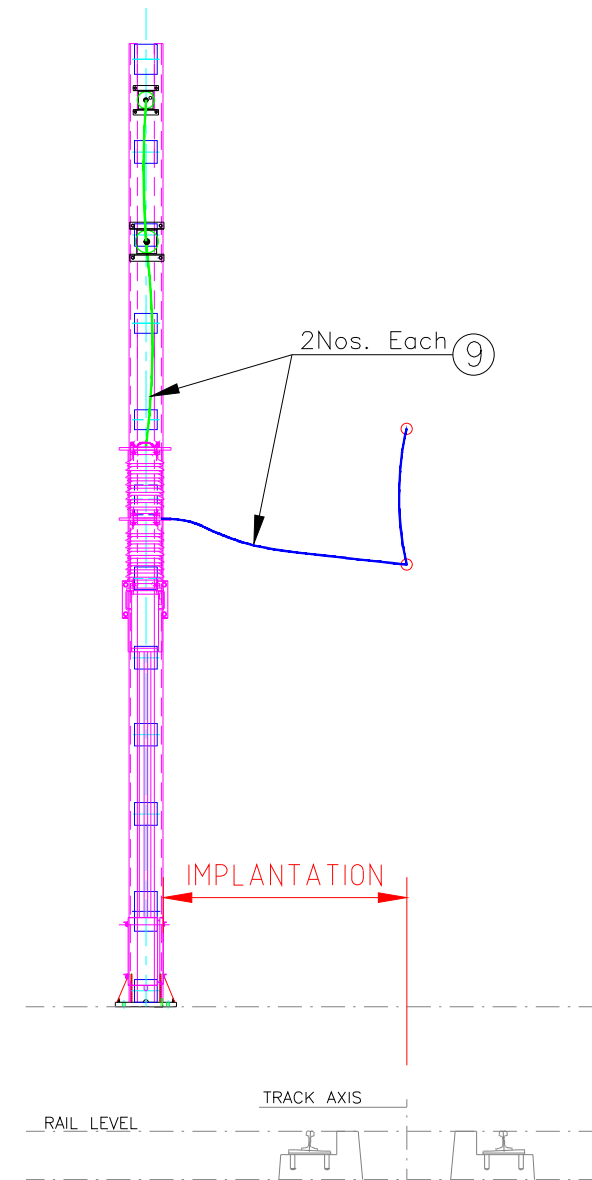

VIEW AT 'X-X'
(DN LINE)

LEGEND

- 25KV INTERRUPTER
- 25KV POTENTIAL TRANSFORMER
- PTFE NEUTRAL SECTION
- 25KV POST INSULATOR WITHOUT OUTRIGGER
- 25KV POST INSULATOR WITH OUTRIGGER
- 25KV CUT IN INSULATOR
- 25 KV LIGHTNING ARRESTER
- 75 SQ MM Cu. JUMPER WIRE
- 120 SQ MM Cu. JUMPER WIRE
- 145 SQ MM SLACK/ CROSS FEEDER
- SAFETY SCREEN PANEL
- 105 SQ MM Cu. JUMPER WIRE

LEGEND

S. No.	SYMBOLS	DESCRIPTION
1.		25kV POTENTIAL TRANSFORMER
2.		INTERRUPTER
3.		SECTION INSULATOR
4.		CONTROL CABLES
5.		LT POWER SUPPLY CABLES
6.		LIGHTNING ARRESTOR (LA)
7.		PTFE TYPE NEUTRAL SECTION

NOTES:

- ALL DIMENSIONS ARE IN METER UNLESS MENTIONED OTHERWISE.
- ALL DIMENSIONS ARE TO BE READ AND NOT TO BE MEASURED.
- ANY DISCREPANCY IN THE DRAWING MUST BE BROUGHT TO THE NOTICE OF THE DESIGNER.
- INTERFACE WITH OTHER DESIGN DISCIPLINE WILL BE DONE AS PER AVAILABILITY OF DETAILS.

REV	DATE	DESCRIPTION	Originator	Checked	Approved
R1	02-09-2024	Revised as per K-RIDE comments	KD	CK / NP	RK / SK
R0	13-08-2024	FIRST SUBMISSION	DK / SB	CK / NP	RK / SK

K RIDE

DM / ELE / KRIDE Sr. DGM / ELE / KRIDE AGM / ELE / KRIDE

Certified that this document has been designed and checked in accordance with GC Quality Assurance Plan.

egis AECOM WSP
EGIS-AECOM-WSP
Senior Discipline Expert Chief Discipline Expert Project Director

Certified that this document has been designed and checked in accordance with DDC Quality Assurance Plan.

SYSTRAM
SYSTRAM/VA CONSULTING (INDIA) PVT. LTD.
10th and 11th Floor, Tower-B, 12/3, Vatika
Mindscapes, Mathura Road, NH2, Sector 27D,
Faridabad, Haryana 121015

Drawn: D. Kumar, S. Bhati
Checked: D. Kalyan, N. Parmar
Approved: R. Kapoor, S. Kumar

Client:



**RAIL INFRASTRUCTURE
DEVELOPMENT COMPANY
(KARNATAKA) LIMITED**

Project Title: Bengaluru Suburban Rail Project (BSRP)

(Detailed Design Consultant for design of Traction & Auxiliary Power Supply and Distribution for BSRP)

Corridor-2 (Benniganahalli - Soladevanahalli)

Drawing Title: FEEDING POST(FP)

PLAN & ELEVATION VIEW - DN LINE BRIDGING

(SHEET-2 OF 3)

Paper Size: A3 Discipline: Power Supply & Traction System Date: 13/08/2024 Scale: NTS

Drawing no.: KRDD01-TDR-GEN-GEN-OCS-DWG-00023 Revision: R1

FOR TENDER PURPOSE ONLY

