


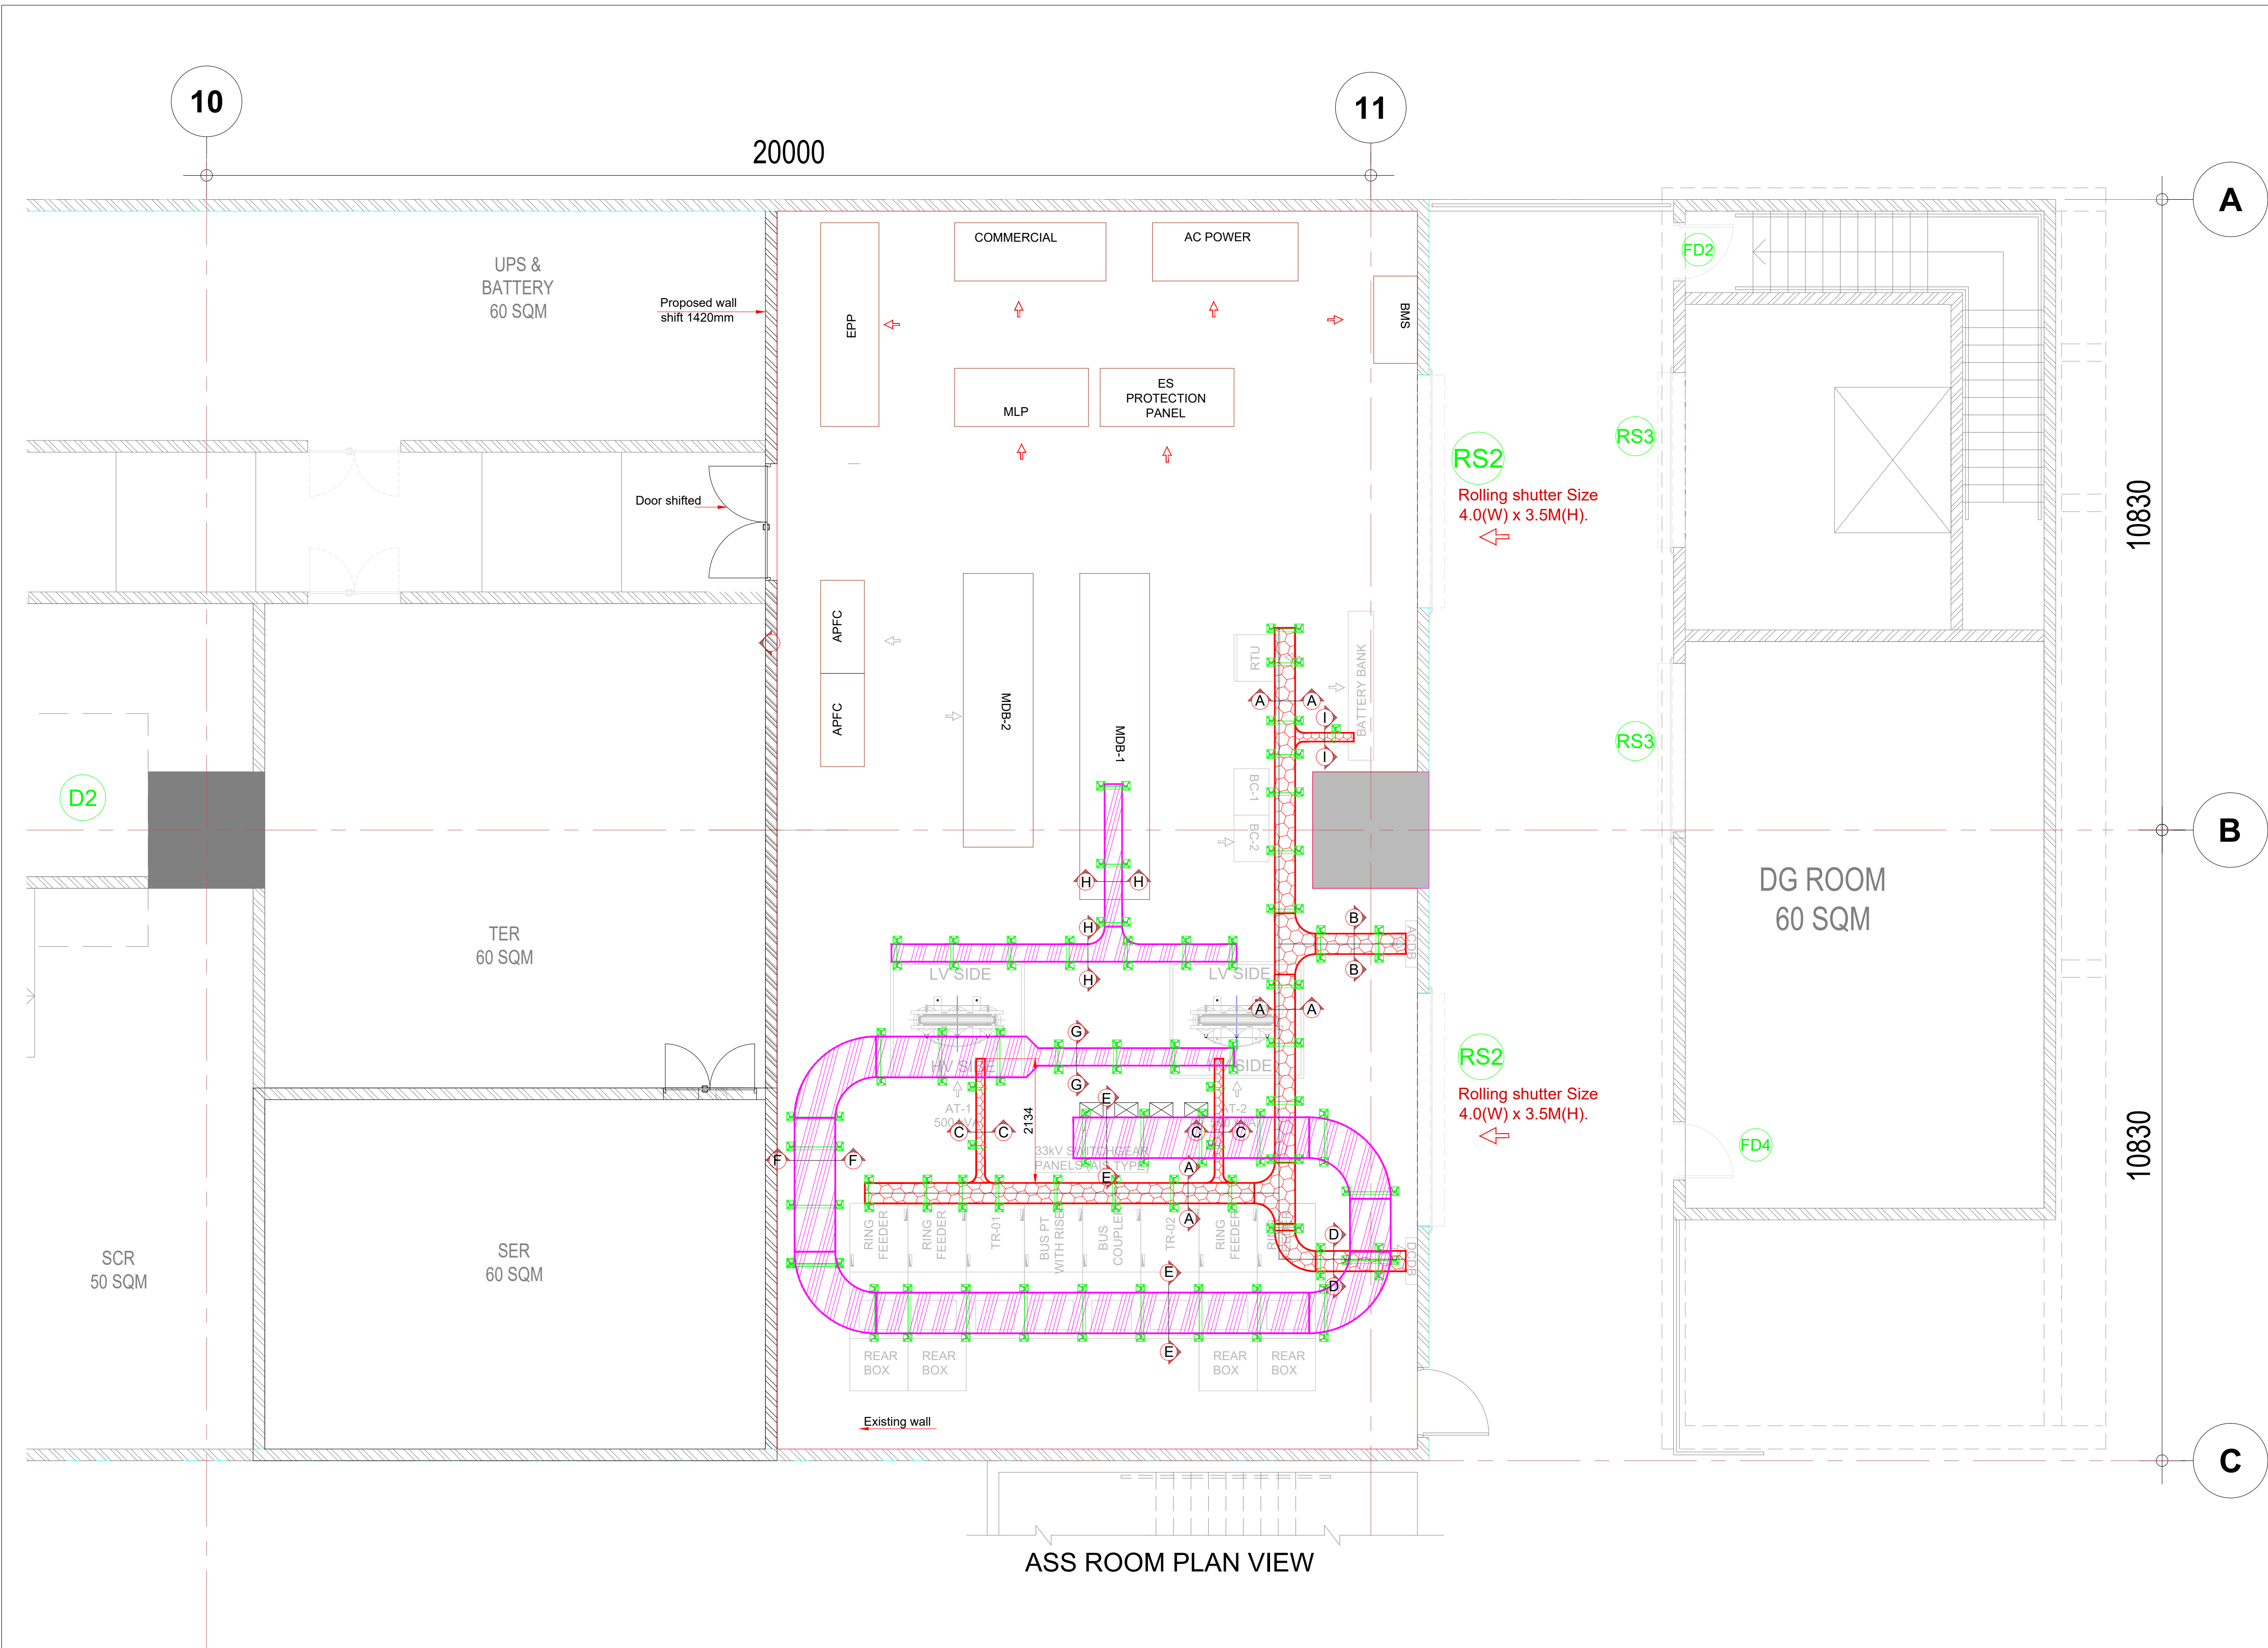

- Notes
1. ALL DIMENSIONS ARE IN MM.
 2. CABLE TRAYS AND SUPPORT SHALL BE PROPERLY EARTHED AT REGULAR INTERVALS.
 3. THIS DRAWING IS INDICATIVE AND FOR TENDER PURPOSE ONLY AND CONTRACTOR SHALL DEVELOP THE DRAWING FOR CLIENT APPROVAL.

CABLE TRAY DETAILS				
SL NO.	SYMBOL	DESCRIPTION	QTY.IN MTR.	Cable Tray Support
1.		600mm WIDE LADDER TRAY	25	23Nos
2.		300mm WIDE LADDER TRAY	13	14Nos
3.		350mm WIDE PERFORATED TRAY	24	24Nos
4.		150mm WIDE PERFORATED TRAY	6	05Nos

NOTES:

1. ALL DIMENSIONS ARE IN METER UNLESS MENTIONED OTHERWISE.
2. ALL DIMENSIONS ARE TO BE READ AND NOT TO BE MEASURED.
3. ANY DISCREPANCY IN THE DRAWING MUST BE BROUGHT TO THE NOTICE OF THE DESIGNER.
4. INTERFACE WITH OTHER DESIGN DISCIPLINE WILL BE DONE AS PER AVAILABILITY OF DETAILS.

REV	DATE	DESCRIPTION	Originator	Checked	Approved
R1	02-09-2024	SECOND SUBMISSION	K.B	V.S/R.K	SK
R0	08-08-2024	FIRST SUBMISSION	K.B	V.S/R.K	SK

K RIDE

DM / ELE / KRIDE

Sr. DGM / ELE / KRIDE

AGM / ELE / KRIDE

AECOM WSP

EGIS-AECOM-WSP

Senior Discipline Expert

Chief Discipline Expert

Project Director

SYSTRA

Certified that this document has been designed and checked in accordance with DDC Quality Assurance Plan. Detailed Design Consultant for design of Traction & Auxiliary Power Supply and Distribution for BSRP

SYSTRAMVA CONSULTING (INDIA) PVT. LTD.
10th and 11th Floor, Tower-B, 12/3, Vatika
Mindscapes, Mathura Road, NH2, Sector 27D,
Faridabad, Haryana 121015

Drawn

Checked

Approved

K. Bisht

V. Singh
R.Kannan

S. Kumar

Client:

RAIL INFRASTRUCTURE DEVELOPMENT COMPANY (KARNATAKA) LIMITED

Project Title: Bengaluru Suburban Rail Project (BSRP)
(Detailed Design Consultant for design of Traction & Auxiliary Power Supply and Distribution for BSRP)

Corridor-2 (Benniganahalli - Chikkabanavara)

Project Stage:

Tender Drawing

Drawing Title:

TYPICAL CABLE TRAY LAYOUT DRAWING FOR ASS STATIONS (Sh: 1 of 2)

Paper Size: A1

Discipline:

Date: 08/08/2024


Scale: TS/NTS

Revision:


R1

Drawing no.:


KRDD01-TDR-GEN-GEN-TPS-DWG-00030

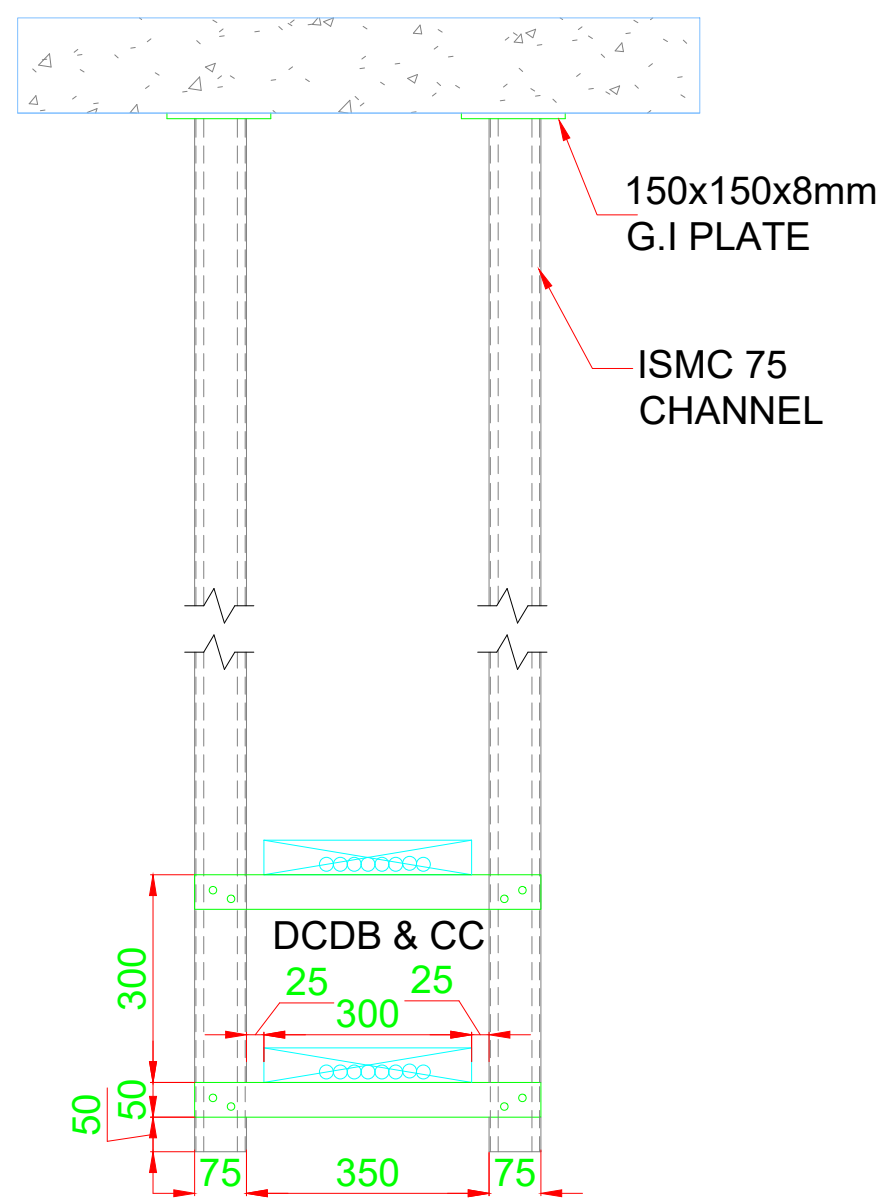


SECTION A-A

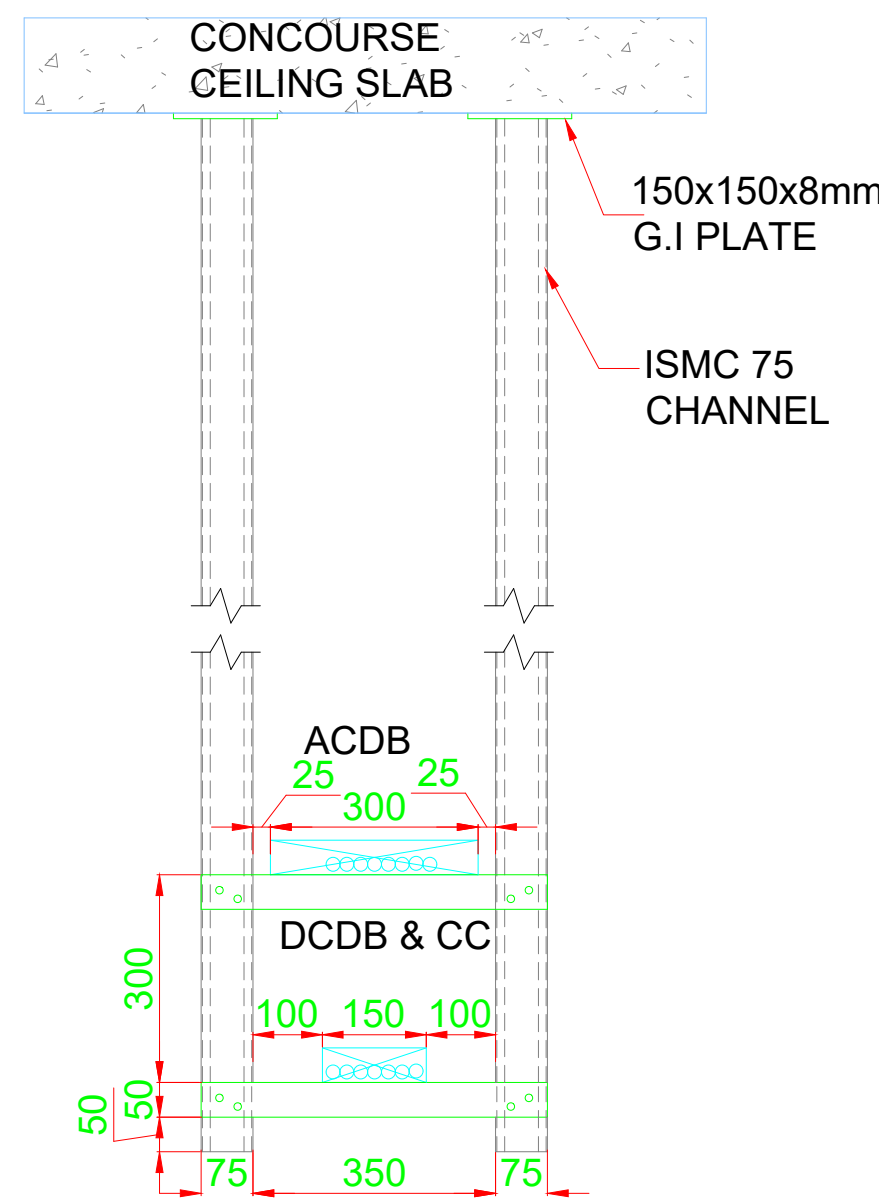


SECTION B-B

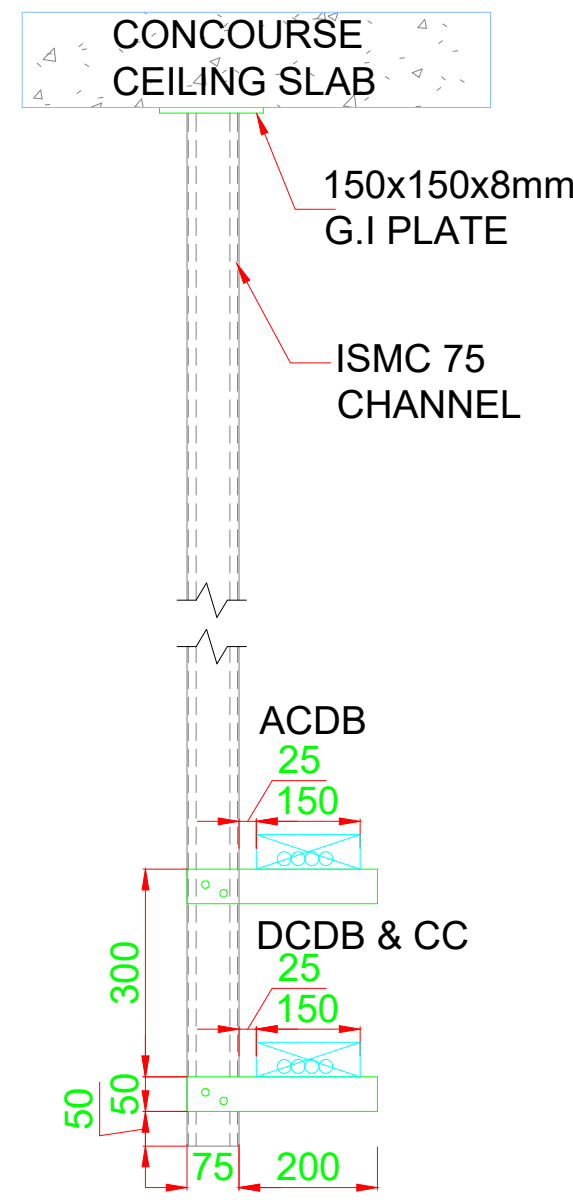


SECTION C-C

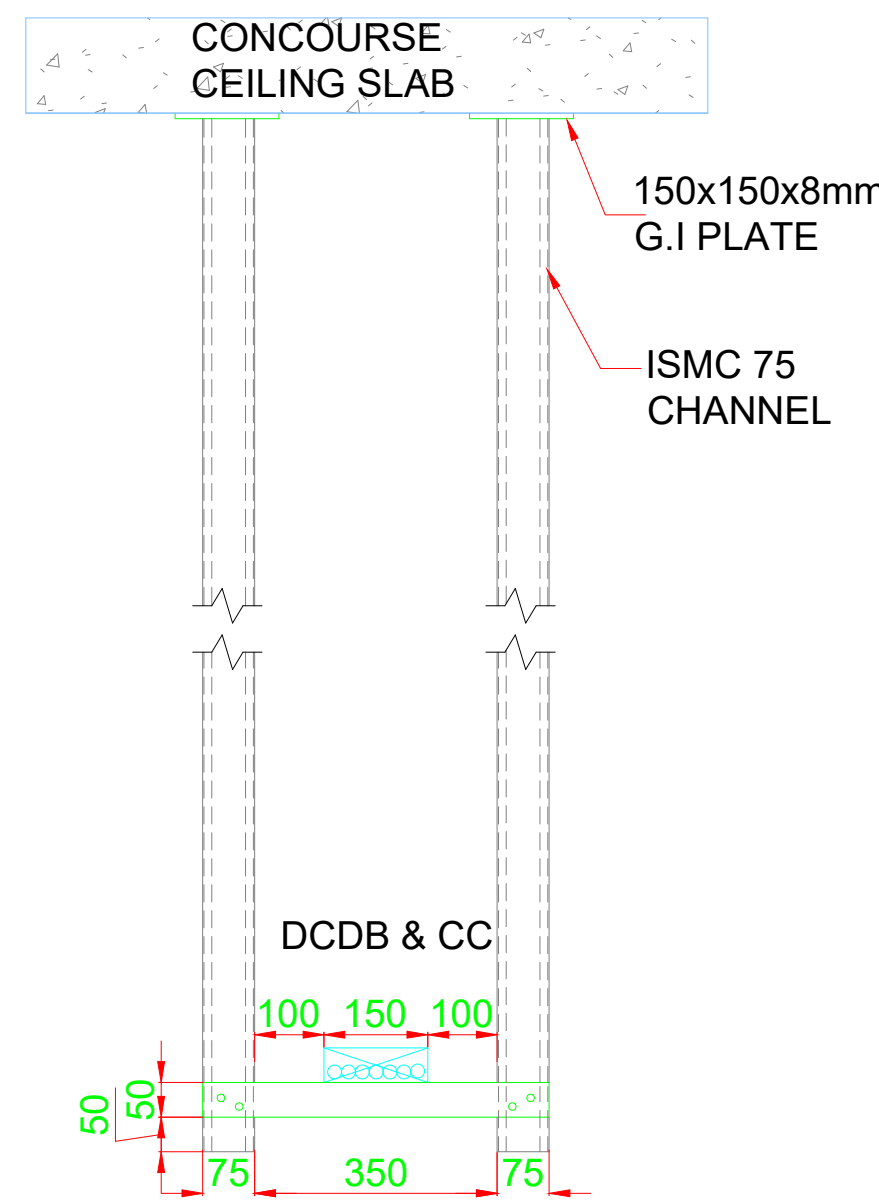


SECTION D-D

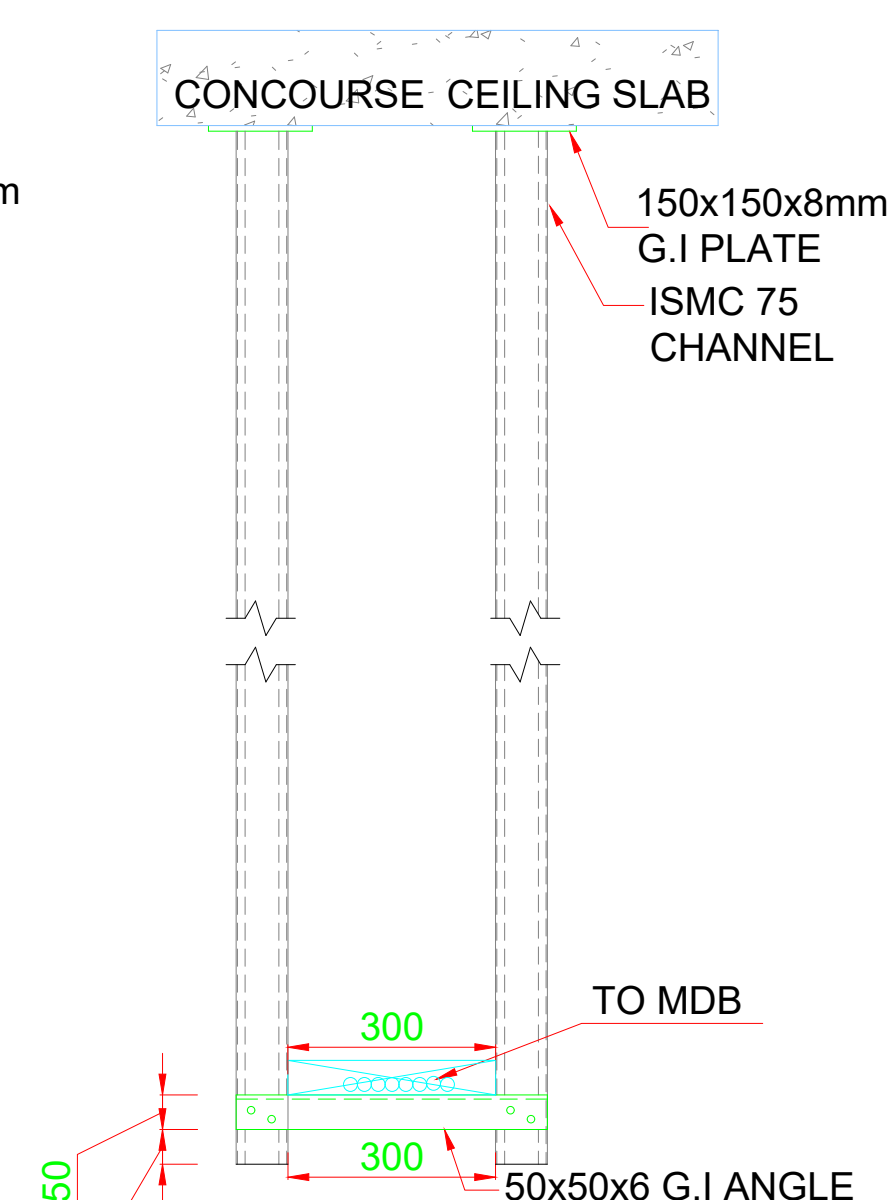


SECTION H-H

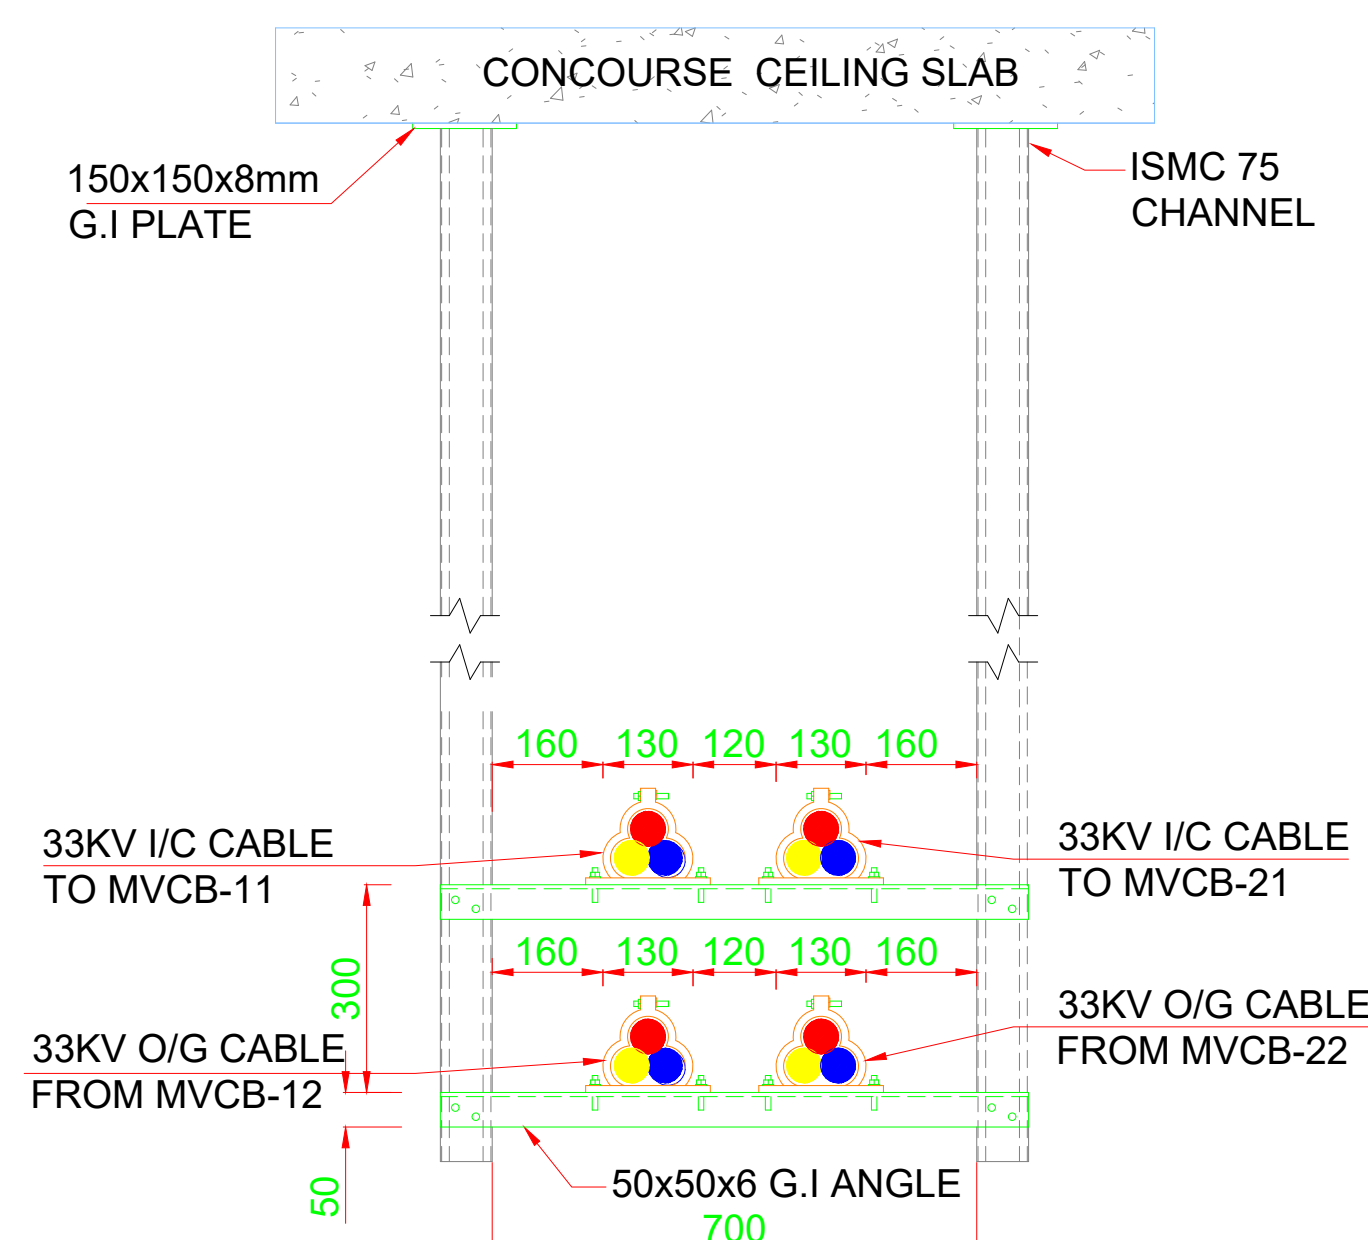


SECTION E-E

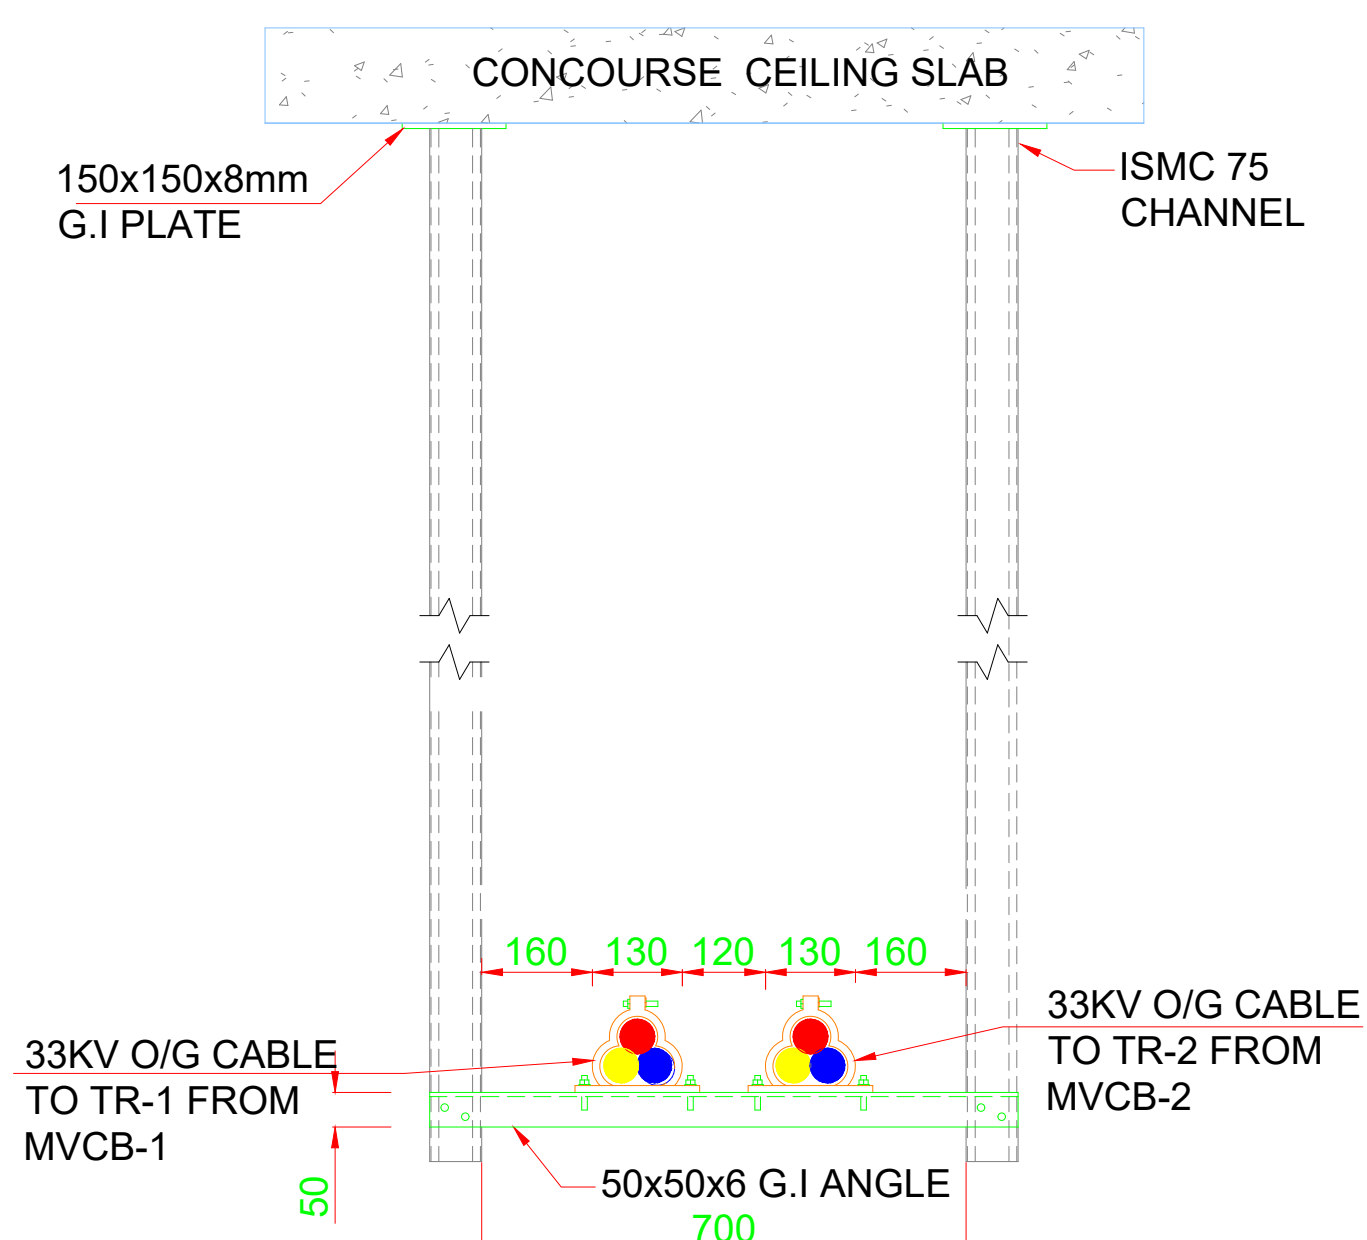

SECTION F-F

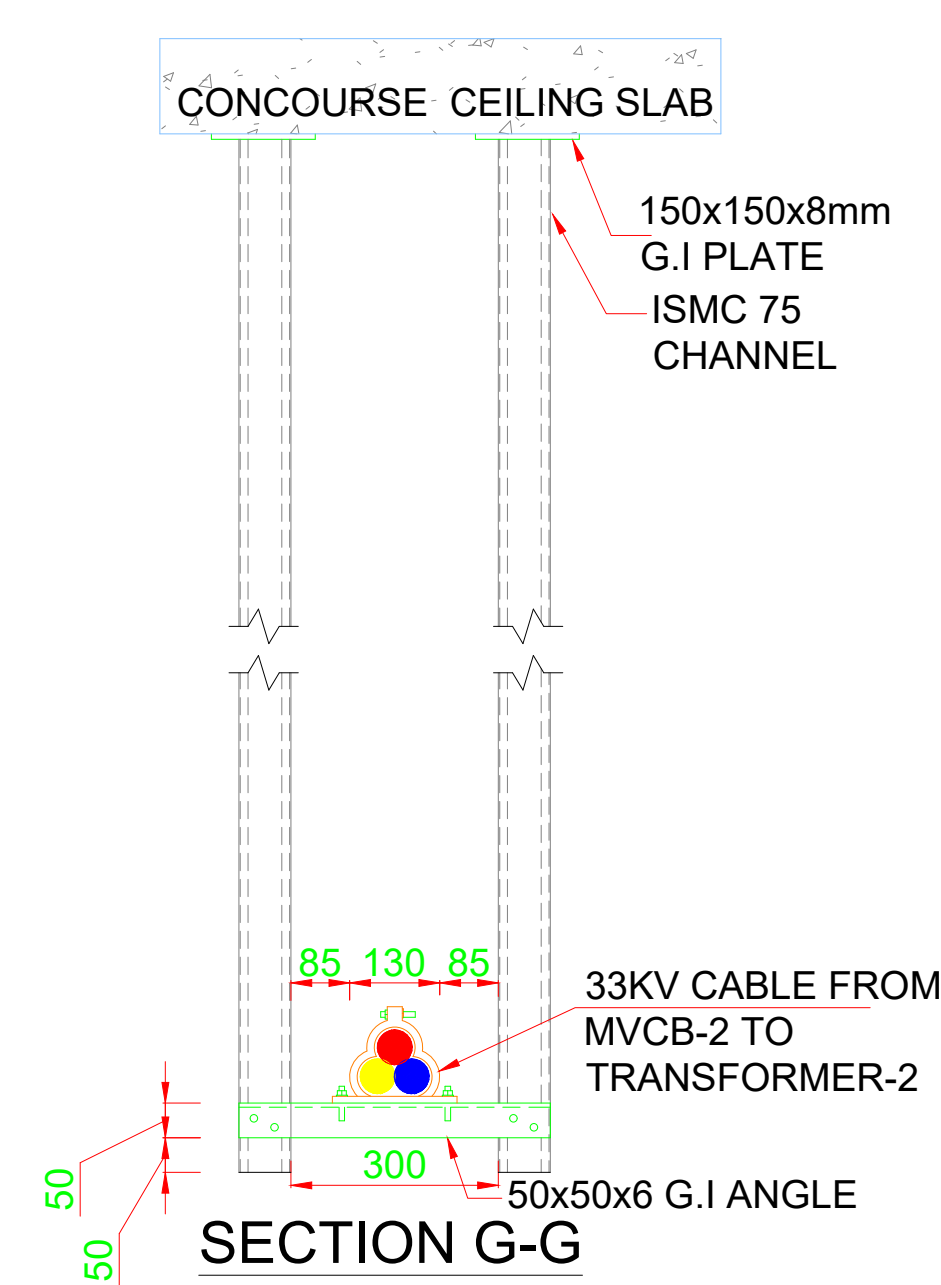

SECTION G-G

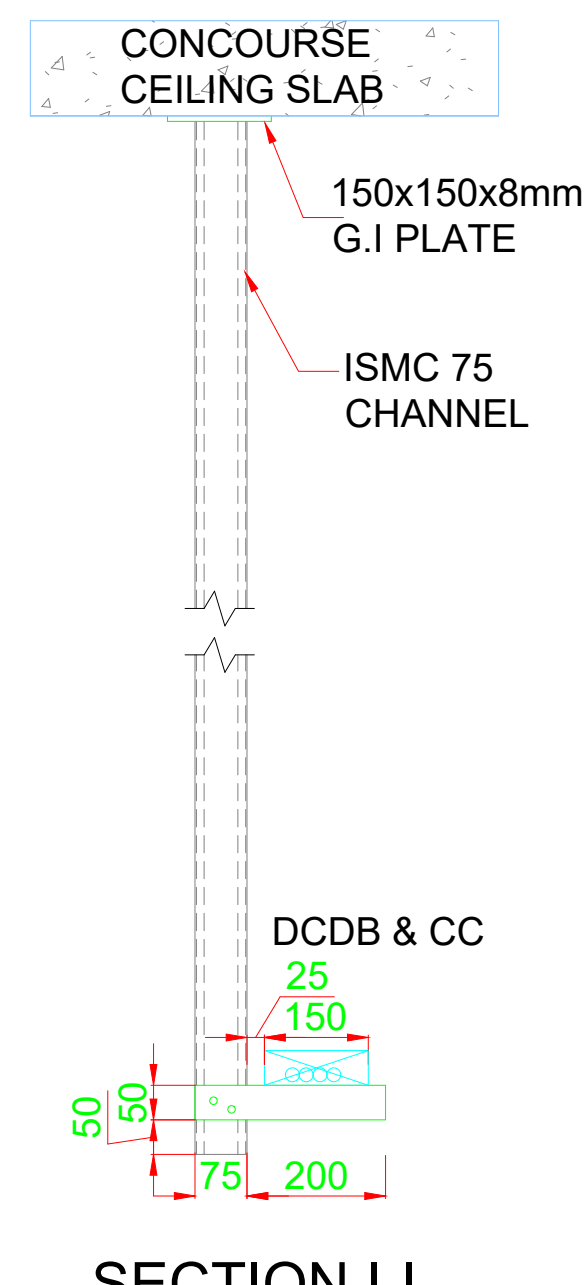

SECTION I-I

NOTES:

1. ALL DIMENSIONS ARE IN METER UNLESS MENTIONED OTHERWISE.
2. ALL DIMENSIONS ARE TO BE READ AND NOT TO BE MEASURED.
3. ANY DISCREPANCY IN THE DRAWING MUST BE BROUGHT TO THE NOTICE OF THE DESIGNER.
4. INTERFACE WITH OTHER DESIGN DISCIPLINE WILL BE DONE AS PER AVAILABILITY OF DETAILS.

REV	DATE	DESCRIPTION	Originator	Checked	Approved
R1	02-09-2024	SECOND SUBMISSION	K.B	V.S/R.K	SK
R0	08-08-2024	FIRST SUBMISSION	K.B	V.S/R.K	SK

K RIDE

DM / ELE / KRIDE Sr. DGM / ELE / KRIDE AGM / ELE / KRIDE

Certified that this document has been designed and checked in accordance with GC Quality Assurance Plan.

Senior Discipline Expert Chief Discipline Expert Project Director

Certified that this document has been designed and checked in accordance with DDC Quality Assurance Plan.

SYSTRAM/VA CONSULTING (INDIA) PVT. LTD. 10th and 11th Floor, Tower-B, 12/3, Vatika Mindspace, Mathura Road, NH2, Sector 27D, Faridabad, Haryana 121015

Drawn: K. Bhaht Checked: V. Singh, R. Kannan Approved: S. Kumar

FOR TENDER PURPOSE ONLY

Client:



RAIL INFRASTRUCTURE DEVELOPMENT COMPANY (KARNATAKA) LIMITED

Project Title: Bengaluru Suburban Rail Project (BSRP) (Detailed Design Consultant for design of Traction & Auxiliary Power Supply and Distribution for BSRP)

Corridor-2 (Benniganahalli - Chikkabanavara)

Drawing Title: TYPICAL CABLE TRAY LAYOUT DRAWING FOR ASS STATIONS (Sh: 2 of 2) Project Stage: Tender Drawing

Paper Size: A1 Discipline: Date: 08/08/2024 Scale: TS/NTS Revision: R1 Drawing no.: KRDD01-TDR-GEN-GEN-TPS-DWG-00030