


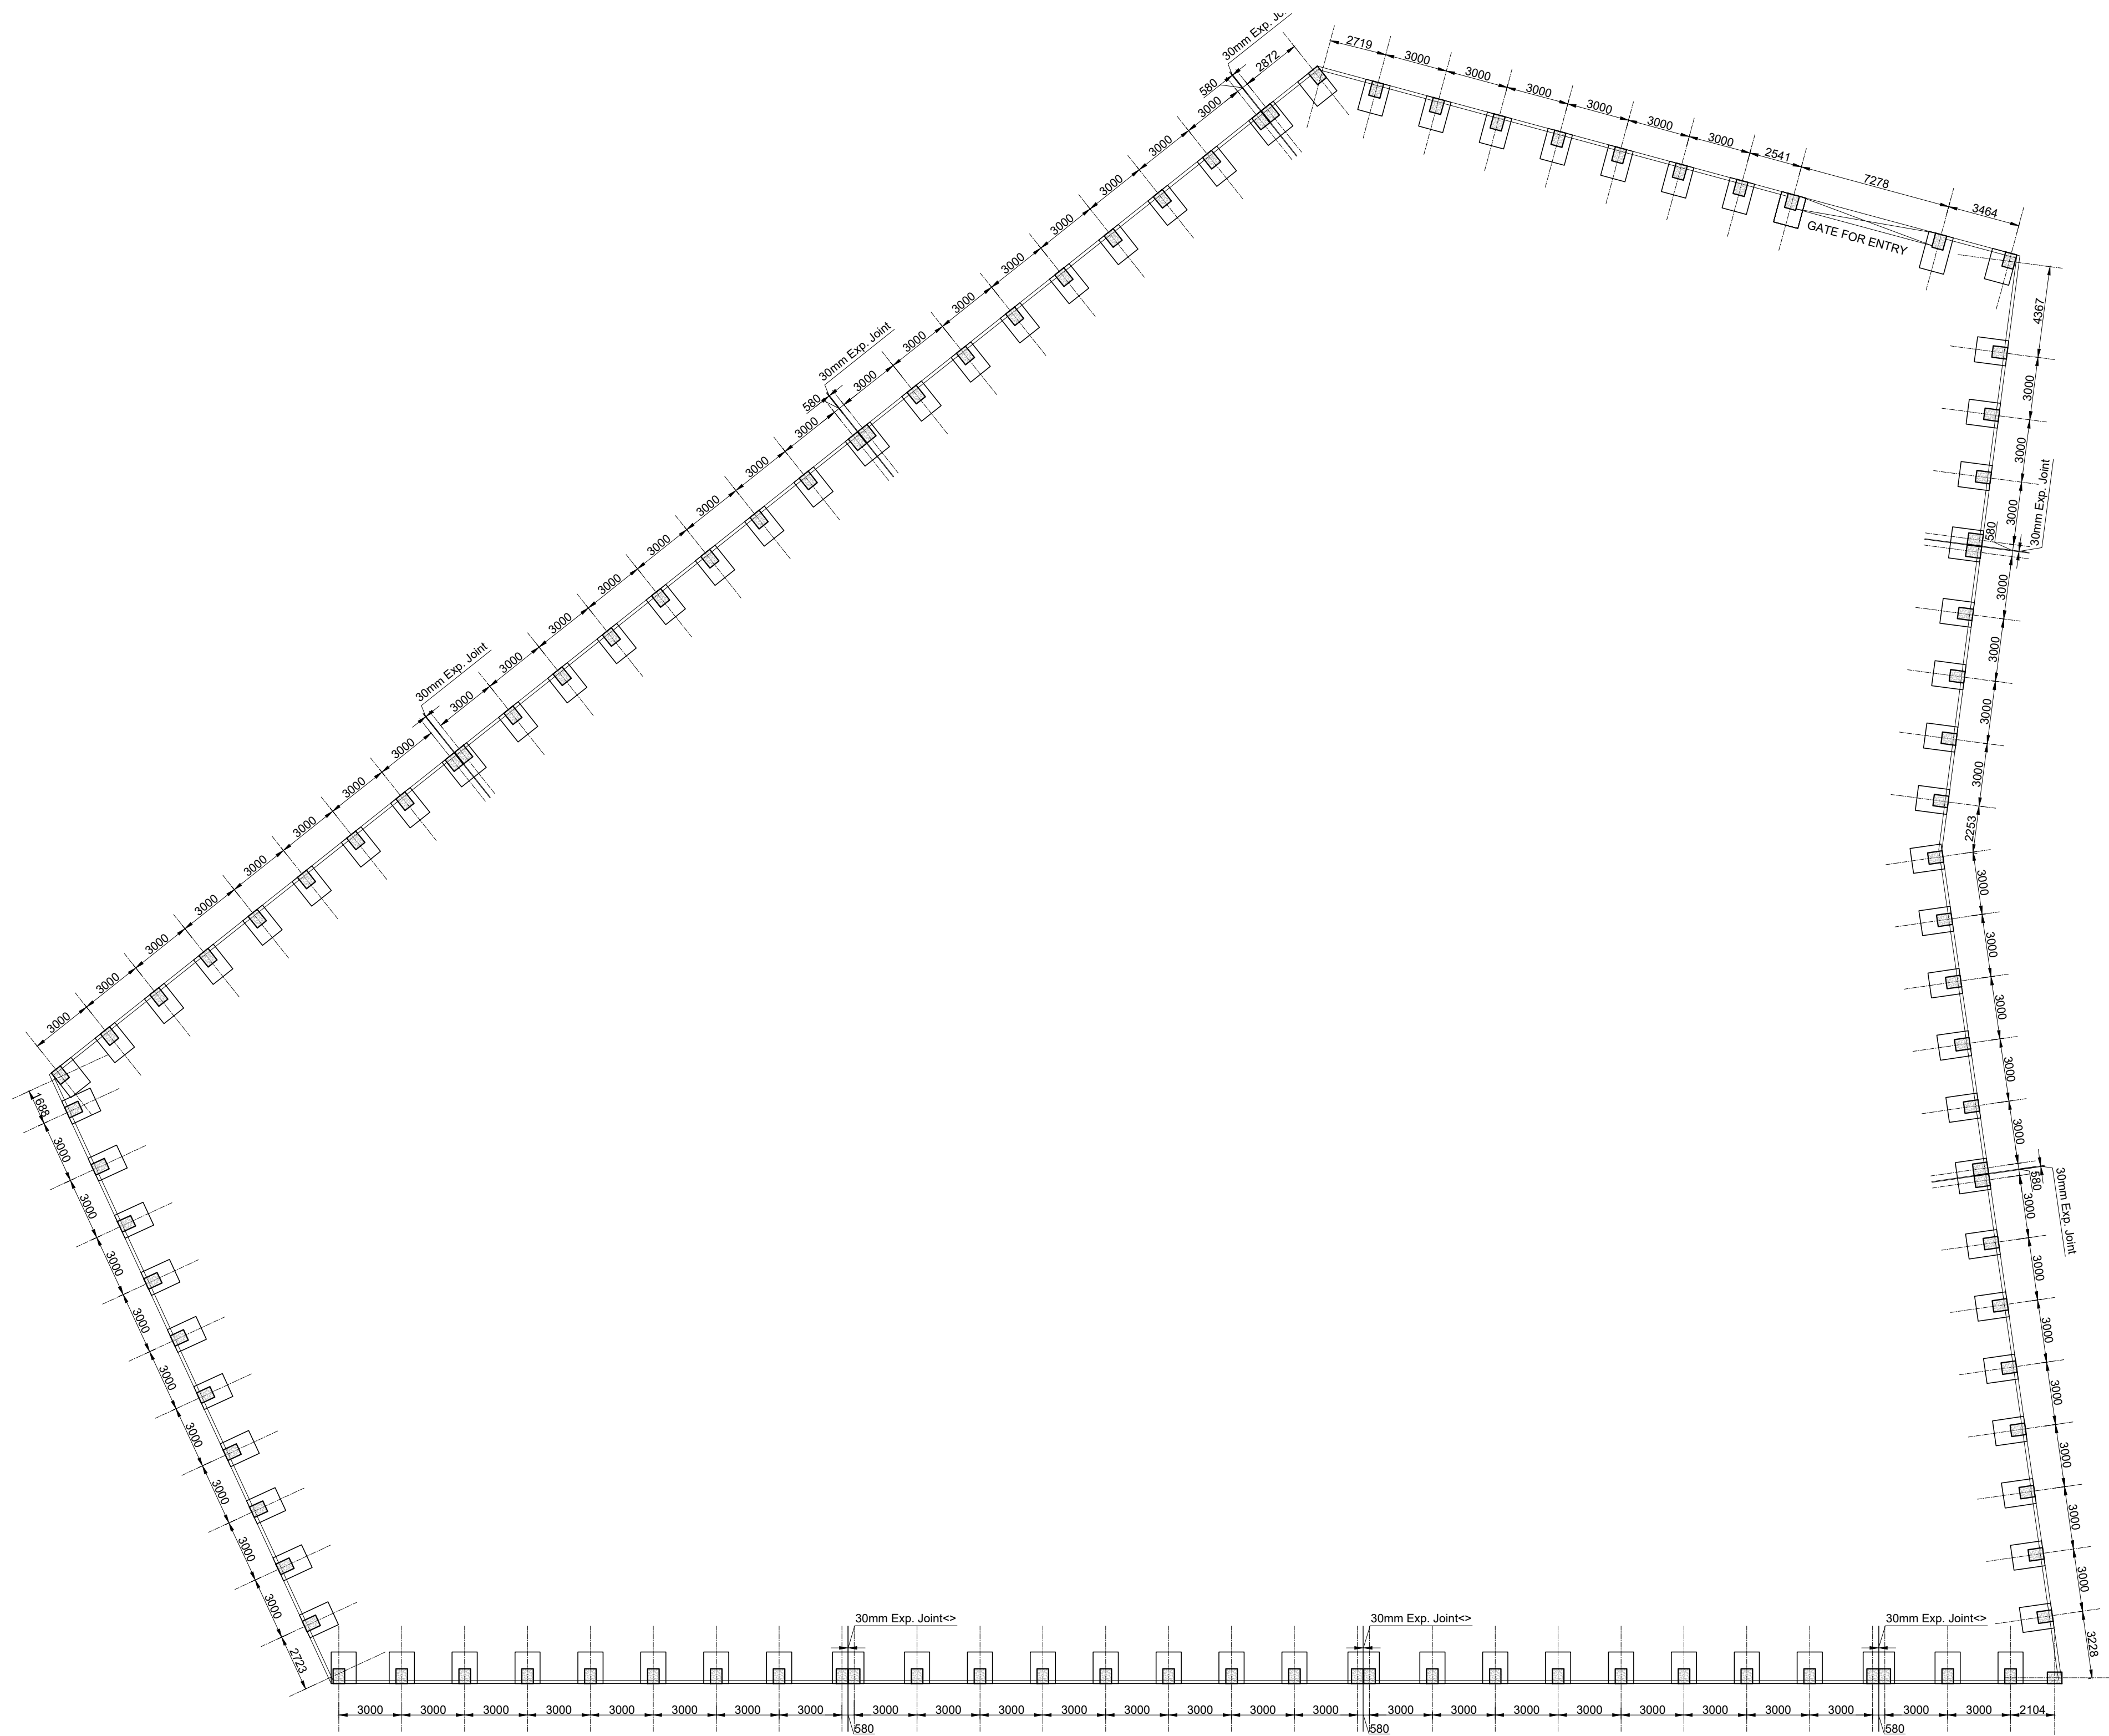






BOUNDARY WALL LAYOUT PLAN
SCALE - 1:200

- NOTES:-**
1. ALL DIMENSION ARE IN MM AND LEVELS ARE IN METER UNLESS OTHERWISE SPECIFIED.
 2. DRAWING SHALL BE READ & NOT MEASURED.
 3. DRAWING IS INDICATIVE.
 4. DIMENSION SHOWN IN THE DRAWING ARE INDICATIVE. ACTUAL DIMENSIONS TO BE DEVELOPED BY THE CONTRACTOR BASED ON THE EQUIPMENT REQUIRMENTS.

- LEGEND:-**
- F.G.L. : FINISH GROUND LEVEL.
 - F.F.L. : FLOOR FINISH LEVEL.
 - T.O.C. : TOP OF CONCRETE.
 - TYP. : TYPICAL.
 - THK : THICKNESS.

FOR TENDER PURPOSE ONLY

						K RIDE			Certified that this document has been designed and checked in accordance with GC Quality Assurance Plan.			Client:  RAIL INFRASTRUCTURE DEVELOPMENT COMPANY (KARNATAKA) LIMITED	
									 EGIS-AECOM-WSP				
						DM / ELE / KRIDE	Sr. DGM / ELE / KRIDE	AGM / ELE / KRIDE	Senior Discipline Expert	Chief Discipline Expert	Project Director	Project Title: Bengaluru Suburban Rail Project (BSRP) (Detailed Design Consultant for design of Traction & Auxiliary Power Supply and Distribution for BSRP)	
						 SYSTRAMVA CONSULTING (INDIA) PVT. LTD. 10th and 11th Floor, Tower-B, 12/3, Vatika Mindspace, Mathura Road, NH2, Sector 27D, Faridabad, Haryana 121015			Certified that this document has been designed and checked in accordance with DDC Quality Assurance Plan. Detailed Design Consultant for design of Traction & Auxiliary Power Supply and Distribution for BSRP			Corridor-2 (Benniganahalli -Chikkabanavara)	
									LAYOUT PLAN OF BOUNDARY WALL			Project Stage:	
									Tender Drawing			Drawing Title:	
									Drawn			Checked:	
									Approved:			Paper Size: A1	
									Discipline:			Date:	
									Drawing no.:			Scale: 1:200	
									Revision:			Revision: R0	
R0	08-08-2024	FIRST SUBMISSION				KRDD01-TDR-GEN-GEN-TPS-DWG-00106							
REV	DATE	DESCRIPTION	Originator	Checked	Approved								

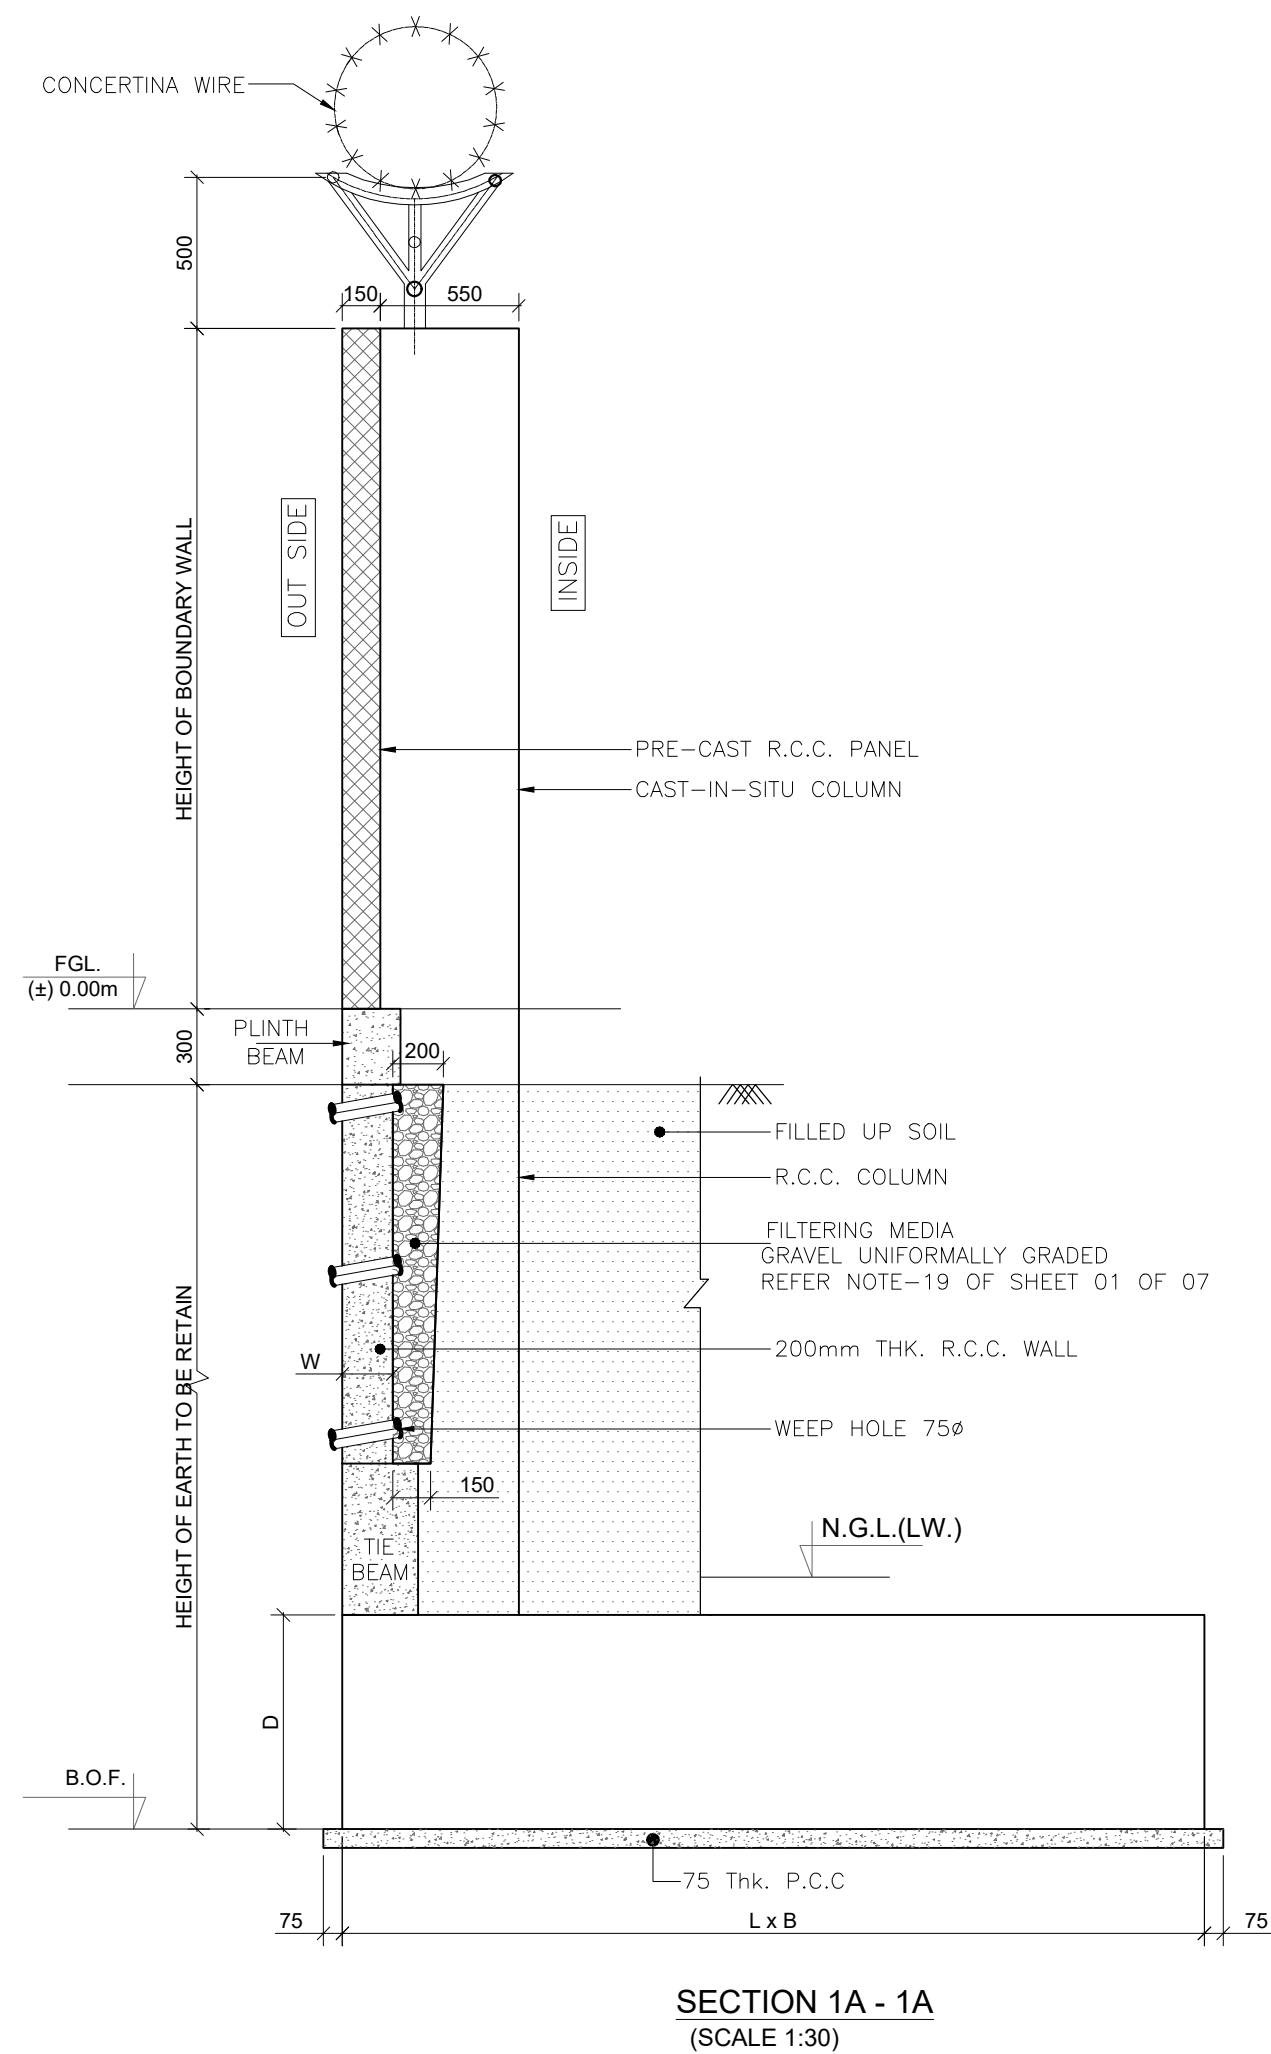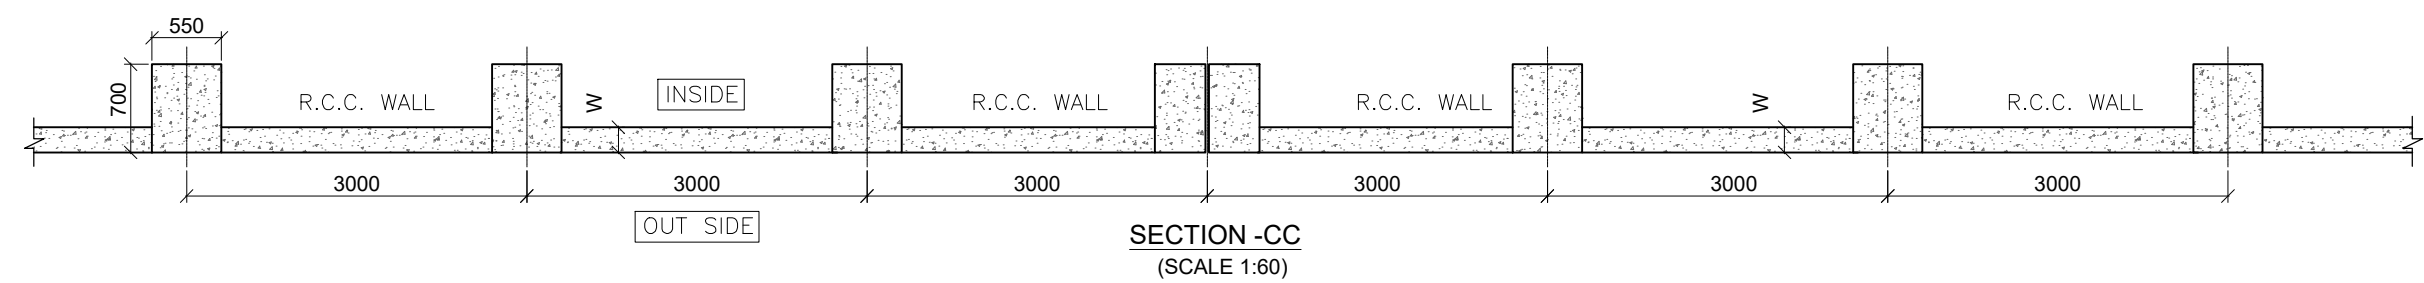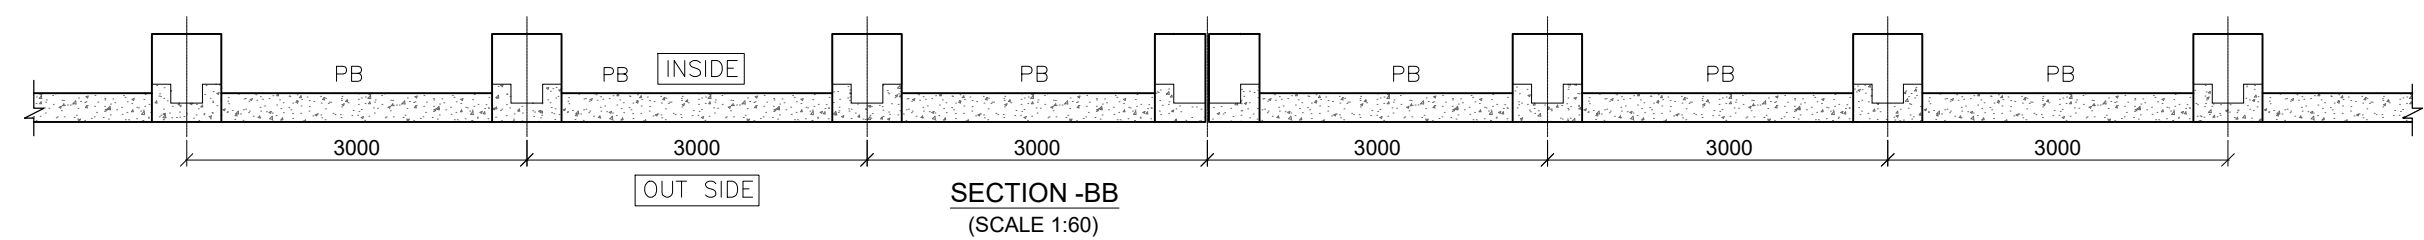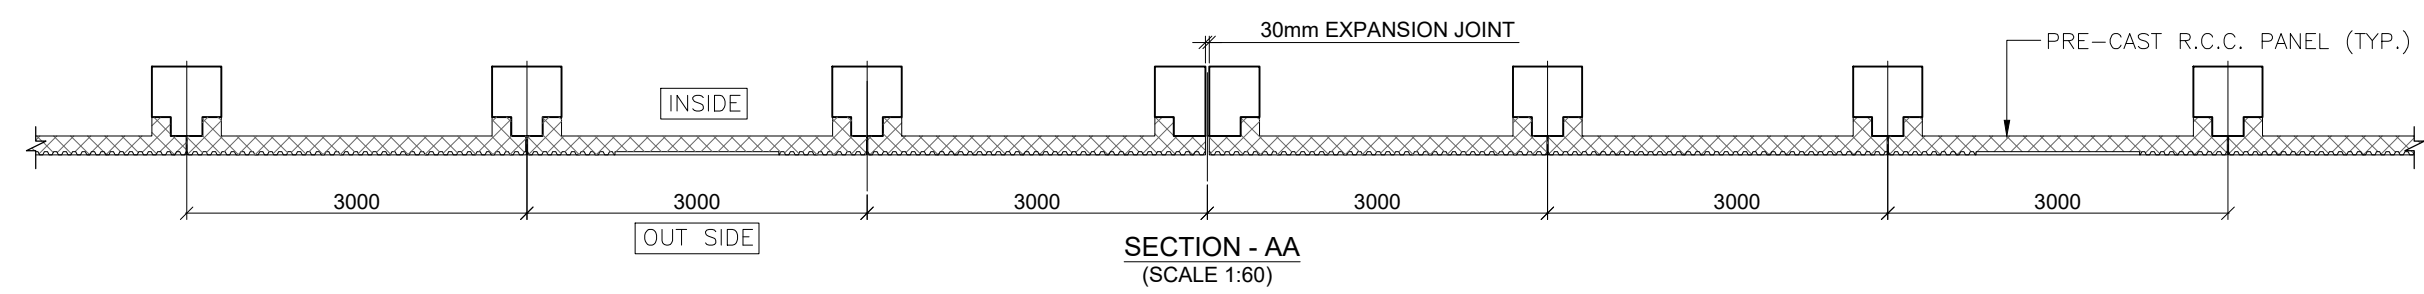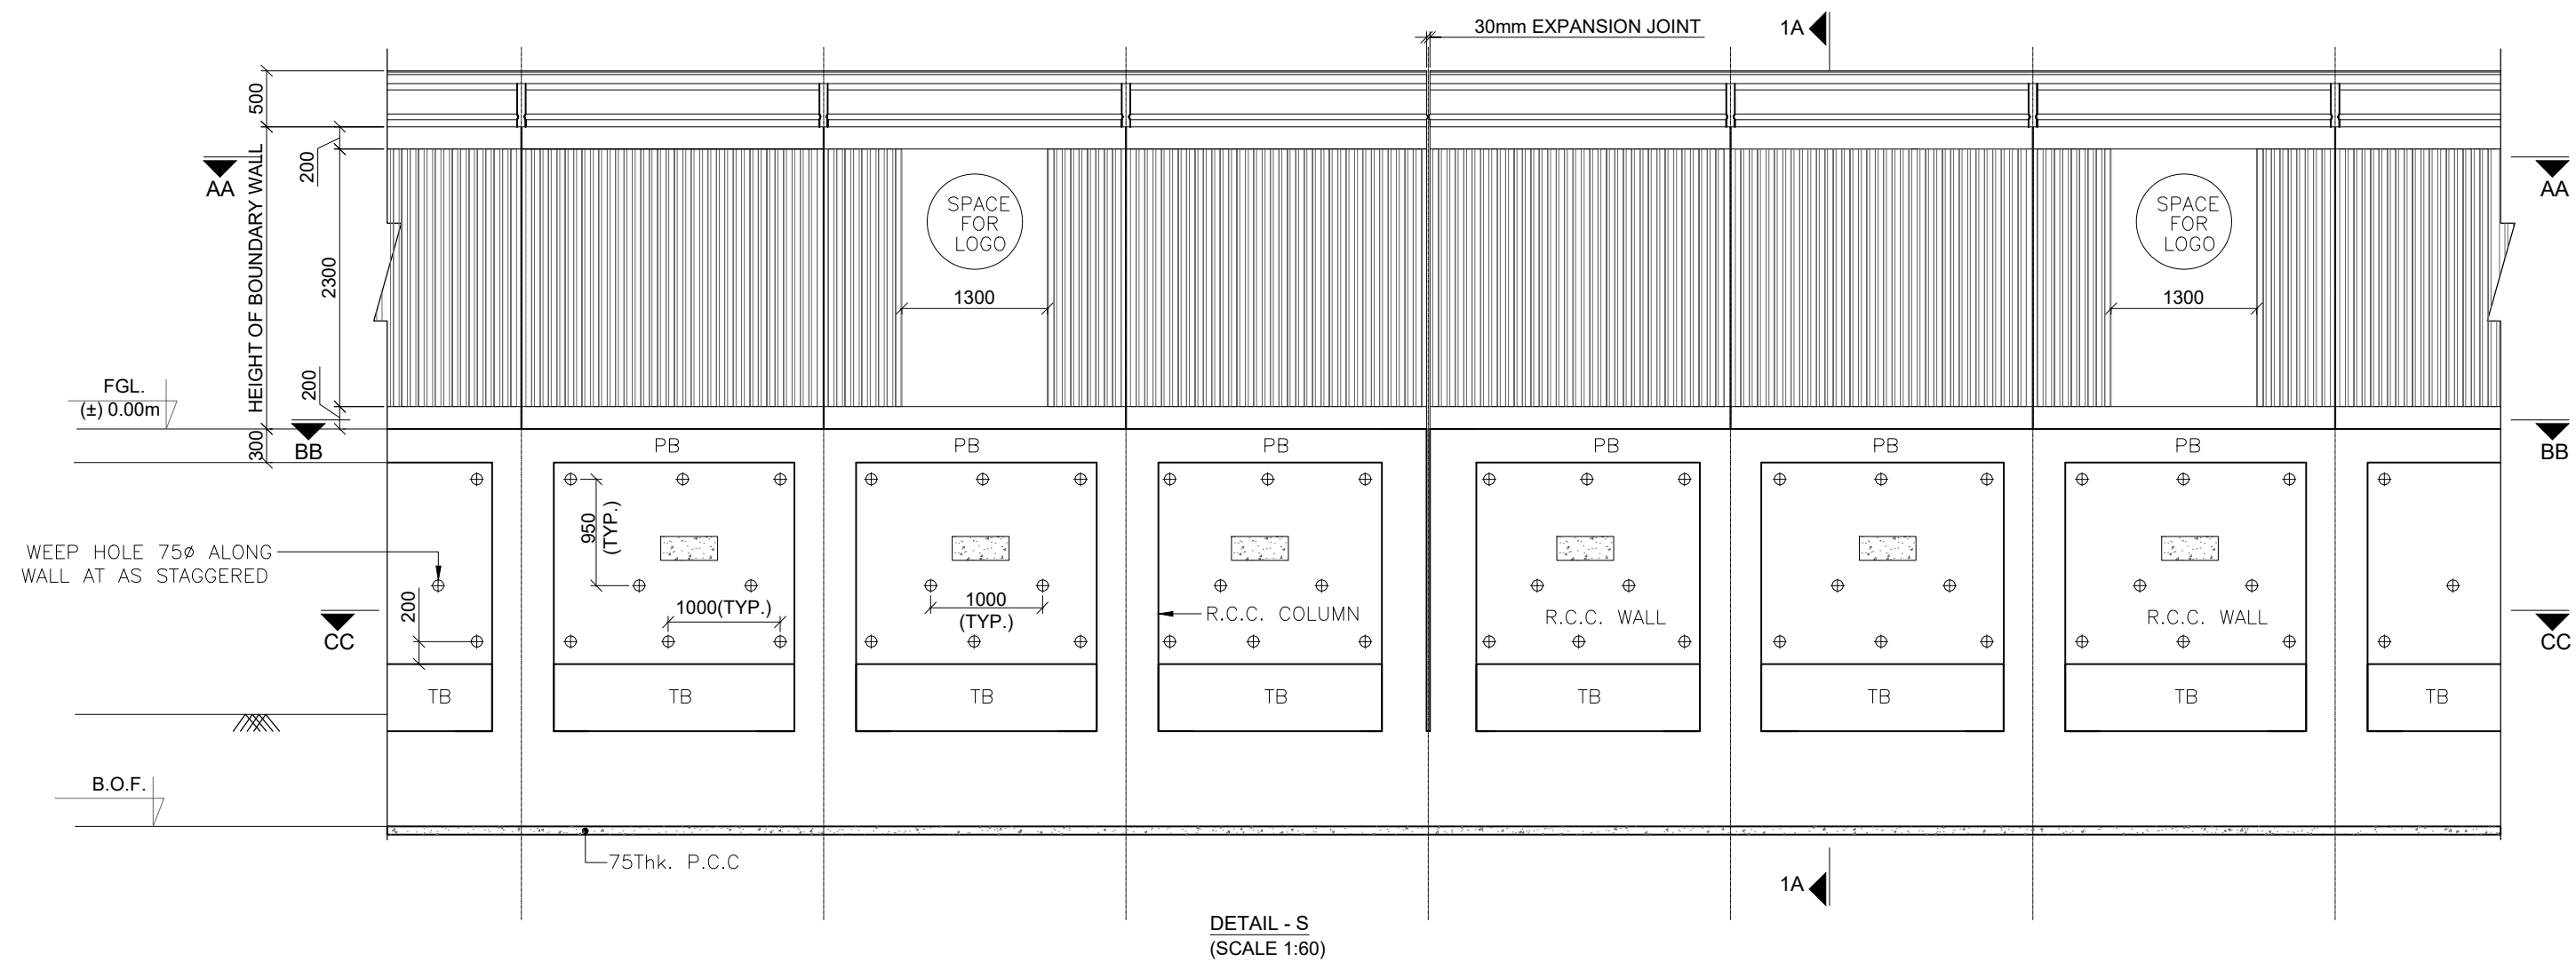

- NOTES:-
1. ALL DIMENSION ARE IN MM AND LEVELS ARE IN METER UNLESS OTHERWISE SPECIFIED.
 2. DRAWING SHALL BE READ & NOT MEASURED.
 3. DRAWING IS INDICATIVE.
 4. DIMENSION SHOWN IN THE DRAWING ARE INDICATIVE. ACTUAL DIMENSIONS TO BE DEVELOPED BY THE CONTRACTOR BASED ON THE EQUIPMENT REQUIREMENTS.

- LEGEND:-
- F.G.L. : FINISH GROUND LEVEL.
 - N.G.L. : NATURAL GROUND LEVEL.
 - LW: : LOWEST
 - PB : PLINTH BEAM
 - TB : TIE BEAM
 - PC : PILE CAP
 - PCP : PRE-CAST PANEL
 - B.O.B : BOTTOM OF BEAM
 - B.O.PC : BOTTOM OF PILE CAP

FOR TENDER PURPOSE ONLY

						K RIDE			Certified that this document has been designed and checked in accordance with GC Quality Assurance Plan.  EGIS-AECOM-WSP			Client:  RAIL INFRASTRUCTURE DEVELOPMENT COMPANY (KARNATAKA) LIMITED							
						DM / ELE / KRIDE	Sr. DGM / ELE / KRIDE	AGM / ELE / KRIDE	Senior Discipline Expert	Chief Discipline Expert	Project Director	Project Title: Bengaluru Suburban Rail Project (BSRP) (Detailed Design Consultant for design of Traction & Auxiliary Power Supply and Distribution for BSRP)							
									Certified that this document has been designed and checked in accordance with DDC Quality Assurance Plan. Detailed Design Consultant for design of Traction & Auxiliary Power Supply and Distribution for BSRP  SYSTRAMVA CONSULTING (INDIA) PVT. LTD. 10th and 11th Floor, Tower-B, 12/3, Vatika Mindscapes, Mathura Road, NH2, Sector 27D, Faridabad, Haryana 121015			Corridor-2 (Benniganahalli - Chikkabanavara)		Project Stage:					
									Drawing Title:		Tender Drawing								
									SECTION DETAIL OF BOUNDARY WALL										
						Drawn		Checked:		Approved:		Paper Size: A1		Discipline:		Date:		Scale: AS SHOWN	
												Drawing no.: KRDD01-TDR-GEN-GEN-TPS-DWG-00107		Revision:		R0			